

 
2/10/2017 5:10:52 PM M:\LAND PROJECTS 2012\10207 LA CROSSE, WI - GEORGE ST\DWG3 GRADING.DWG

GRADING LEGEND:

- EXISTING CONTOUR
PROPOSED CONTOUR
FINISHED GROUND ELEVATION
TOP OF CURB ELEVATION
GUTTER ELEVATION
TOP OF WALL ELEVATION
BOTTOM OF WALL ELEVATION
EDGE OF WALK ELEVATION
TOP OF STAIR ELEVATION
BOTTOM OF STAIR ELEVATION


NOTE: WALL ELEVATIONS SHOWN ON PLAN ARE FINISHED GROUND GRADES AT THE TOP AND BOTTOM OF THE WALL.

GRAPHIC SCALE



TOPSOIL NOTES:

1. STRIP AND STOCKPILE THE TOP 6" OF SOIL ON ALL DISTURBED AREAS.
2. RESPREAD TOPSOIL TO A MINIMUM DEPTH OF 6" ON ALL GREEN (NON PAVED) AREAS. IMPORT TOPSOIL AS NECESSARY TO ACHIEVE A MINIMUM DEPTH OF 6".
3. **TOPSOIL SHALL BE FREE OF ALL ROCK AND DEBRIS LARGER THAN 3/4" IN SIZE.**
4. TOPSOIL IS DEFINED AS: FERTILE, FRIABLE LOAM, CAPABLE OF SUSTAINING VIGOROUS PLANT GROWTH, FROM WELL DRAINED SITE FREE FROM FLOODING, NOT IN FROZEN OR MUDDY CONDITIONS, REASONABLY FREE FROM SUBSOIL, CLAY LUMPS, ROOTS, GRASS, WEEDS, STONES LARGER THAN 3/4 INCH IN DIAMETER, AND FOREIGN MATTER; ACIDITY RANGE (PH) OF 5.5 TO 7.5; CONTAINING MINIMUM 4 PERCENT AND MAXIMUM 20 PERCENT ORGANIC MATTER.
5. CONTRACTOR SHALL BE RESPONSIBLE FOR ENSURING ALL TOPSOIL REQUIREMENTS OF NPDES GENERAL PERMIT NO. 2 ARE MET.

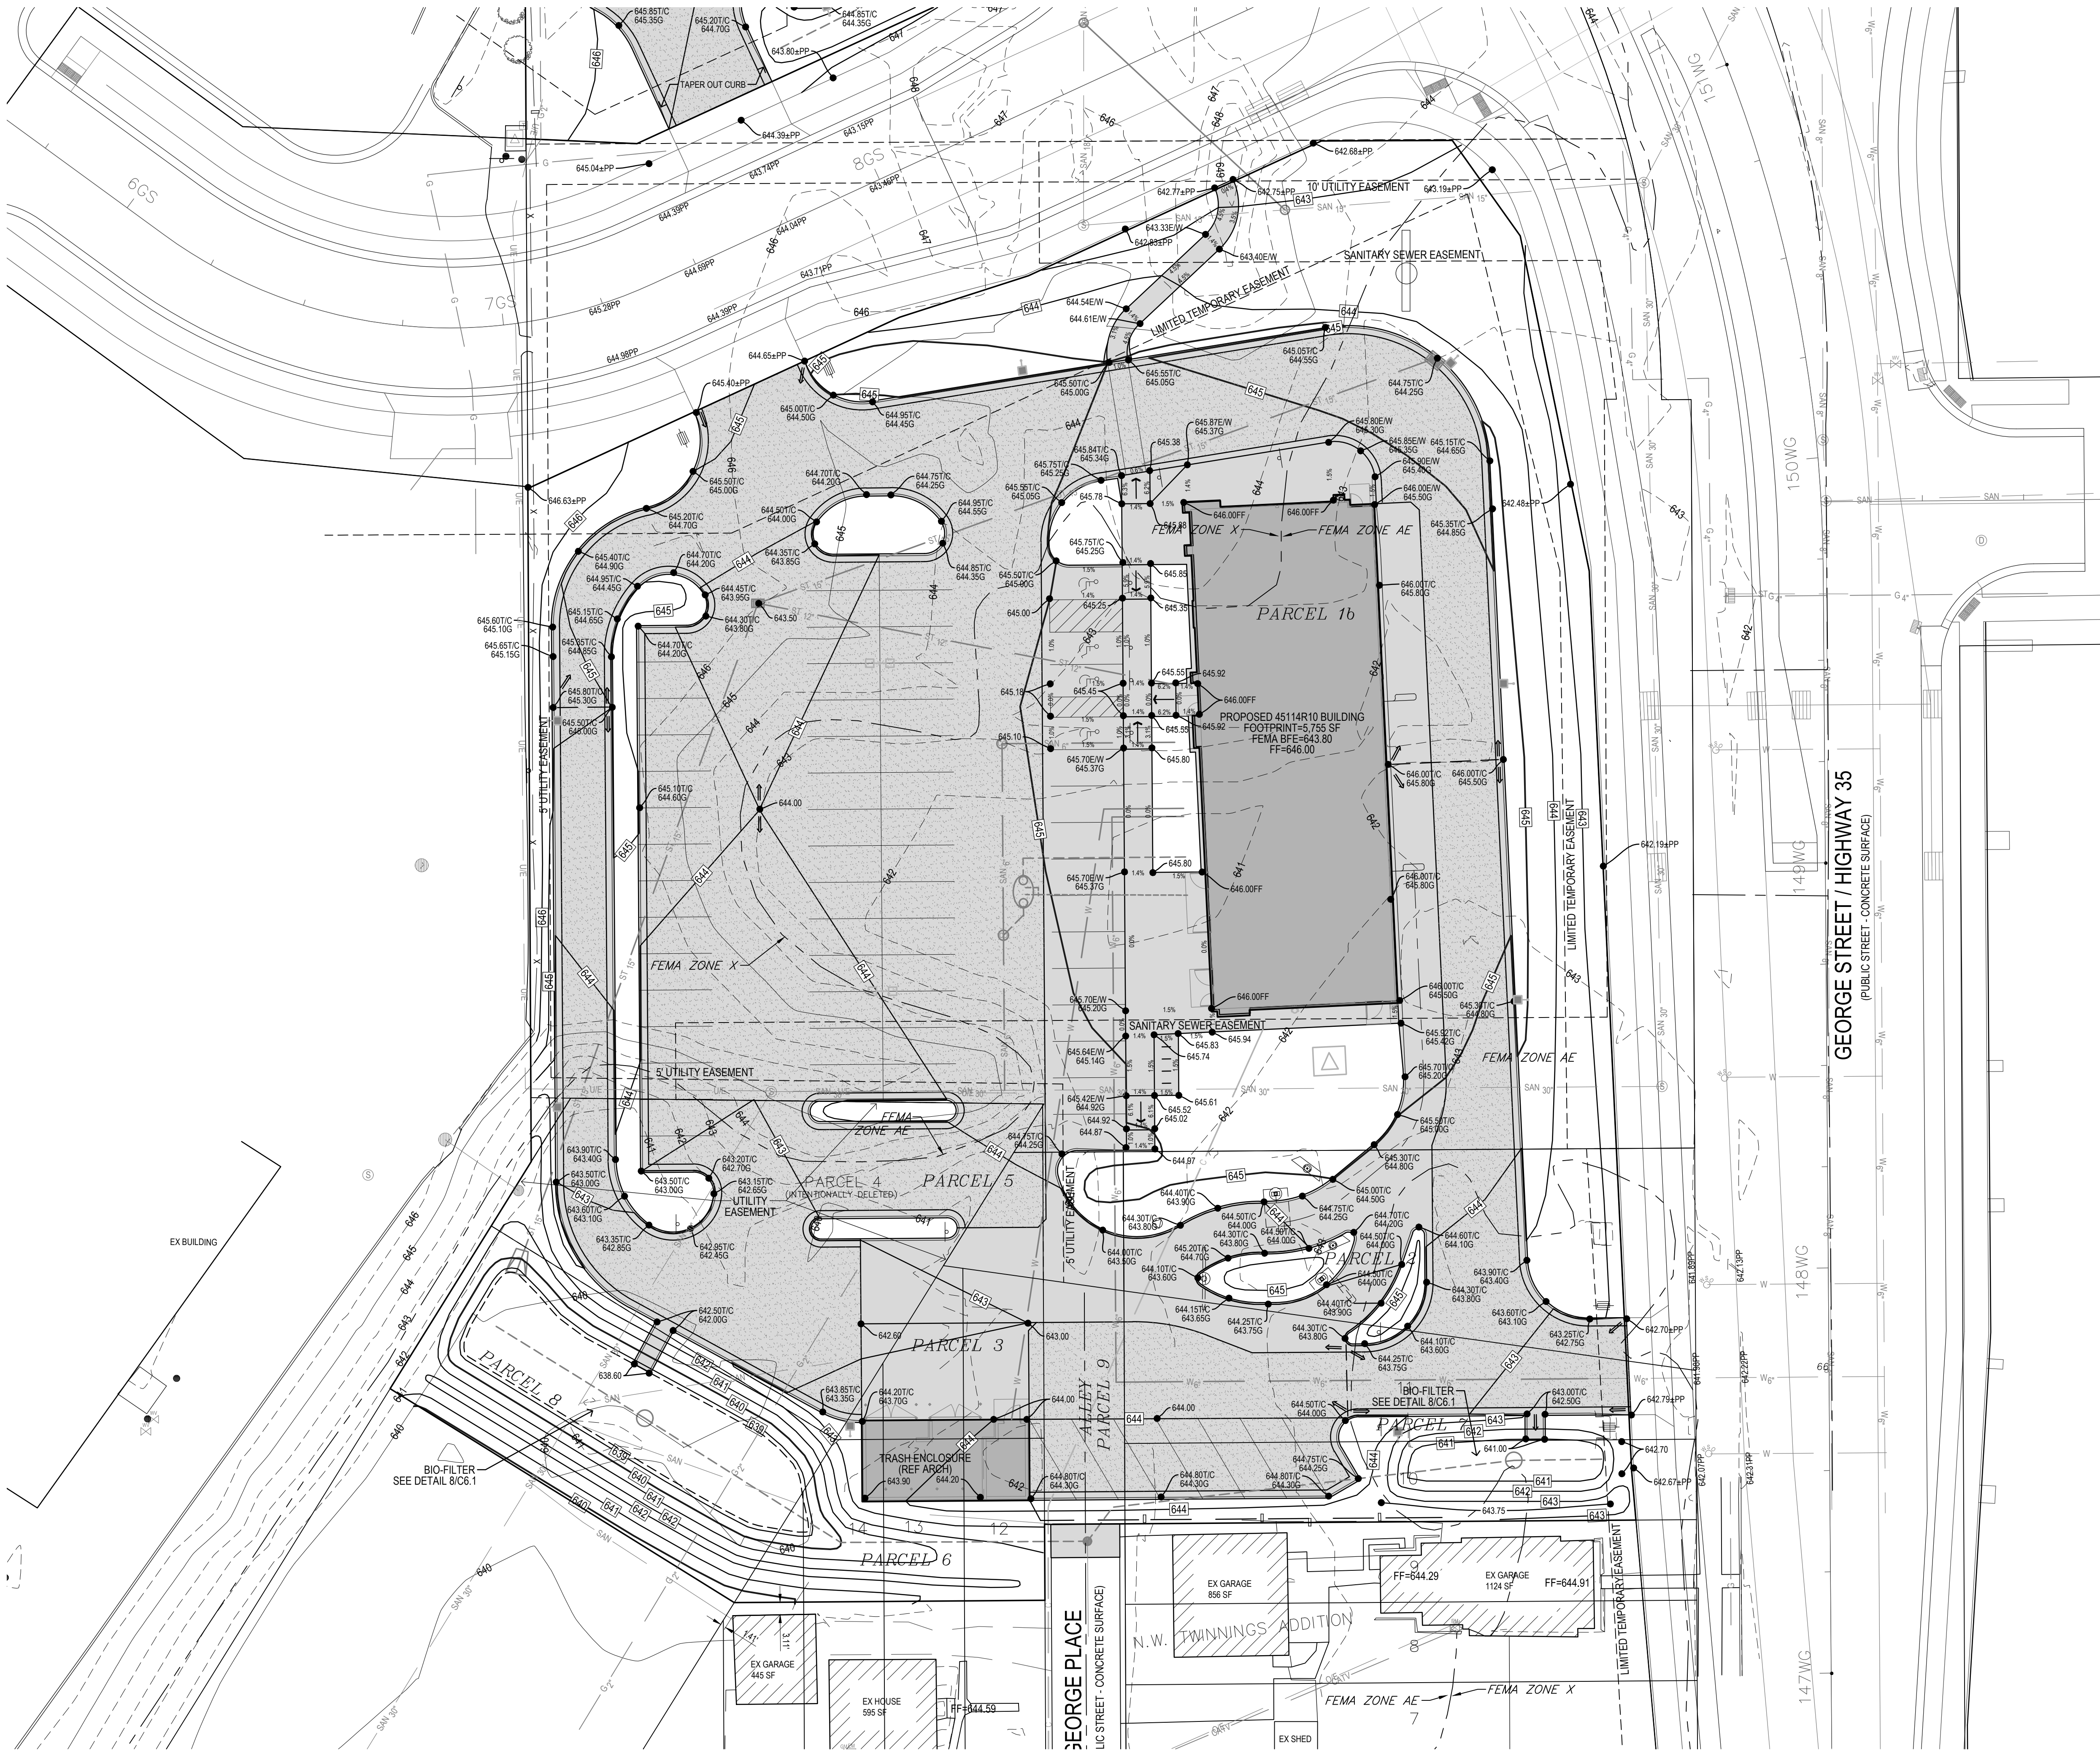

SHEET NO.	TITLE		DRAWN BY	PREPARED BY		© 2017 McDonald's USA, LLC		</	
-----------	-------	--	----------	-------------	--	---------------------------------------	--	---	--

Bishop Engineering

Training Your Successful Development

Des Moines, Iowa 50323-3825
Phone: 515.281.4444 Fax: 515.281.4447
Civil Engineering & Land Surveying
Established 1959

© 2017 McDonald's USA, LLC

McDonald's USA, LLC



These drawings and specifications are the confidential and proprietary property of McDonald's USA, LLC and shall not be copied or reproduced without written authorization. The contract documents were prepared for use on a different site or at a later time. Use of these drawings for reference or example on another project requires the user to obtain the necessary permission from McDonald's USA, LLC. The contract documents for reuse on another project is not authorized.

GRADING LEGEND

- | | | |
|---------------------------|---|-----------|
| EXISTING CONTOUR |  | -150- |
| PROPOSED CONTOUR |  | 150 |
| FINISHED GROUND ELEVATION |  | 150.50 |
| TOP OF CURB ELEVATION |  | 150.50T/C |
| GUTTER ELEVATION |  | 150.50G |
| TOP OF WALL ELEVATION |  | 150.50T/W |
| BOTTOM OF WALL ELEVATION |  | 150.50B/W |
| EDGE OF WALK ELEVATION |  | 150.50E/W |
| TOP OF STAIR ELEVATION |  | 150.50T/S |
| BOTTOM OF STAIR ELEVATION |  | 150.50B/S |

NOTE: WALL ELEVATIONS SHOWN ON PLAN ARE FINISHED
GROUND GRADES AT THE TOP AND BOTTOM OF THE WALL



 
GRAPHIC SCALE

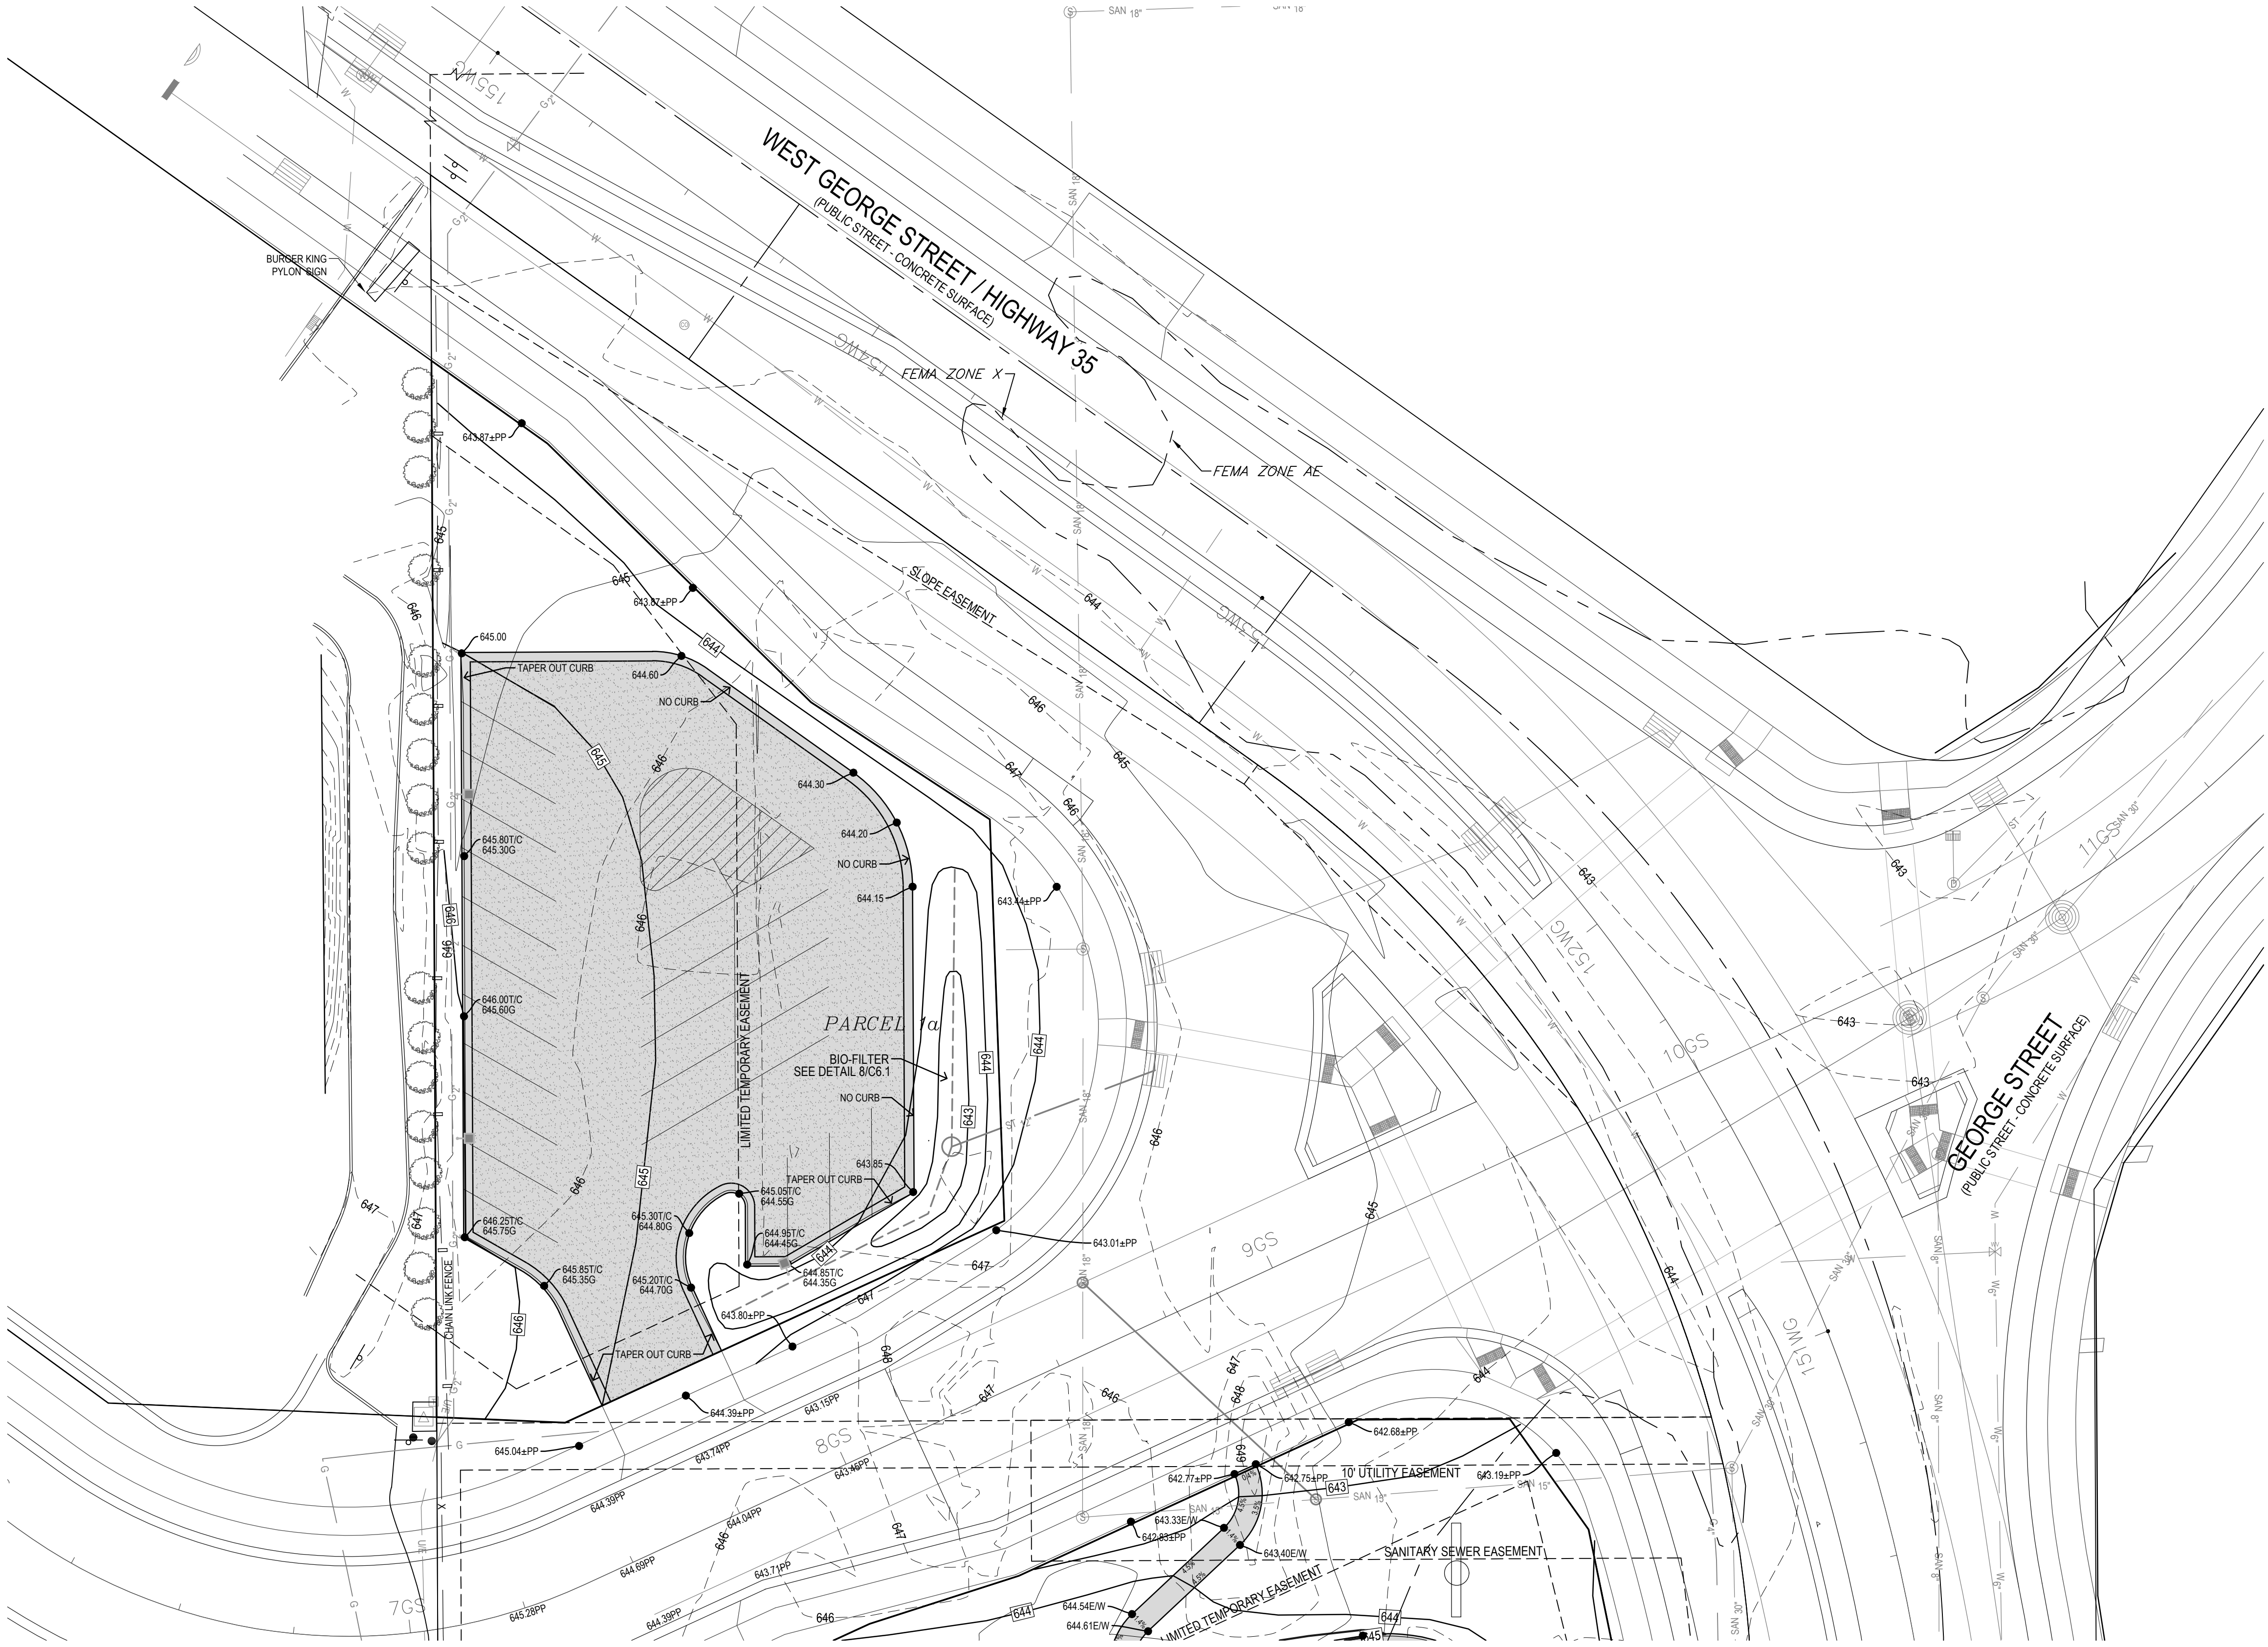

SHEET NO.	C3.2	TITLE:	LA CROSSE, WI SITE PLAN
DRAWN BY	JMR	DATE ISSUED	2/10/2017
STD ISSUE DATE	2/10/2017	REVIEWED BY	JEJ
DESCRIPTION	GRADING PLAN	DATE ISSUED	2/10/2017
SITE ID	480054	SITE ADDRESS	1140 W GEORGE ST. LA CROSSE, WI 54601
PREPARED FOR:	© 2017 McDonald's USA, LLC		
MCDONALD'S USA, LLC	These drawings and specifications are the confidential and proprietary property of McDonald's USA, LLC and shall not be copied or reproduced without the express written consent of McDonald's USA, LLC. The use of any part of this drawing on any specific site in conjunction with its issue date and are not suitable for use on a different site or at a later time. Use of the drawings and specifications on any other project without the written approval of McDonald's USA, LLC constitutes an unauthorized reproduction of the contract documents for reuse on another project is not authorized.		
PREPARED BY:	 Bishop Engineering "Planning Your Successful Development" 3501 104th Street Des Moines, IA 50323 Phone: (515)276-4467 Fax: (515)276-0217 Civil Engineering & Land Surveying Established 1959		
DRAWN BY	JEJ	REV	1
DATE	2/10/2017	DATE	2/16/17
DESCRIPTION	1ST CITY SUBMITTAL	DESCRIPTION	
BY		BY	



UTILITY NOTES:

 1. ALL PROPOSED UTILITIES SHALL BE PRIVATE, UNLESS NOTED OTHERWISE.
2. ALL WATER LINES SHALL HAVE A MINIMUM OF 7' OF COVER UNLESS NOTED OTHERWISE.
3. FIRE HYDRANT ASSEMBLY SHALL INCLUDE THE TEE, BRANCH, VALVE AND HYDRANT.
4. PIPE LENGTHS CALLED OUT ON PLANS INCLUDE FLARED END SECTION, WHERE APPLICABLE.
5. STORM SEWER CALLED OUT AS RCP MUST BE CLASS III RCP.
6. FOR RCP PIPE, ASSOCIATED F.E.S. MUST BE RCP. FOR N-12 PIPE, ASSOCIATED F.E.S. SHALL BE CMP.
7. TRANSFORMER PAD IS SHOWN FOR REFERENCE ONLY AND MAY NOT BE DRAWN TO ACTUAL SIZE.
8. PAD SHALL CONFORM TO ALL UTILITY COMPANY DESIGN STANDARDS AND SPECIFICATIONS.
9. GREASE INTERCEPTOR IS SHOWN FOR REFERENCE ONLY AND MAY NOT BE DRAWN TO ACTUAL SIZE. REFER TO PLUMBING PLANS FOR DETAILED DRAWINGS AND SPECIFICATIONS. PLUMBING PLANS SHALL TIE INTO SANITARY SERVICE AT LOCATION AND ELEVATION SHOWN ON PLAN.
10. GREASE INTERCEPTOR SHALL BE LOCATED OUTSIDE OF THE DRIVE-THRU LANE. RIM ELEVATIONS SHALL BE PLUSH WITH PAVEMENT GRADE.
11. GREASE INTERCEPTOR VENT LINES & GREASE LINES ARE SHOWN FOR REFERENCE ONLY. REFER TO PLUMBING PLANS FOR DETAILED PLANS AND SPECIFICATIONS.

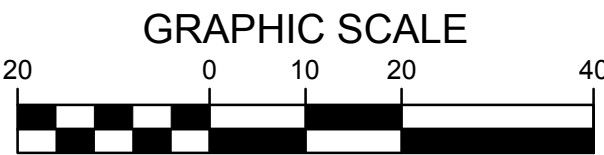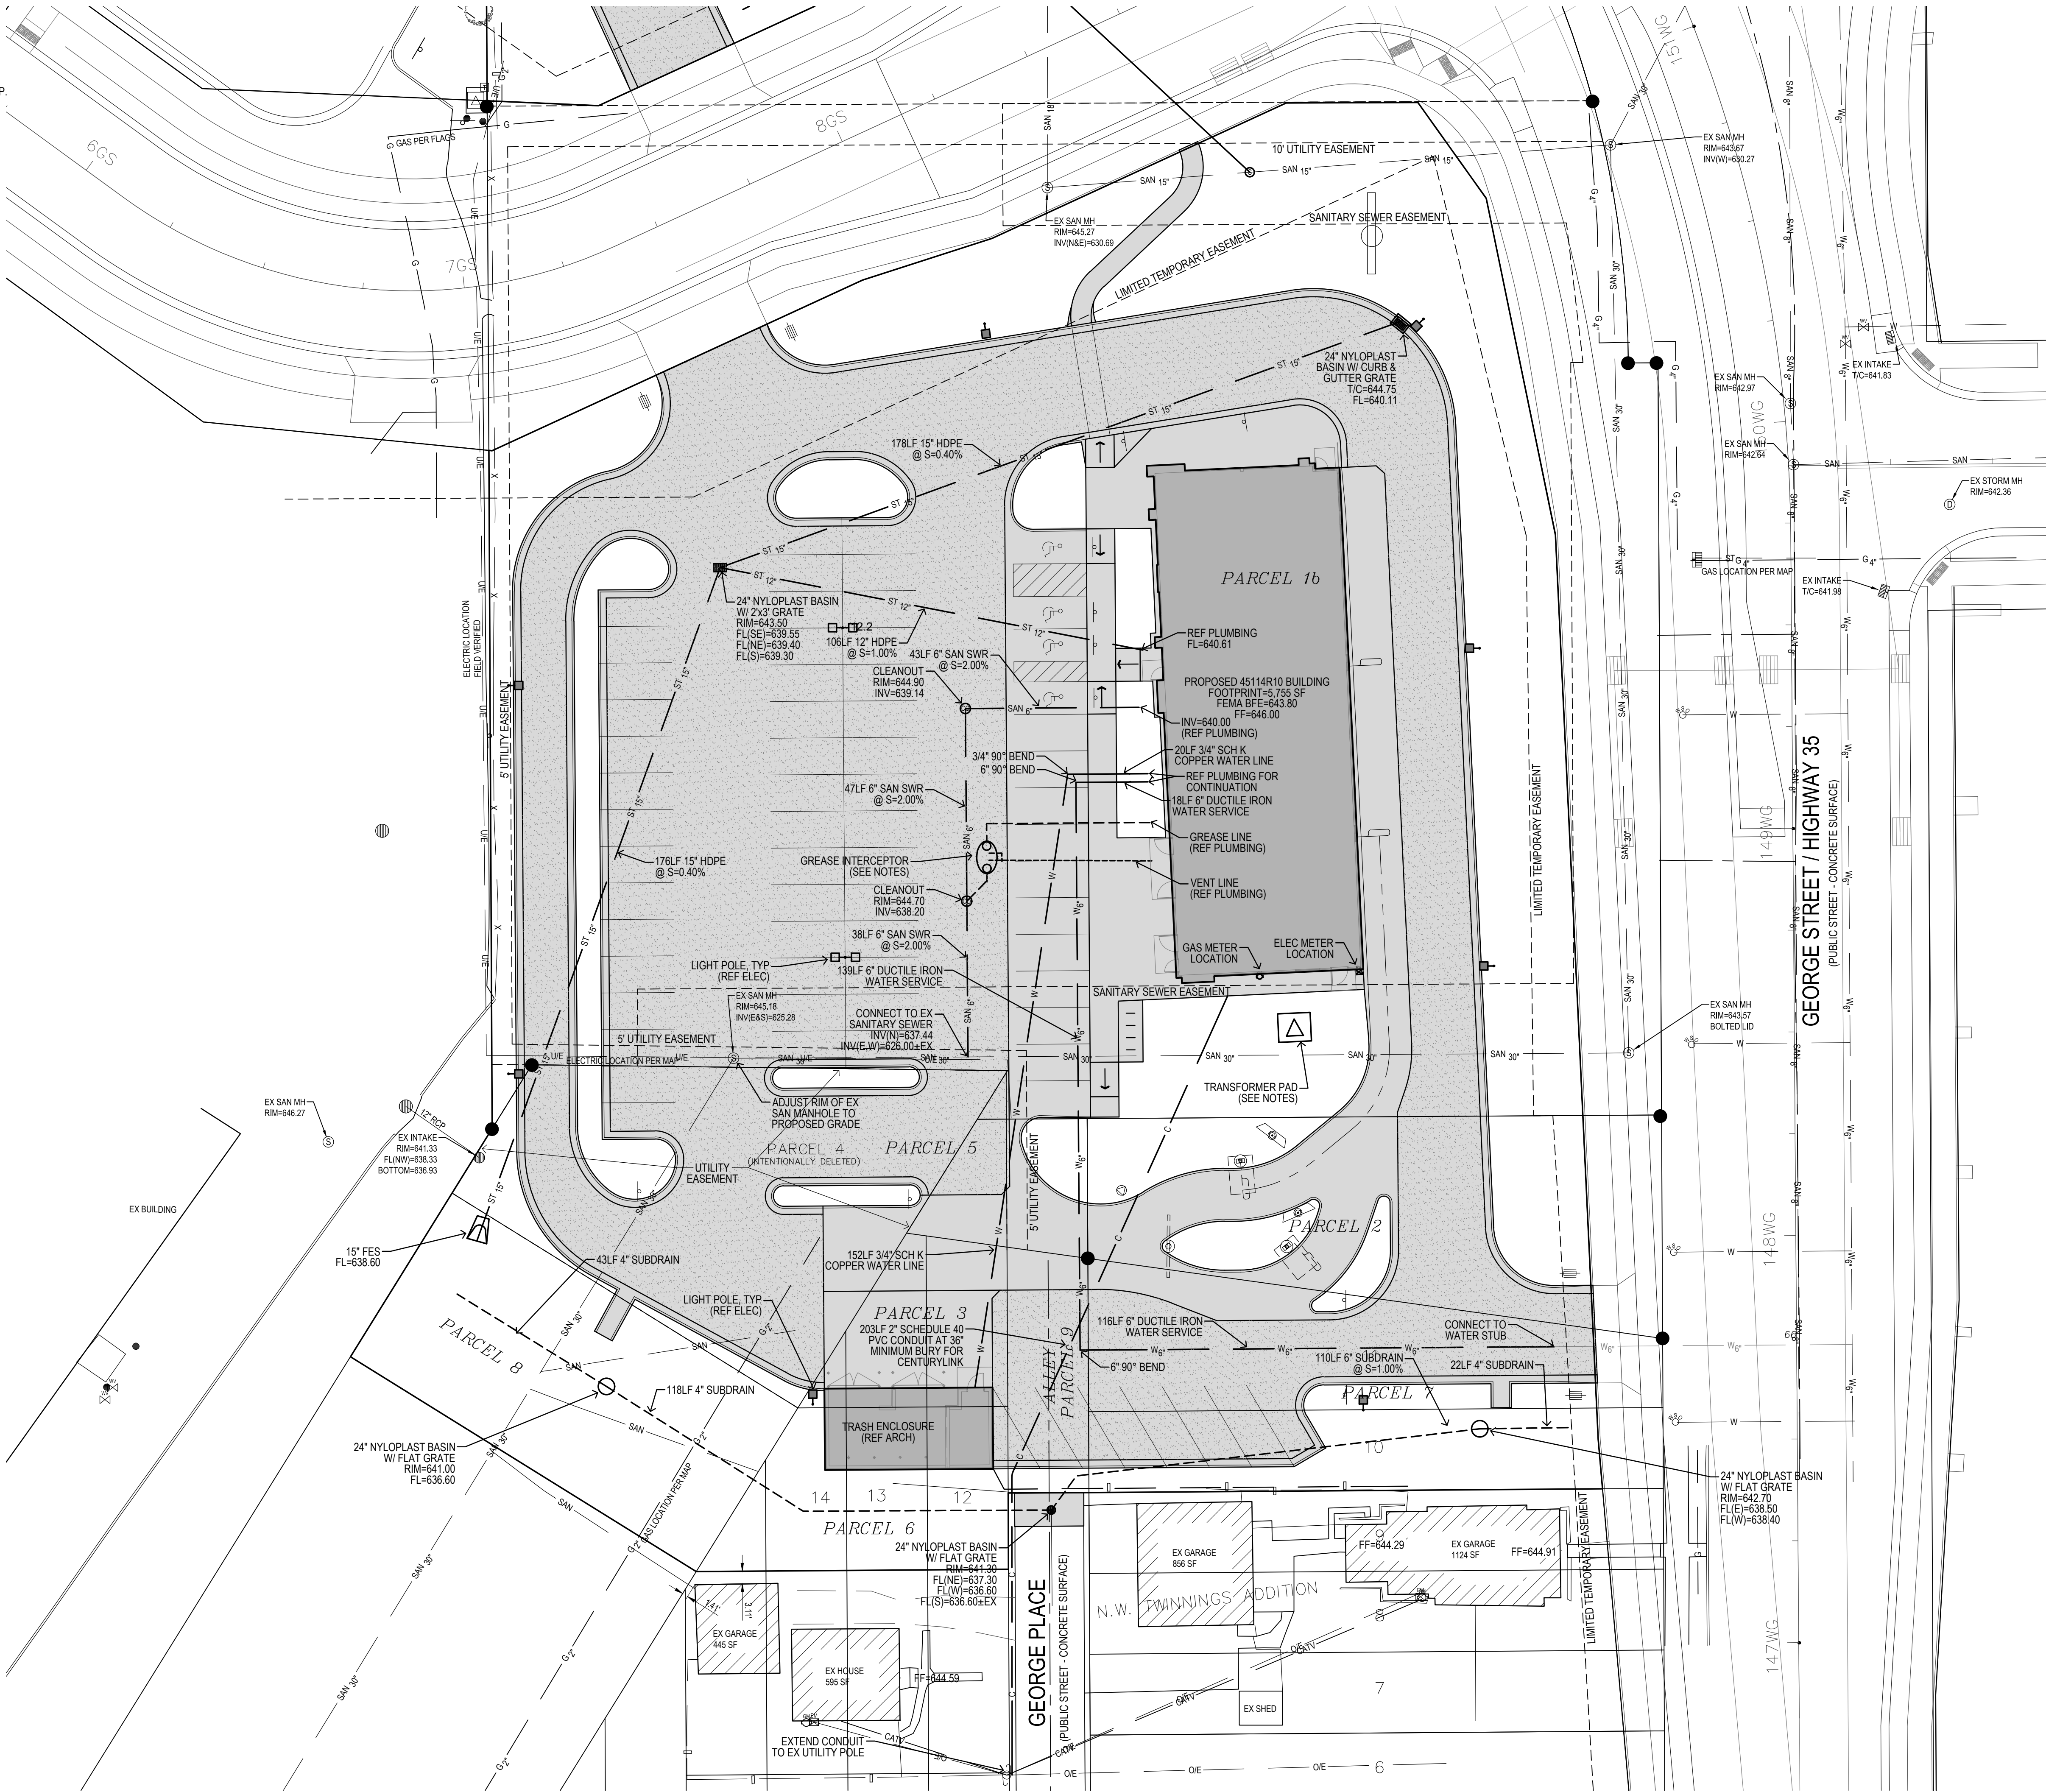

2/16/2017 4:55:00 PM M:\LAND PROJECTS\2012\120207 LA CROSSE, WI - GEORGE ST.DWG\C4 UTILITY.DWG

SHEET NO.		TITLE		DRAWN BY	PREPARED FOR:	PREPARED BY															
		LA CROSSE, WI		JMR		© 2017 McDonald's USA, LLC															
		SITE PLAN		2/10/2017	STD ISSUE DATE	M. McDonald's USA, LLC		These drawings and specifications are the confidential and proprietary property of McDonald's USA, LLC and shall not be copied or reproduced without written authorization. The contract documents were prepared by McDonald's USA, LLC and shall not be used for any other project or not suitable for use on a different site or at a later time. Use of these drawings for reference or example on another project requires the approval of McDonald's USA, LLC. The contract documents for reuse on another project is not authorized.				Bishop Engineering "Planning Your Successful Development"		3501 104th Street Des Moines, Iowa 50323-3825 Phone: 515-281-4646 Fax: 515-281-4627							
		UTILITY PLAN		JEJ	DATE ISSUED																
SHEET ID		SITE ADDRESS		2/10/2017																	
480054		1140 W GEORGE ST, LA CROSSE, WI 54601																			
C4.1																					
BE # 120207																					

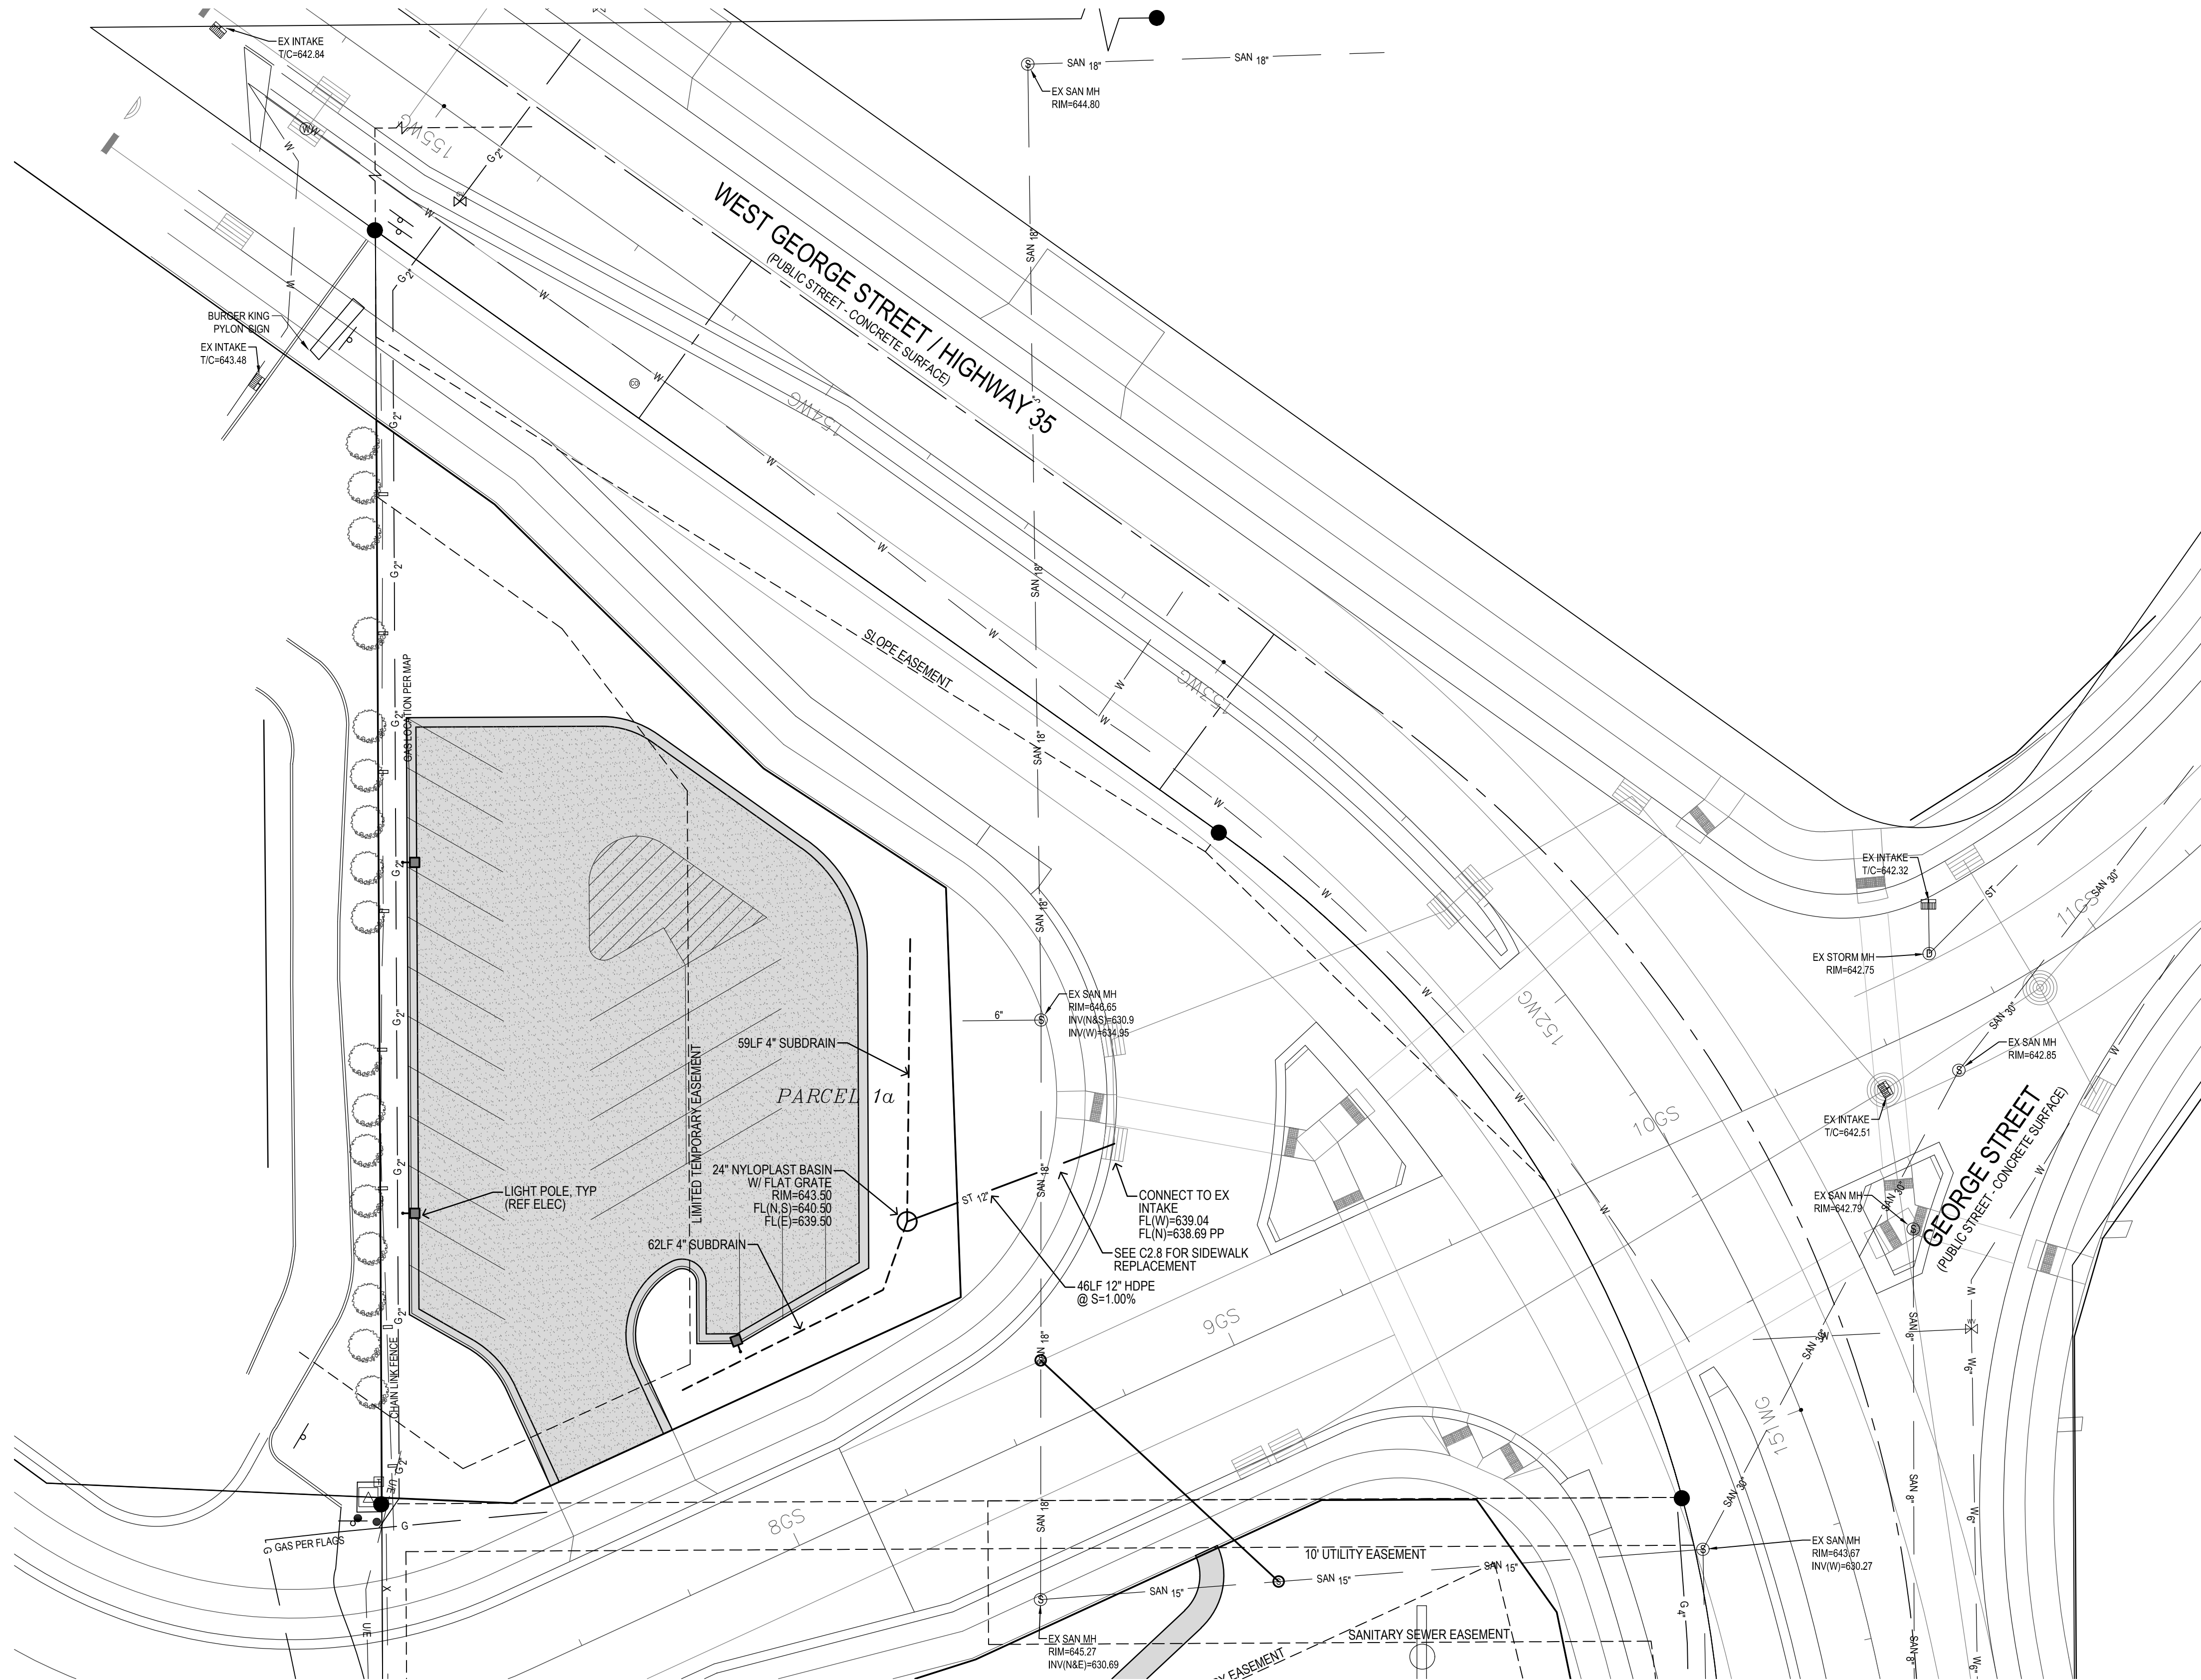 

SHEET NO.	TITLE		DRAWN BY	PREPARED FOR	© 2017 McDonald's USA, LLC		PREPARED BY																																																																																																																																																																																																																																																																																																																																																																																																																																																																																																																																																																																																																																																																																																																																																																																																																																																																																																																																																																																																																																																																																																																																																																																																																																																																																																																																																																																																																																										
-----------	-------	--	----------	--------------	----------------------------	--	-------------	--	--	


1. LIGHTING PLAN WAS PREPARED BY SECURITY LIGHTING SYSTEMS. FOR QUESTIONS CONTACT MARK WERTH (1-800-544-4848 x168) MWERTH@SECURITYLIGHTING.COM

1. THE FOOTCANDLE LEVELS AS SHOWN ARE BASED ON THE FOLLOWING CRITERIA, ANY SUBSTITUTIONS IN SPECIFIED FIXTURES OR CHANGES TO LAYOUT WILL AFFECT LIGHTING LEVELS SHOWN AND WILL NOT BE THE RESPONSIBILITY OF SECURITY LIGHTING.
2. THE CONTRIBUTION OF THE SOFFIT / BUILDING LIGHTING IS NOT REFLECTED ON THE DRAWING UNLESS SOFFIT / BUILDING LIGHTING IS SPECIFIED IN THE FIXTURE SCHEDULE BELOW.
3. DISTANCE BETWEEN READINGS 10'
4. FINAL ADJUSTMENTS TO AIMING ANGLE/DIRECTION OF FIXTURES MAY BE REQUIRED TO ELIMINATE LIGHT TRESPASS OR GLARE ONTO ADJOINING PROPERTIES OR ROADWAYS.

THIS DRAWING MEETS OR EXCEEDS McDONALDS CURRENT ILLUMINATION SPECIFICATIONS OF A 3-FOOTCANDLE AVERAGE, UNLESS SUPERSEDED BY OTHER REQUIREMENTS.

THIS LIGHTING PATTERN REPRESENTS ILLUMINATION LEVELS CALCULATED FROM LABORATORY DATA TAKEN UNDER CONTROLLED CONDITIONS IN ACCORDANCE WITH ILLUMINATING ENGINEERING SOCIETY APPROVED METHODS. ACTUAL PERFORMANCE OF ANY MANUFACTURER'S LUMINAIRES MAY VARY DUE TO VARIATION IN ELECTRICAL VOLTAGE, TOLERANCE IN LAMPS, AND OTHER VARIABLE FIELD CONDITIONS.

2100 Golf Road, Suite 460, Rolling Meadows, IL 60009

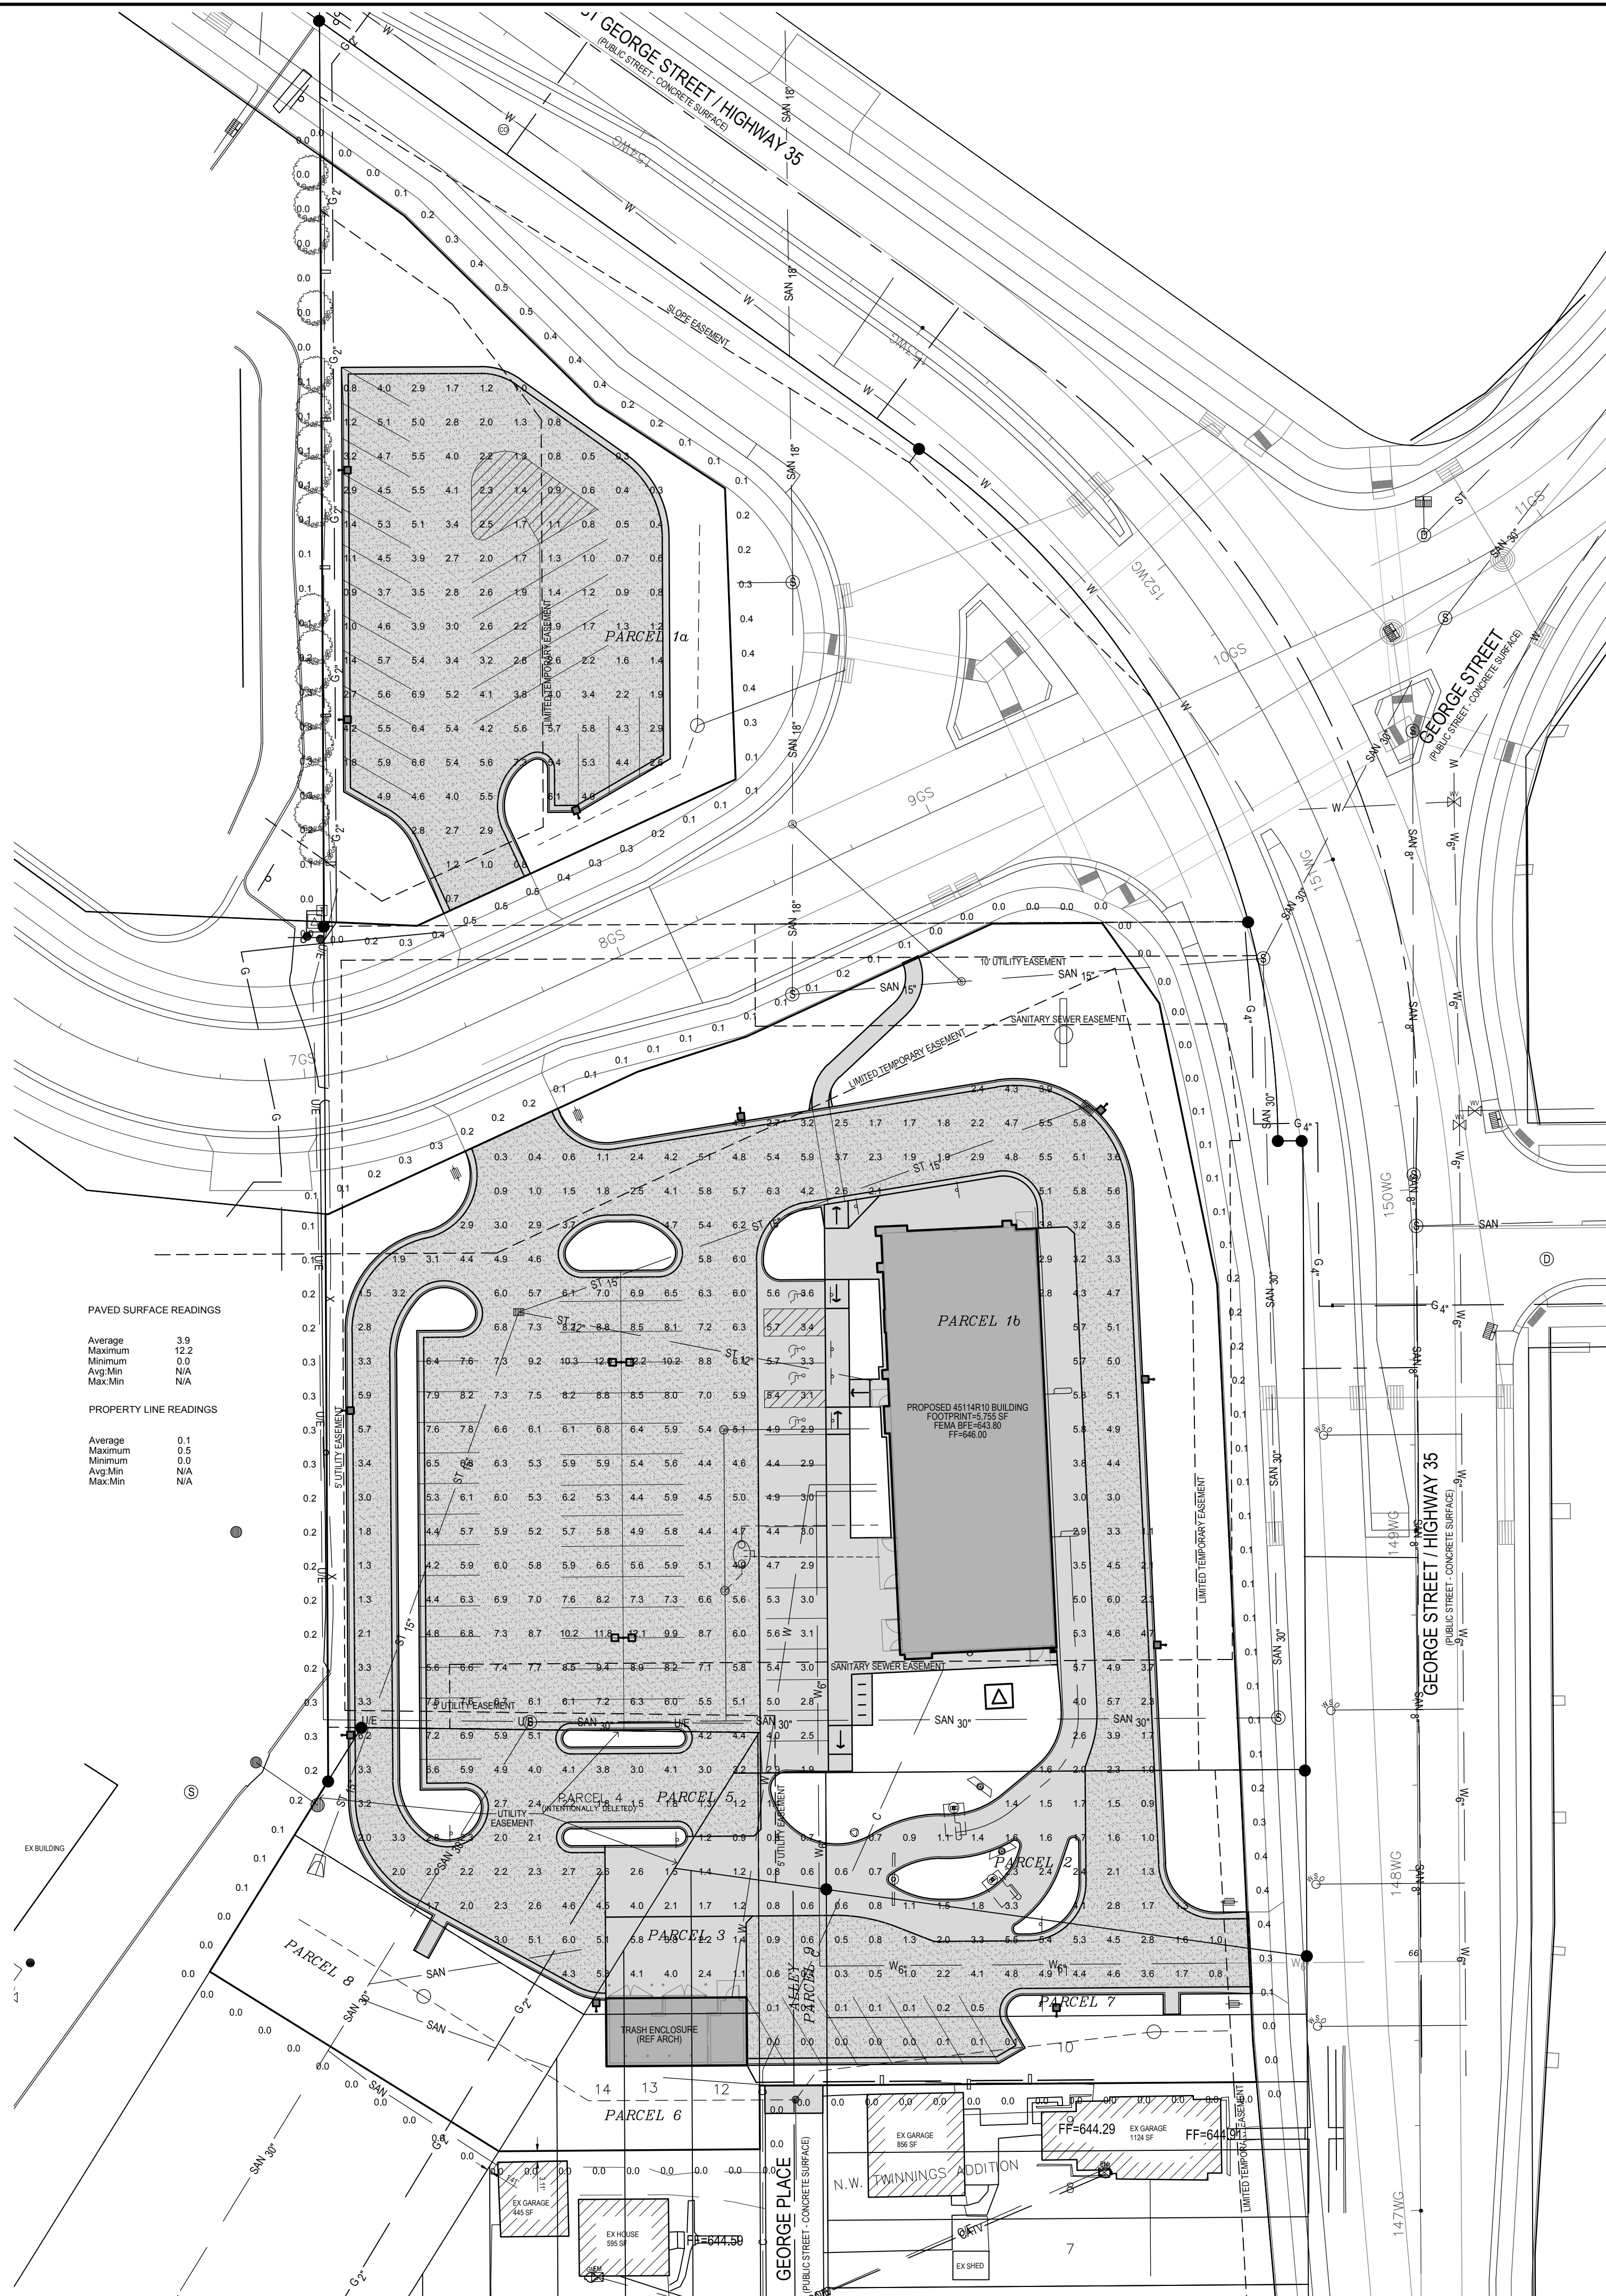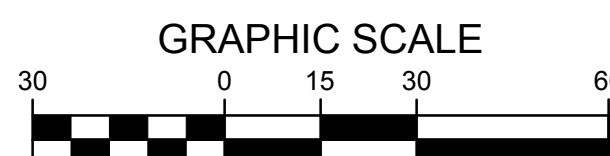[illegible]

SHEET NO.	C4.3
TITLE:	LA CROSSE, WI SITE PLAN
DRAWN BY	JMR
PREPARED FOR:	© 2017 McDonald's USA, LLC
STD ISSUE DATE	2/10/2017
REVIEWED BY	JEJ
DATE ISSUED	2/10/2017
SHEET ADDRESS	1140 W GEORGE ST, LA CROSSE, WI 54601
SHEET NO.	480054
DESCRIPTION	LIGHTING PLAN
DATE	2/16/17
REV	1
DESCRIPTION	1ST CITY SUBMITAL
BY	JEJ



2/16/2017 4:55:06 PM M:\LAND PROJECTS 2012\120207 LA CROSSE, WI - GEORGE STDWG\C4 UTILITY.DWG

1. ALL SODDING & LANDSCAPE PLANTINGS SHALL BE INSTALLED IN ACCORDANCE WITH STANDARD SPECIFICATIONS, UNLESS SPECIFIED OTHERWISE.
2. SOD ALL DISTURBED AREAS WITHIN THE CONTRACT LIMITS, UNLESS NOTED OTHERWISE.
3. STAKE SOD ON ALL SLOPES 3 : 1 OR GREATER.
4. PLANT QUANTITIES ARE FOR CONTRACTORS CONVENIENCE, THE DRAWING SHALL PREVAIL IF A CONFLICT OCCURS.
5. ALL PLANT MATERIAL SHALL CONFORM TO THE LATEST EDITION OF THE AMERICAN STANDARD FOR NURSERY STOCK (ANSI Z60.1).
6. CONTRACTOR SHALL GUARANTEE ALL PLANT MATERIAL FOR A PERIOD OF ONE YEAR FROM THE DATE OF ACCEPTANCE.
7. IT IS THE CONTRACTORS RESPONSIBILITY TO REMOVE IDENTIFICATION TAGS AND CORDS ON ALL PLANT MATERIAL PRIOR TO THE COMPLETION OF THE CONTRACT.
8. CONTRACTOR SHALL PLACE SHREDDED HARDWOOD MULCH AROUND ALL TREES, SHRUBS AND GROUND COVER BEDS TO A DEPTH OF 4 INCHES.
9. STAKE AND WRAP ALL DECIDUOUS TREES IMMEDIATELY AFTER PLANTING. STAKE ALL TREES ACCORDING TO THE STAKING DETAILS. CONTRACTOR SHALL ADJUST AND MAINTAIN GUYING TENSION THROUGHOUT THE PLANT ESTABLISHMENT PERIOD.
10. THE LANDSCAPING CONTRACTOR SHALL HAVE ALL UTILITIES LOCATED BEFORE STARTING ANY SITE WORK OR PLANTING. THE CONTRACTOR SHALL BE RESPONSIBLE FOR THE PROTECTION OF ALL EXISTING UTILITIES.
11. NO LANDSCAPE MATERIAL SHALL BE SUBSTITUTED WITHOUT THE AUTHORIZATION OF THE LANDSCAPE ARCHITECT.
12. ALL EDGING SHALL BE DURAEDGE 1/8" STEEL EDGING - COLOR GREEN, OR APPROVED EQUAL.
13. CONTRACTOR SHALL BE RESPONSIBLE MAINTAINING APPROPRIATE LEVEL OF WATERING FOR ALL NEW PLANTS FOR A PERIOD OF 30 DAYS.
14. ALL SHRUB AND PERENNIAL PLANTING BEDS SHALL INCORPORATE TYPAR 3301 NONWOVEN LANDSCAPE FABRIC (OR SIMILAR) AND 3" THICK WASHED RIVER ROCK (1.5" NOMINAL SIZE).
15. ALL BEDS TO RECEIVE PRE-EMERGENT WEED CONTROL BEFORE AND AFTER MULCH IS INSTALLED.

CODE	QUAN	COMMON NAME	LATIN NAME	SIZE	ROOT	NOTES
RO	10	RED OAK	QUERCUS RUBRA	2' CAL	B&B	MATCHED SPECIMENS (SINGLE TRUNK)
HB	9	HACKBERRY	CELSTIS OCCIDENTALIS	1.5" CAL	B&B	MATCHED SPECIMENS
SB	2	AUTUMN BRILLIANCE SERVICEBERRY	AMELANCHIER X GRANDIFLORA 'AUTUMN BRILLIANCE'	1.5" CAL	B&B	MATCHED SPECIMENS
KR	14	KNOCKOUT ROSE	ROSA X 'RAD RAZZ'	#5	CONT	FULL FORM - MATCHED
AIV	22	ANTHONY WATERER SPIREA	SPIRAEA BUMALDA 'ANTHONY WATERER'	#5	CONT	FULL FORM - MATCHED
DK	6	DWARF KOREAN LILAC	SYRINGA MEYERI 'PALABIN'	#5	CONT	FULL FORM - MATCHED
GL	32	GROW LOW SUMAC	RHUS AROMATICA 'GROW LOW'	#5	CONT	FULL FORM - MATCHED
TY	39	TAUNT ON YEW	TAXUS MEDIA 'TAUNTON'	#5	B&B	FULL FORM - MATCHED
AE	4	ARBORVITAE EMERALD	THUJA OCCIDENTALIS 'EMERALD'	5'	B&B	FULL FORM - MATCHED
AC	32	ALPINE CURRANT	ROSA X 'RAD RAZZ'	#5	CONT	FULL FORM - MATCHED
LD	8	LITTLE DEVIL NINEBARK	SPIRAEA BUMALDA 'ANTHONY WATERER'	#5	CONT	FULL FORM - MATCHED
PR	14	PRIVET	LIGUSTRUM X WICKARY 'NCLX1'	#5	CONT	FULL FORM - MATCHED

LATIN NAME	COMMON NAME	TOTAL PLUGS	TOTAL FLATS
ASTER NOVAE-ANGIAE	NEW ENGLAND ASTER	450	9
CAREX VULPINOIDEA	FOX SEDGE	450	9
EUPATORIUM MACULATUM	SPOTTED JOE-PYE WED	250	5
LIATRIS PNCYNOSTACHYA	GYAEFATHER	350	7
LOBELIA CARDINALIS	CARDINAL FLOWER	450	9
LYTHRUM ALBUM	WINGED LOOSTRIFE	350	7
MONARDA FILLOSA	WILD BERGAMOT	350	7
PANICUM VIRGATUM	SWITCHGRASS	300	6
PHLOX GLABERRIMA	MARSH PHLOX	450	9
MYCANOTHEMUM VIRGINIANUM	MOUNTAIN MINT	450	9
RUBROCKIA HYSTROBENTOSA	SWEET CORNFLOWER	450	9
ZIZIA AUREA	GOLDEN ALEXANDER	400	8



- * LANDSCAPE CONTRACTOR TO INSTALL BIORETENTION PLANTINGS PER WISCONSIN DNR STANDARDS. THIS INCLUDES ALL NECESSARY MULCHING AND/OR EROSION CONTROL MATTING.
- * DESIGN STANDARD CALLS FOR 50 PLUG NURSERY PLANTS FOR EACH PLANT SPECIES.
- * INSTALL BIORETENTION PLANTS AT 12" O.C. SPACING.
- * PLANTINGS SHALL BE EVENLY DISTRIBUTED THROUGHOUT THE 2 DESIGNATED AREAS
- * PLANT LARGER SPECIES (JOE-PYEE WOOD, SWITCHGRASS) IN GROUPS OF 3 TO 5 PLANTS EACH
- * PLANT SMALLER SPECIES IN GROUPS OF 5-9 PLANTS EACH
- * DO NOT PLANT WITHIN 18" OF PAVED SURFACE EDGE
- * INSTALL NON-FLOAT MULCH IN BIORETENTION AREAS

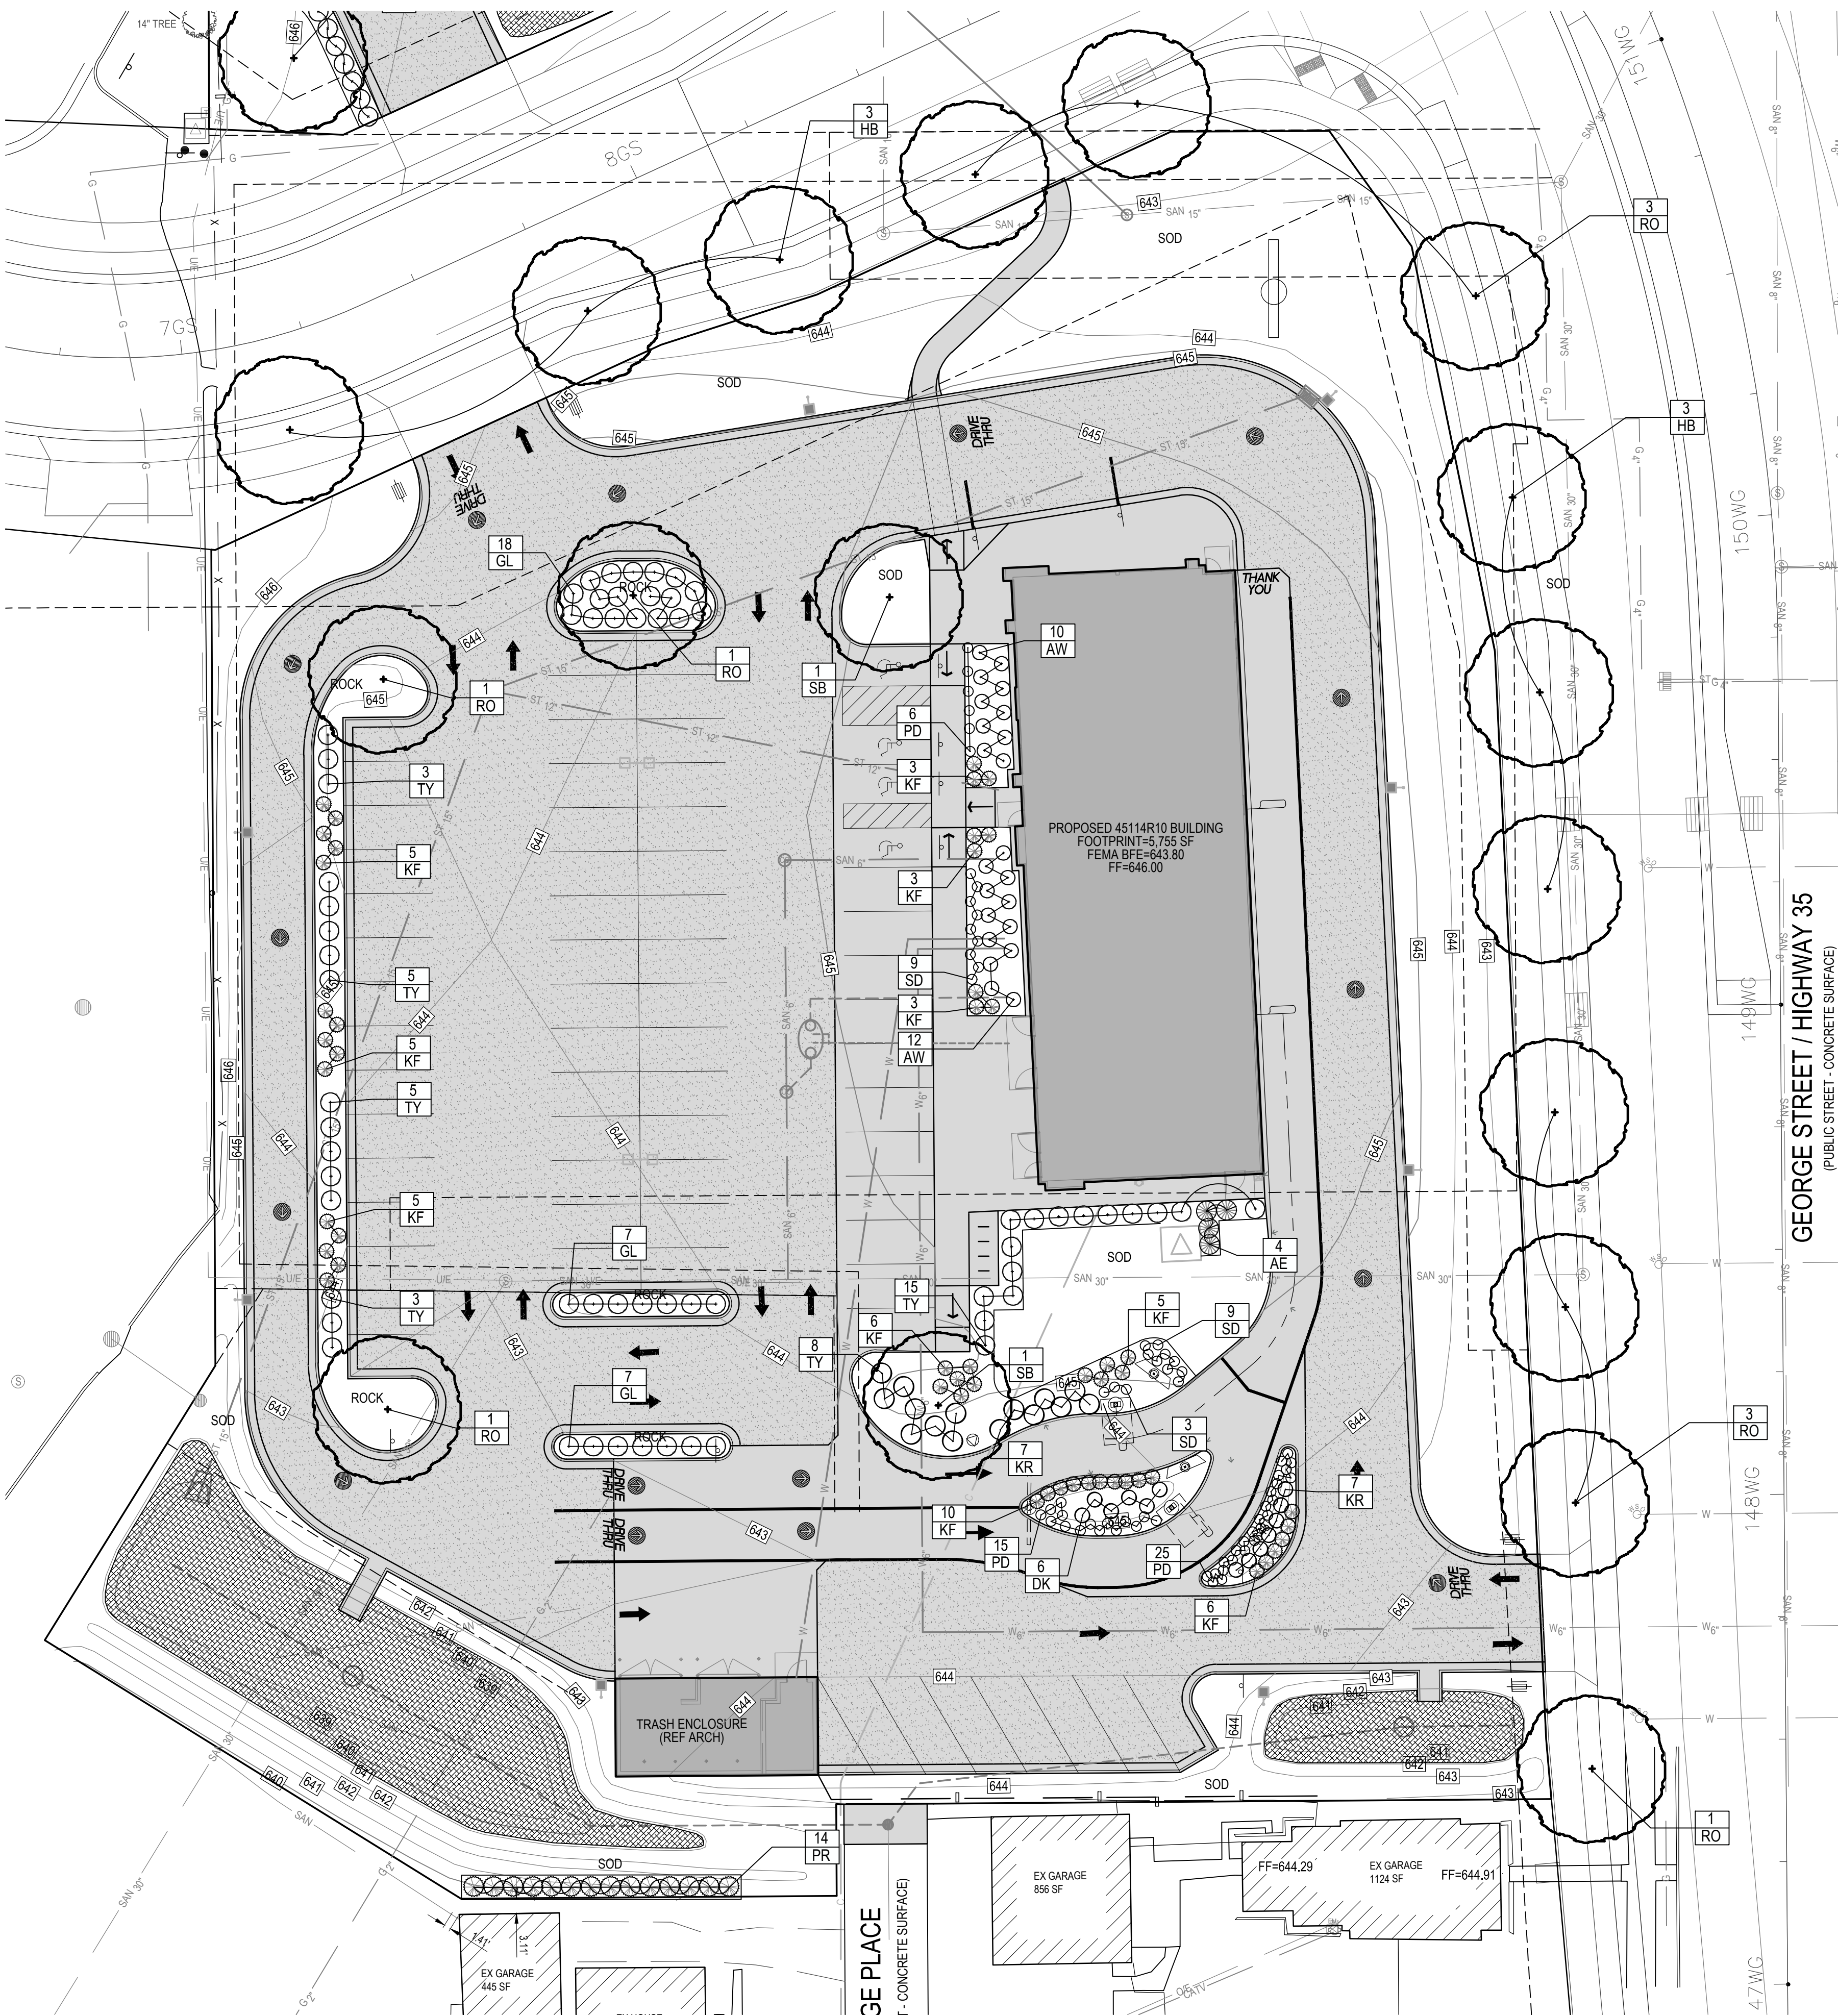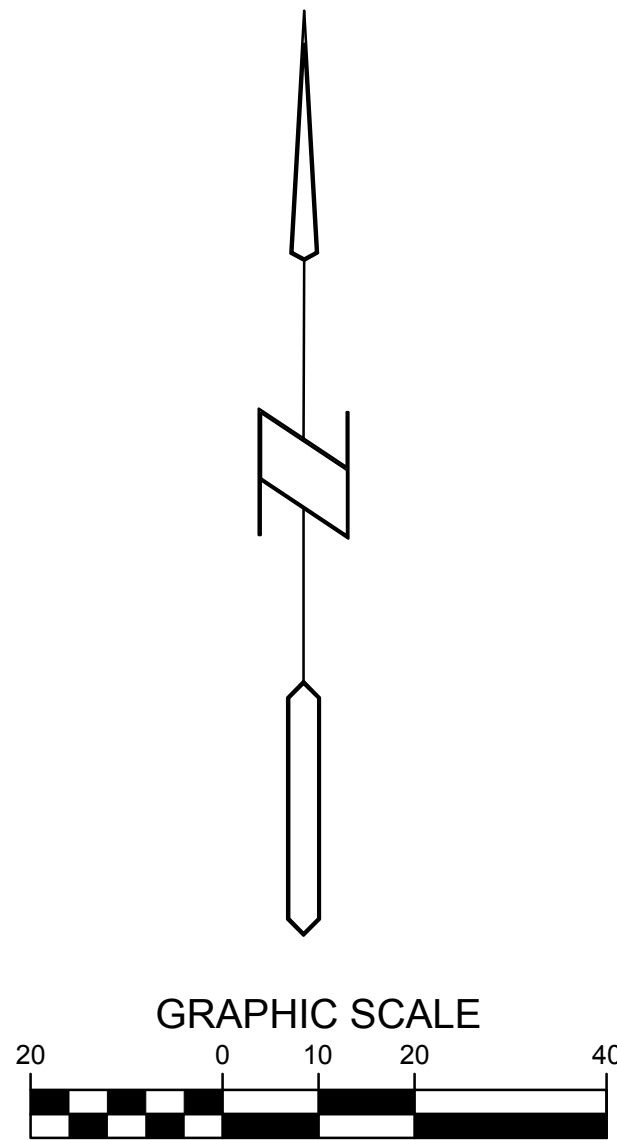

BIO-FILTER PLANTINGS (NORTH PARKING AREA ONLY)

LATIN NAME	COMMON NAME	TOTAL PLUG	TOTAL FLATS
ASTER NOVAE-ANGLAE	NEW ENGLAND ASTER	200	4
CAREX VULPINODIAE	FOX SEDGE	200	4
EUPATORIUM MACULATUM	SPOTTED JOE-PYE WED	100	2
LIATRIS PYCNOSTACHYA	GAYFEATHER	150	3
LOBELIA CARDINALIS	CARDINAL FLOWER	150	3
LYTHRUM ALATUM	WINGED LOOSTRIFE	150	3
MONARDA FISTULOSA	WILD BERGAMONT	150	3
PANICUM VIRGATUM	SWITCHGRASS	100	2
PHLOX GLABERRIMA	MARSH PHLOX	150	3
PYCNANTHEMUM VIRGINIANUM	MOUNTAIN MINT	150	3
RUDBECKIA SUBTOMENTOSA	SWEET CONEFLOWER	250	5
ZIZIA AUREA	GOLDEN ALEXANDER	150	3

- LANDSCAPE CONTRACTOR TO INSTALL BIORETENTION PLANTINGS PER WISCONSIN DNR STANDARDS. THIS INCLUDES ALL NECESSARY MULCHING AND/OR EROSION CONTROL MATTING.
- DESIGN STANDARD CALLS FOR 50 PLUG NURSERY FLATS FOR EACH PLANT SPECIES.
- INSTALL BIORETENTION PLANTS AT 12" O.C. SPACING.
- PLANT SPECIES ARE TO BE EVENLY DISTRIBUTED THROUGHOUT THE 2 DESIGNATED AREAS.
- PLANT LARGER SPECIES (JOE-PYE WED, SWITCHGRASS) IN GROUPS OF 3 TO 5 PLANTS EACH.
- PLANT SMALLER SPECIES (IN GROUPS OF 5-9 PLANTS EACH).
- DO NOT PLANT WITHIN 18" OF PAVED SURFACE EDGE.
- INSTALL NON-FLOAT MULCH IN BIORETENTION AREAS.

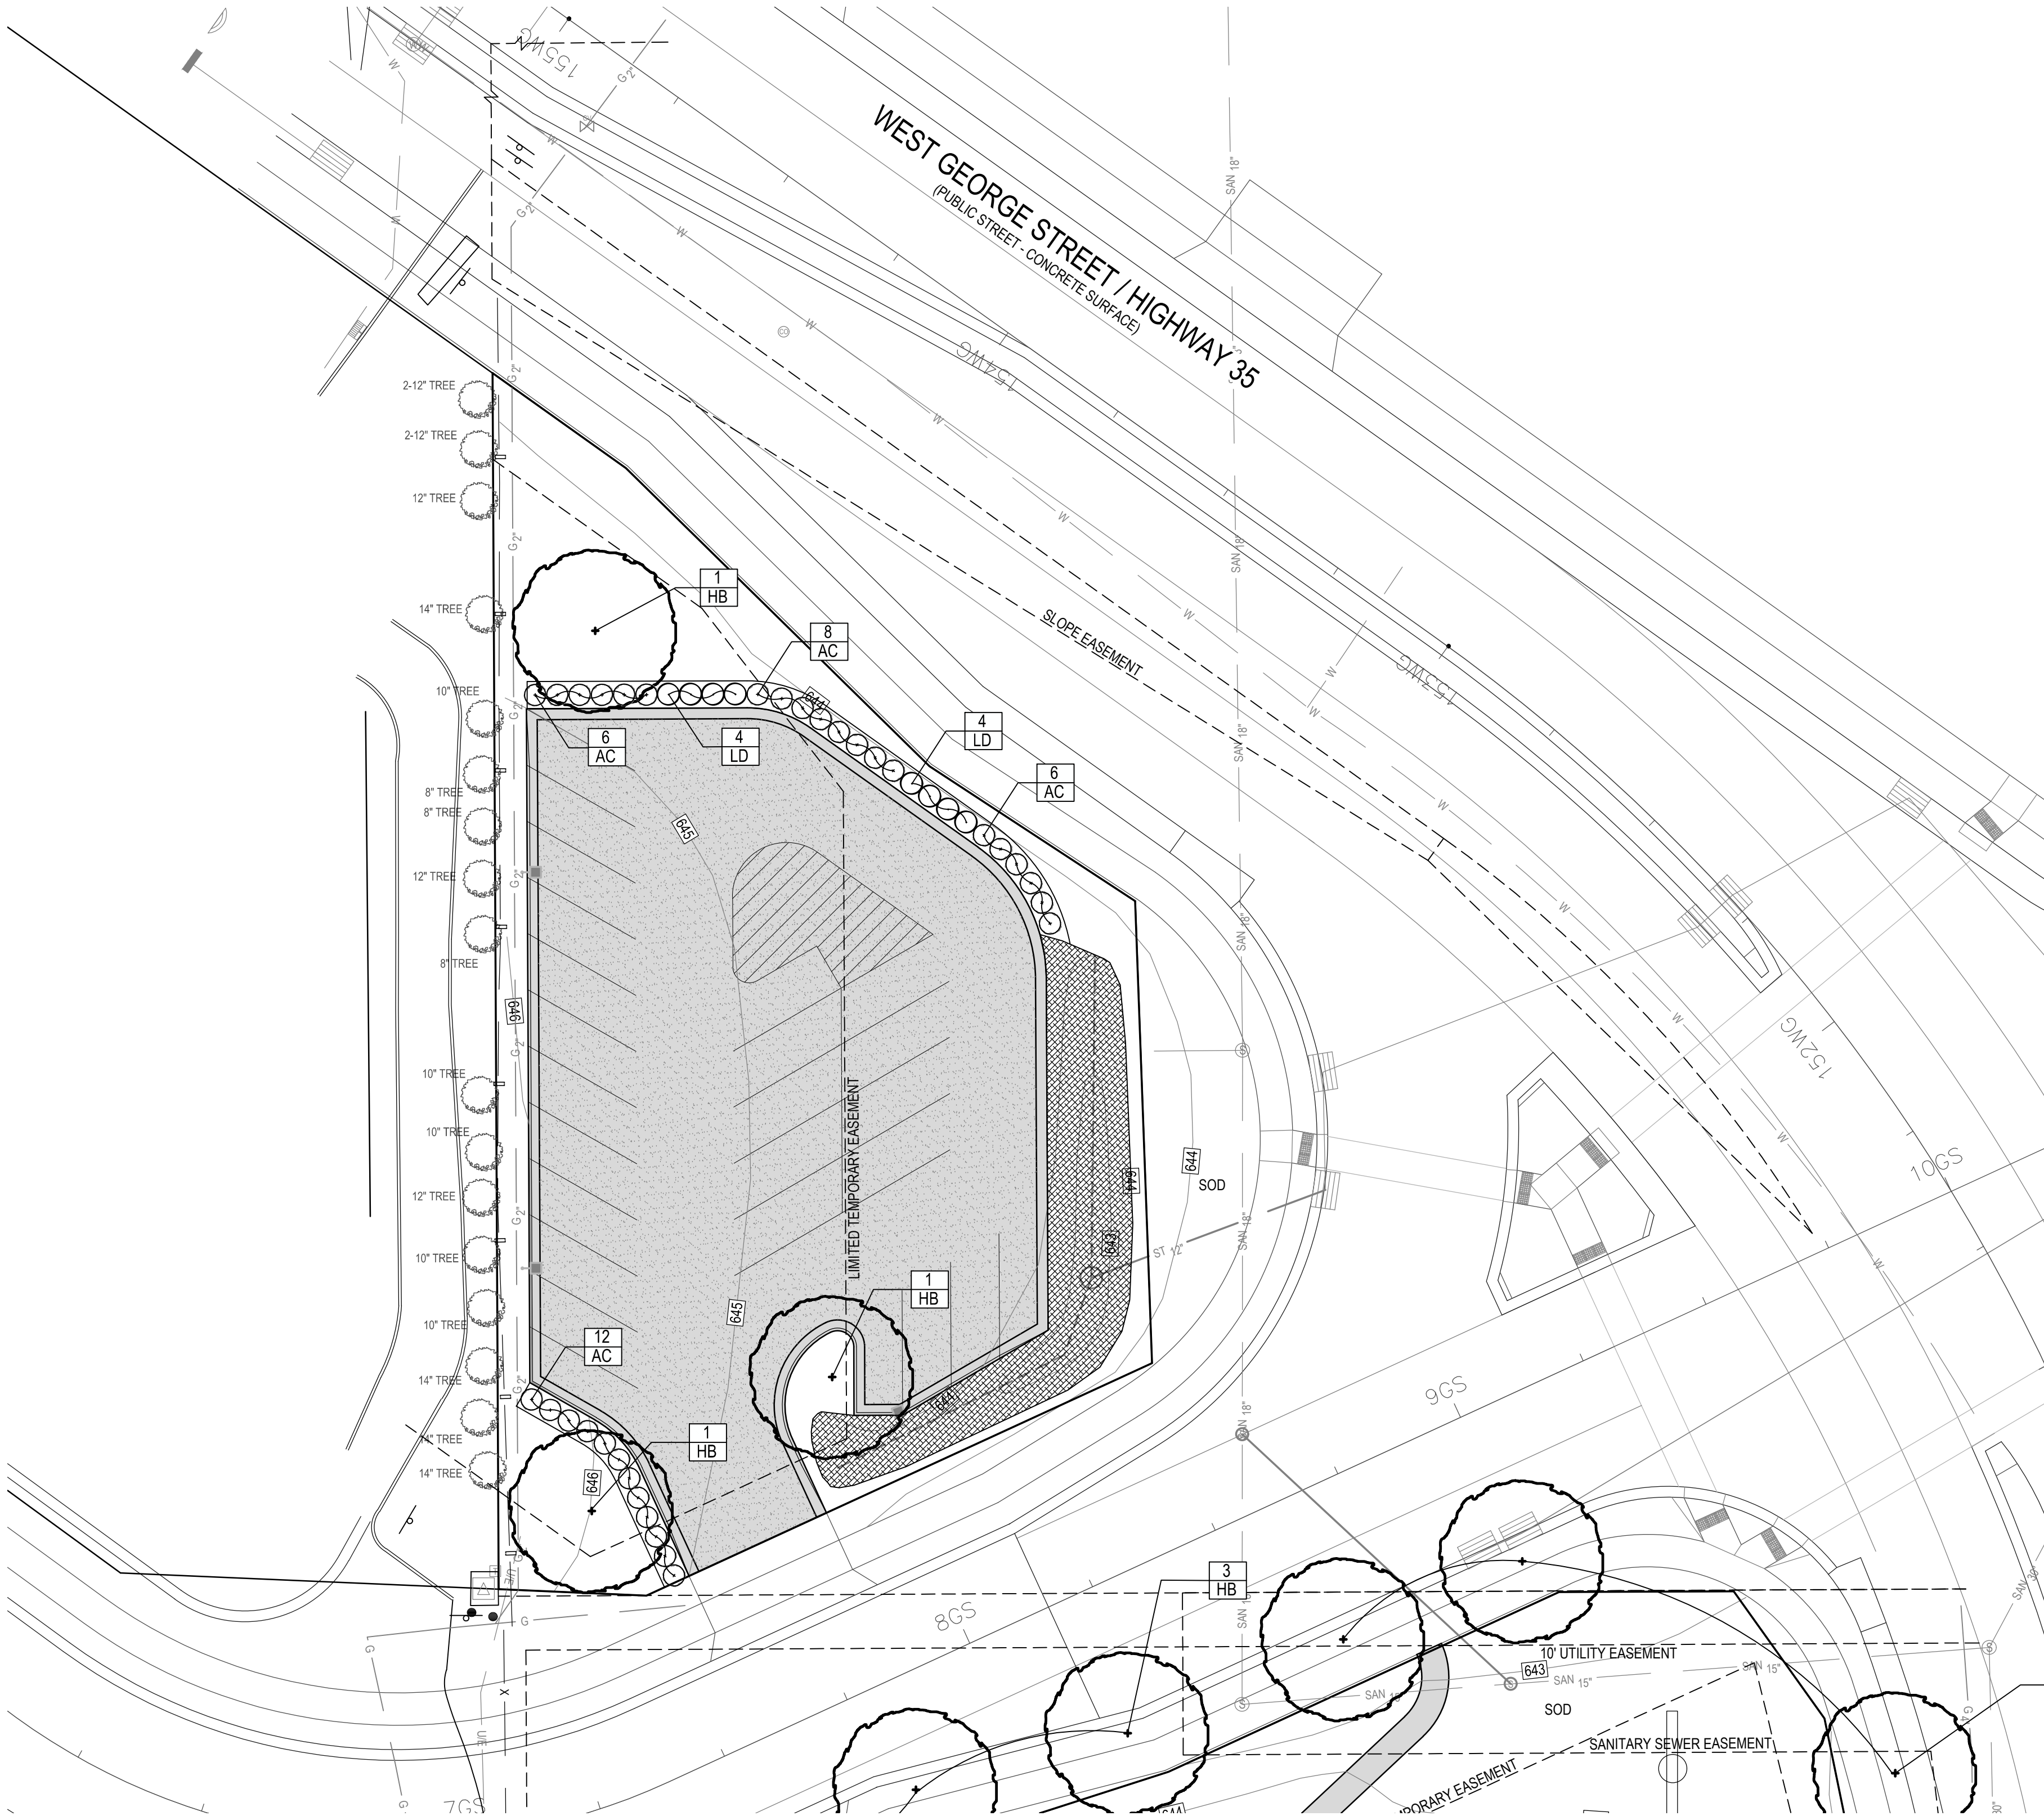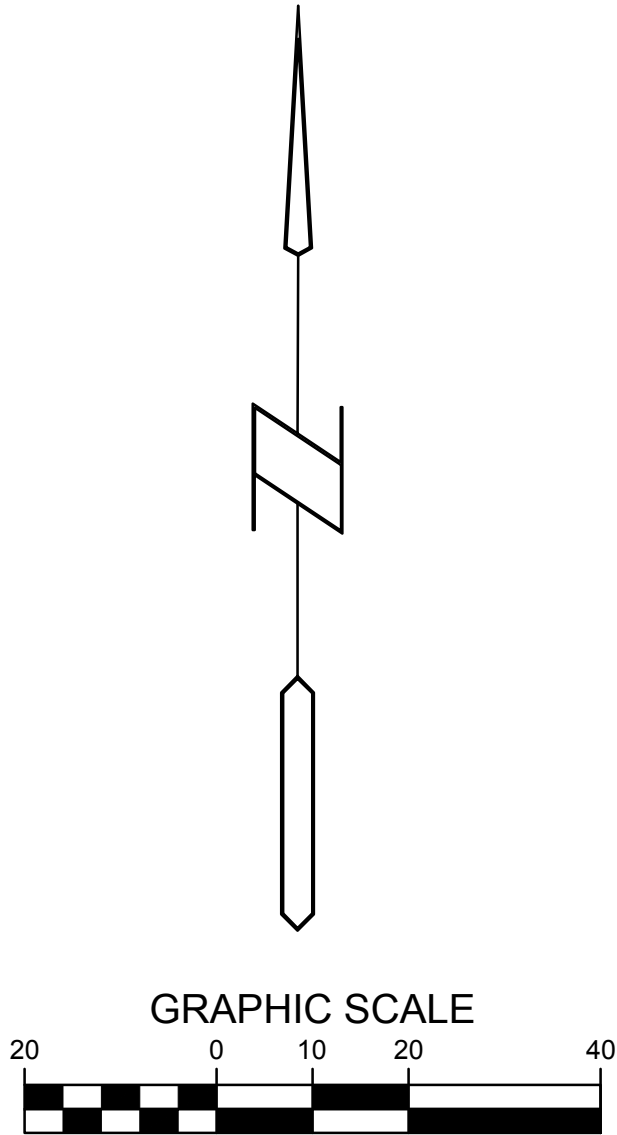

SHEET NO.	TITLE	DRAWN BY	DATE	REV	DATE	DESCRIPTION
C5.2	LA CROSSE, WI SITE PLAN LANDSCAPE PLAN	JMR	2/10/2017	JMJ	2/16/17	1ST CITY SUBMITAL
PREPARED FOR: M. McDonald's USA, LLC						
© 2017 McDonald's USA, LLC. These drawings and specifications are the confidential and proprietary property of McDonald's USA, LLC and shall not be copied or reproduced without written authorization. The contract documents were prepared for use on a different site or at a later time. Use of these drawings for reference or example on another project requires the approval of McDonald's USA, LLC. The contract documents for reuse on another project is not authorized.						
Bishop Engineering "Planning Your Successful Development" 3501 104th Street Des Moines, Iowa 50323-5825 Phone: 515-281-4444 Fax: 515-281-4447 Civil Engineering & Land Surveying Established 1999						


STORM WATER POLLUTION PREVENTION PLAN

PROPERTY DESCRIPTION:
SEE ALTA SURVEY

ADDRESS:
1140 W GEORGE ST
LA CROSSE, WI 54601






OWNER:
MCDONALD'S CORPORATION
PO BOX 182571
COLUMBUS, OH 43218

BENCHMARK:
NORTHING = 148321.42
EASTING = 448288.33
ELEVATION = 645.95
DESCRIPTION: NE QUAD GEORGE ST & CAMPBELL ST
HORIZONTAL AND VERTICAL BASIS FROM WISCONSIN
CORS NETWORK

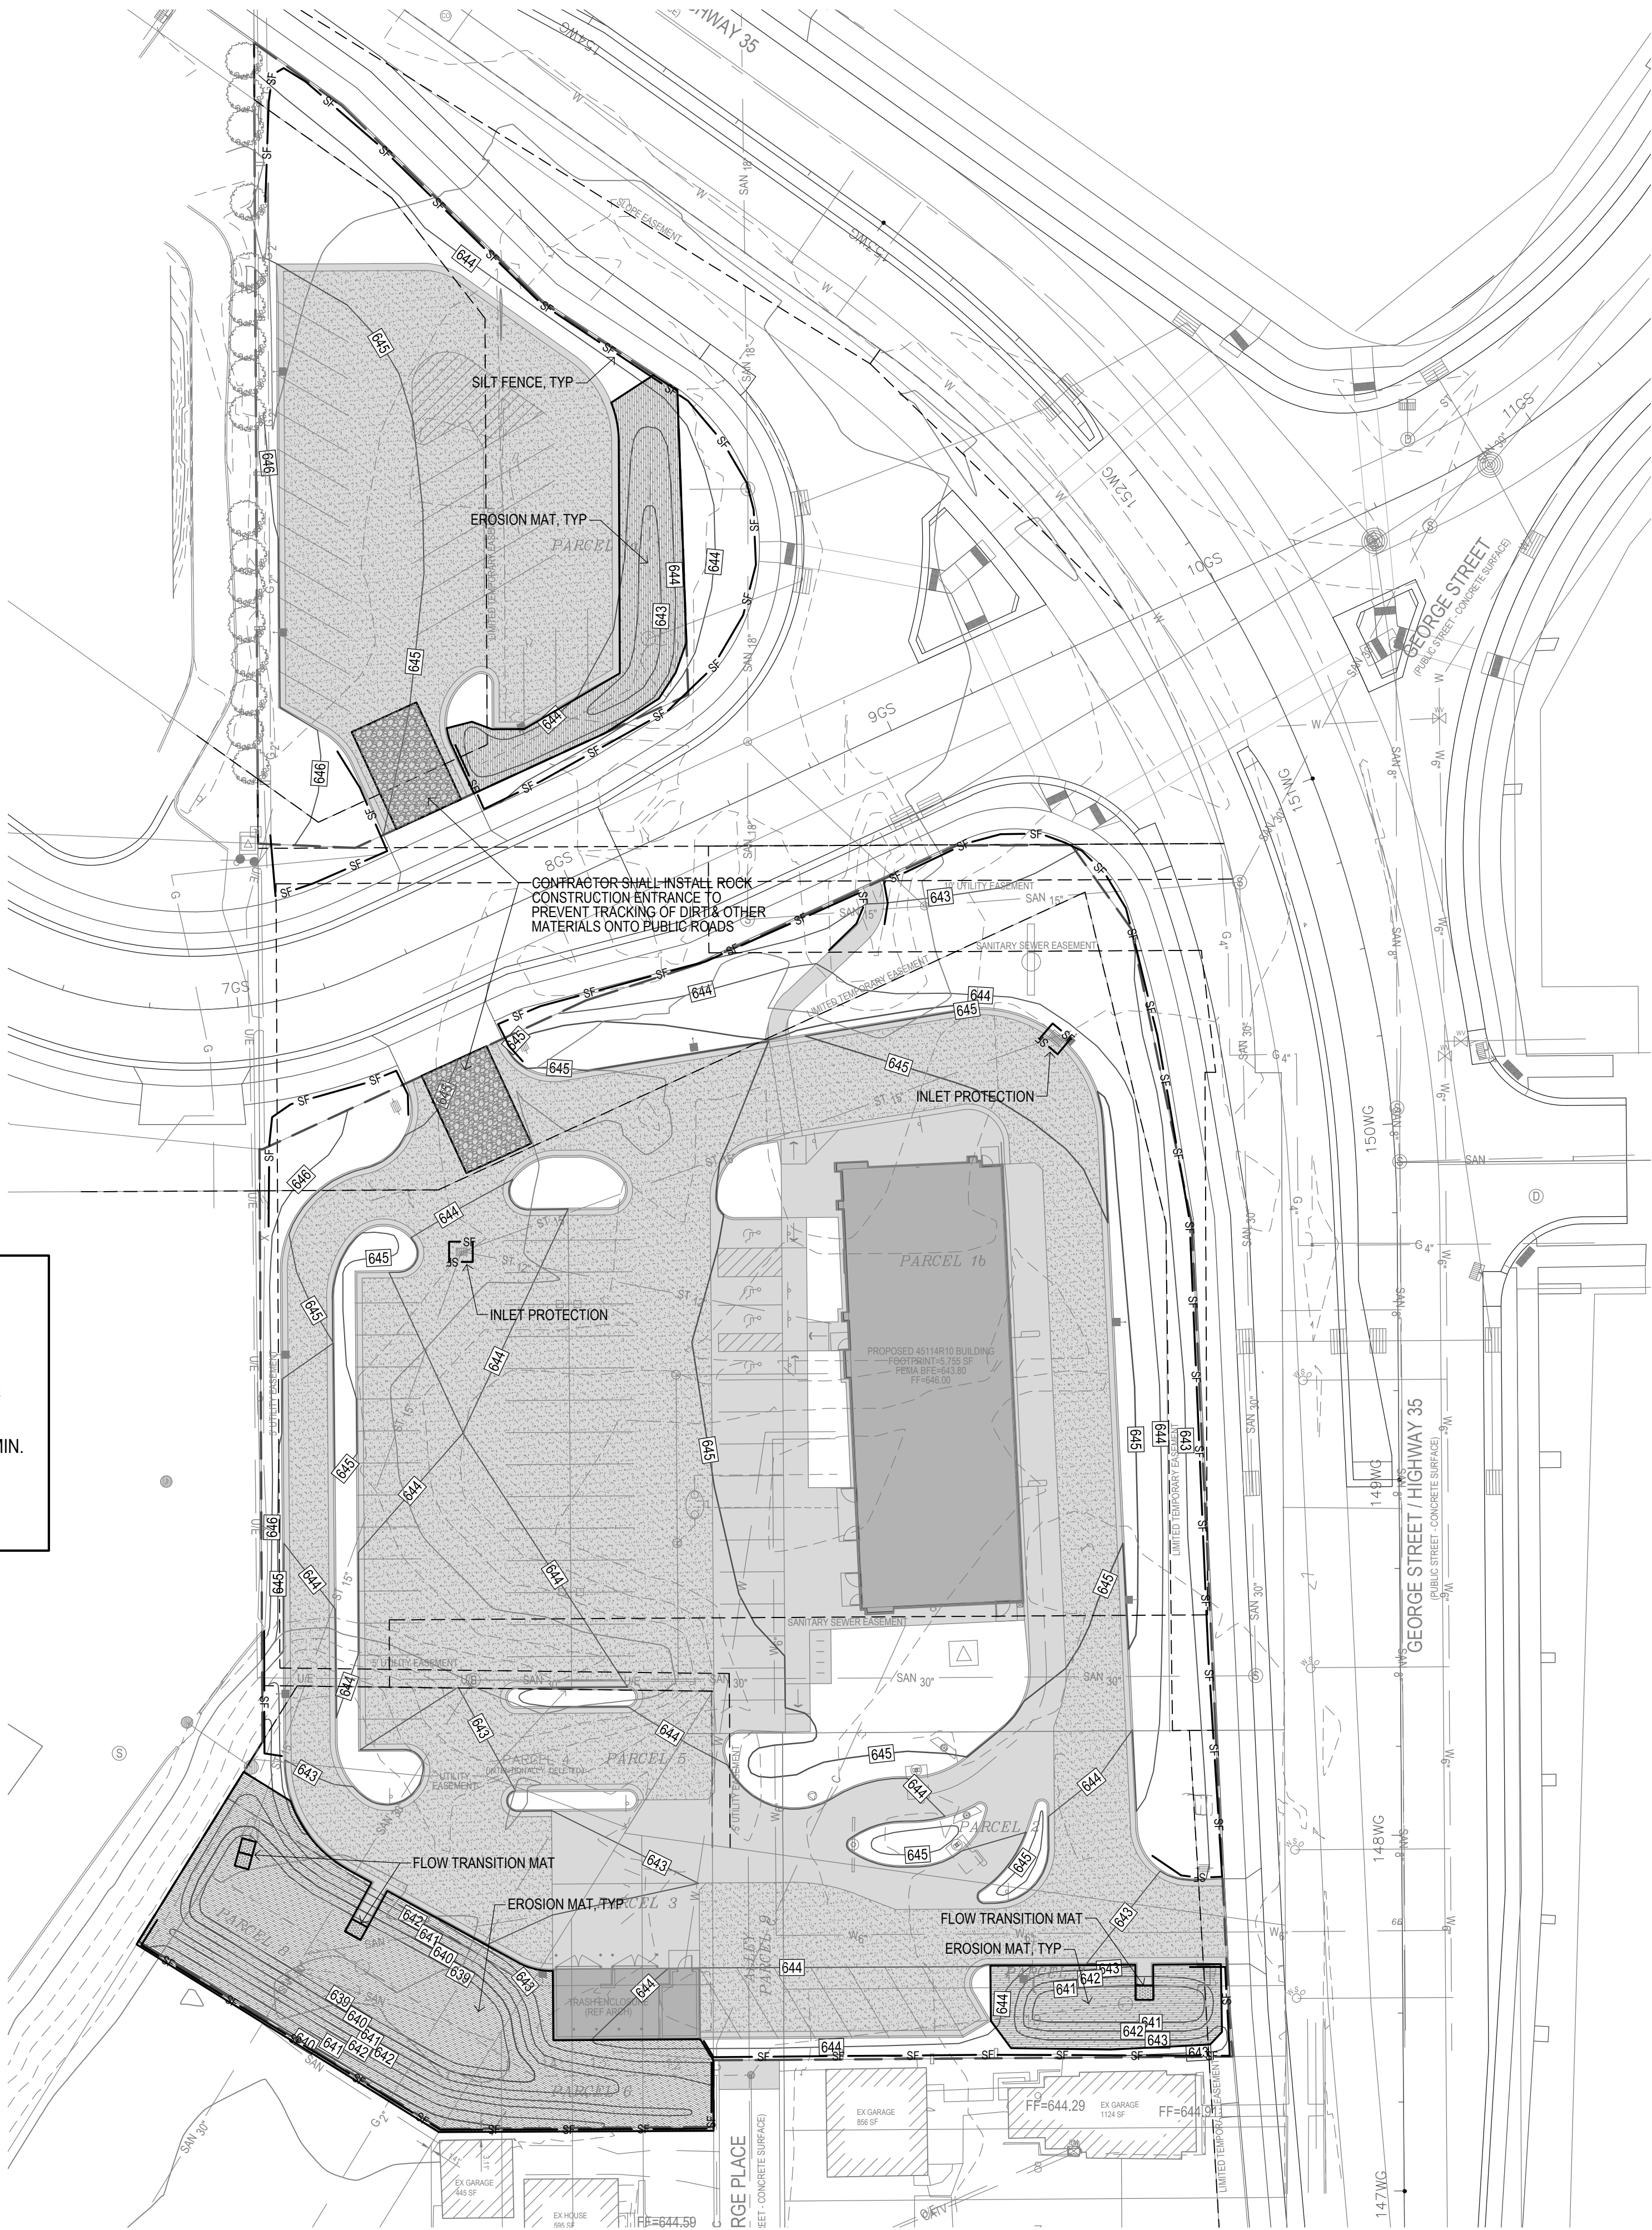

- EROSION CONTROL NOTES:**
- SEE SUPPLEMENTAL DETAIL STORM WATER POLLUTION PLAN NARRATIVE FOR ALL EROSION CONTROL MEASURES, ADDITIONAL DETAILS AND NOTE. ADDITIONAL NOTES AND MEASURES IN NARRATIVE SHALL BE CONSIDERED INCIDENTAL AND SHALL BE INCLUDED IN THE ORIGINAL BID.
 - SWPPP PLAN AND NARRATIVE ARE CONSIDERED A LIVING DOCUMENT AND WILL NEED PERIODIC UPDATES AND ADJUSTMENTS AS NECESSARY DEPENDING ON SITE CONDITIONS TO ASSURE COMPLIANCE WITH NPDES PERMIT NO. WI-S067831-4. IT IS THE CONTRACTOR'S RESPONSIBILITY TO UPDATE THE SWPPP AND IMPLEMENT ANY AND ALL MEASURES NECESSARY TO COMPLY WITH SAID PERMIT.
 - INSTALL PERIMETER SILT FENCE AS SHOWN ON PLANS PRIOR TO CONSTRUCTION.
 - INSTALL INTAKE PROTECTION WITH SILT FENCE IMMEDIATELY AFTER STORM SEWER CONSTRUCTION.
 - INSTALL FINISHED PAVING INLET PROTECTION IMMEDIATELY AFTER PAVING IS COMPLETED AROUND INTAKE.
 - OTHER EROSION CONTROL TYPES MAY NOT BE SUBSTITUTED FOR SILT FENCE.
 - CONTRACTOR SHALL BE RESPONSIBLE FOR PREVENTING THE TRACKING OF DIRT AND OTHER MATERIALS FROM THE PROJECT SITE ONTO ANY PUBLIC STREETS DURING CONSTRUCTION. CONTRACTOR SHALL CLEAN ANY DIRT OR OTHER MATERIALS TRACKED ONTO PUBLIC STREETS AT THE END OF EACH DAY.
 - CONTRACTOR SHALL BE RESPONSIBLE FOR SUPPLYING A CONCRETE WASHOUT.
 - CONTRACTOR SHALL BE RESPONSIBLE FOR SUPPLYING TEMPORARY RESTROOM FACILITIES. SANITARY WASTE SHALL BE DISPOSED OF PER ALL FEDERAL, STATE AND LOCAL REGULATIONS.
 - CONTRACTOR SHALL BE RESPONSIBLE FOR ENSURING ALL TOPSOIL REQUIREMENTS ARE MET.
 - LIMIT SOIL DISTURBANCE TO THE GRADING LIMITS SHOWN. SCHEDULE OPERATIONS TO MINIMIZE LENGTH OF EXPOSURE OF DISTURBED AREAS.
 - MANAGEMENT PRACTICES SHOWN ARE THE MINIMUM REQUIREMENTS. INSTALL AND MAINTAIN ADDITIONAL CONTROLS AS WORK PROCEEDS TO PREVENT EROSION AND CONTROL SEDIMENT CARRIED BY WIND OR WATER.
 - RESTORE DISTURBED OPEN AREA WITH TEMPORARY SEED OR SOD WITHIN 72 HOURS OF COMPLETING GRADING IN EACH AREA.
 - SCRAP ADJACENT STREETS CLEAN DAILY AND SWEEP CLEAN WEEKLY.
 - BUILDING AND WASTE MATERIAL SHALL BE PROPERLY HANDLED TO PREVENT RUNOFF OF MATERIAL PER DNR REGULATIONS.
 - WASH WATER FROM VEHICLE AND WHEEL WASHING SHALL BE TREATED PRIOR TO RUNOFF PER DNR REQUIREMENTS.
 - CONTRACTOR SHALL DEVELOP SPILL PREVENTION AND RESPONSE PROCEDURES IN ACCORDANCE WITH DNR REQUIREMENTS.
 - INSPECTIONS MUST BE PERFORMED WEEKLY AND WITHIN 24 HOURS AFTER A RAIN EVENT OF 0.5 INCHES OR GREATER. WEEKLY REPORTS OF ALL INSPECTIONS MUST BE MAINTAINED THROUGHOUT THE PERIOD OF GENERAL PERMIT COVERAGE.

- EROSION CONTROL REMOVAL NOTES:**
- AFTER FINAL STABILIZATION HAS OCCURRED, AS DEFINED IN NPDES GENERAL PERMIT NO. 2, CONTRACTOR SHALL BE RESPONSIBLE FOR THE REMOVAL OF ALL TEMPORARY EROSION CONTROL DEVICES INCLUDING, BUT NOT LIMITED TO: SILT FENCE, INLET PROTECTION, AND TEMPORARY STANDPIPES.

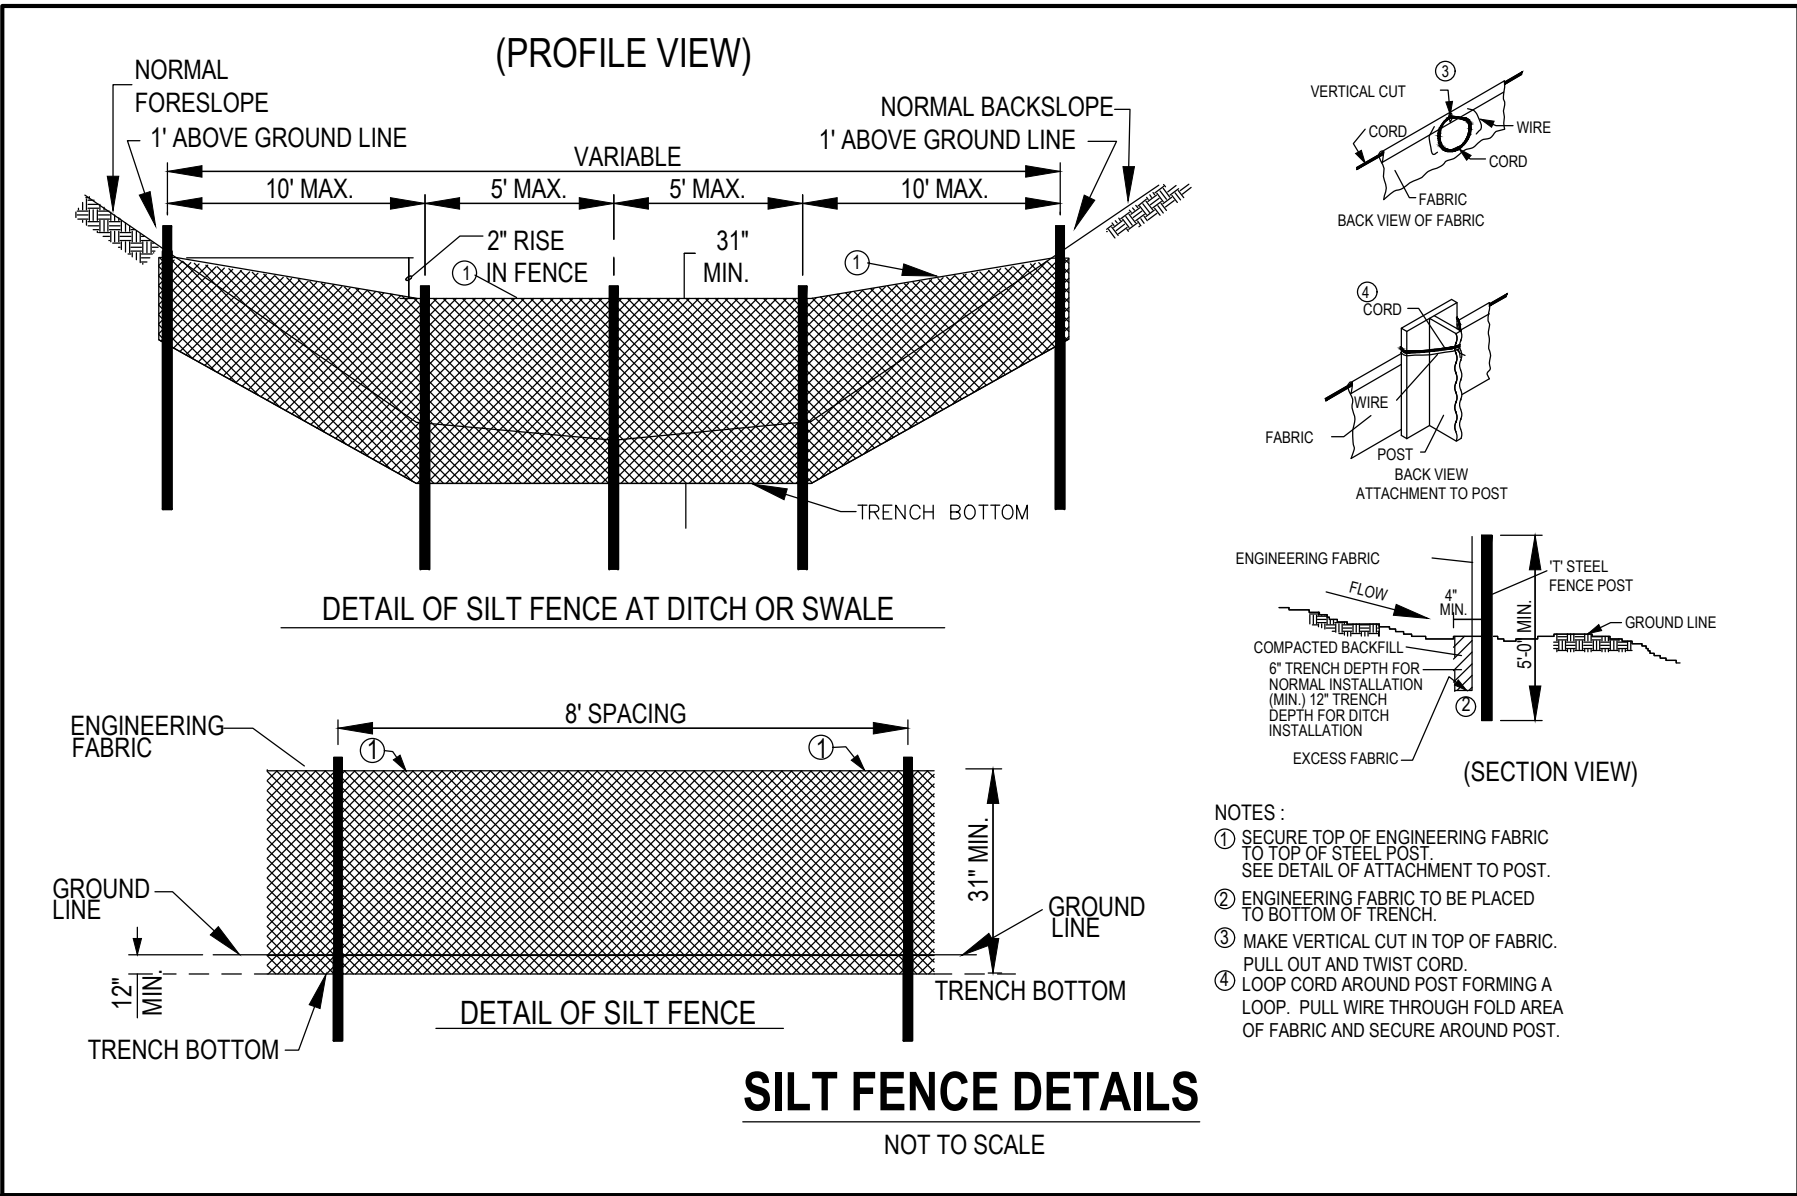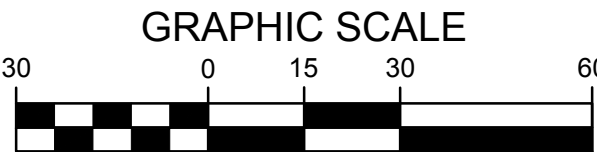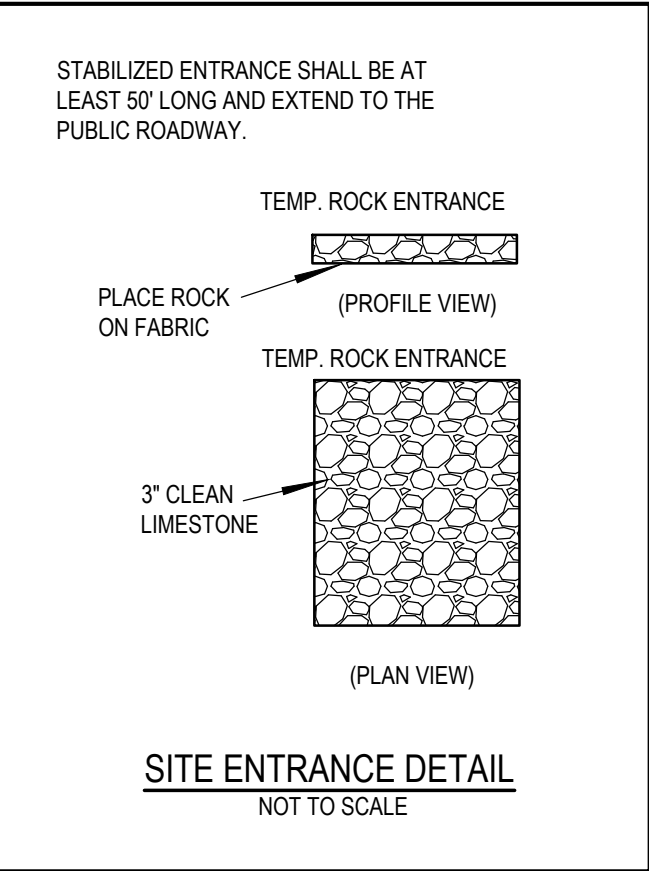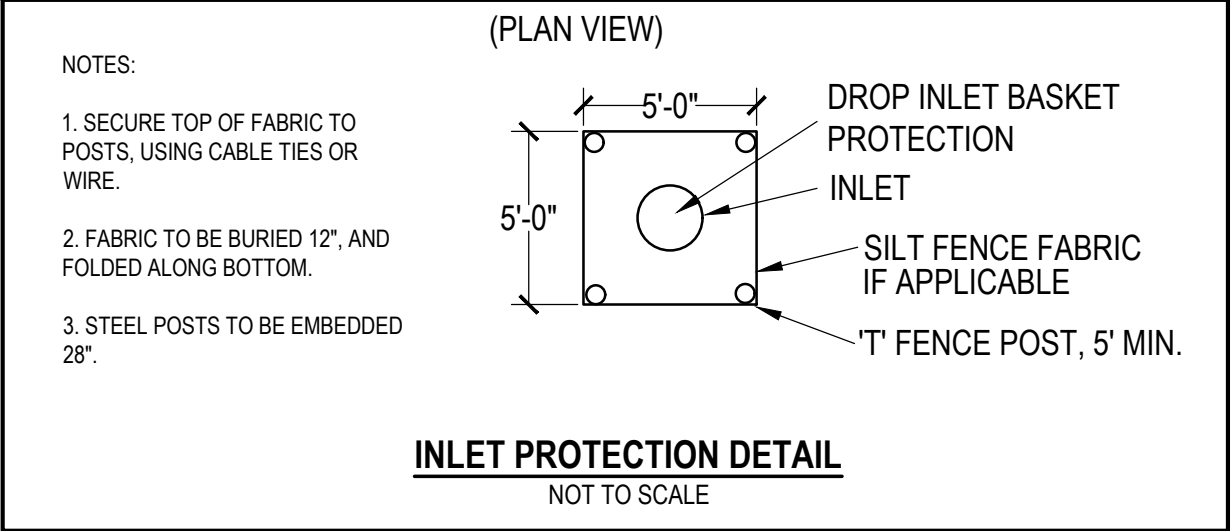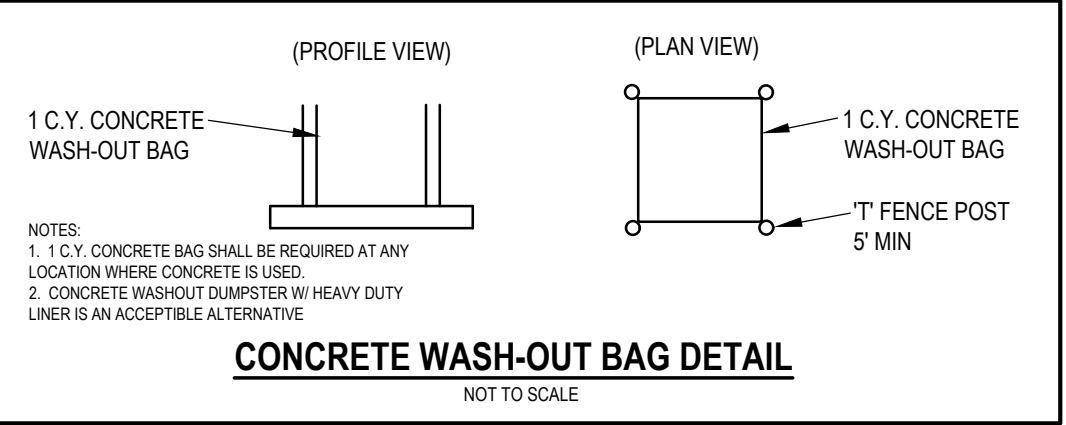

2/16/2017 4:56:26 PM M:\LAND PROJECTS 2012\120207 LA CROSSE, WI - GEORGE ST\DWG17 SWPPP.DWG

SHEET NO.		TITLE		DRAWN BY		PREPARED FOR:		PREPARED BY:		DATE		REV		DESCRIPTION	
C7.1		LA CROSSE, WI SITE PLAN		JMR		M. McDonald's USA, LLC		Bishop Engineering "Planning Your Successful Development"		3500 104th Street Dodgeville, WI 53533 Phone: (608)276-4087 Fax: (608)276-0207		1		1ST CITY SUBMITTAL	
BE # 120207		SWPPP		JEJ		These drawings and specifications are the confidential and proprietary property of McDonald's USA, LLC and shall not be copied or reproduced without written authorization. The contract documents were prepared under a license from McDonald's USA, LLC and the drawings are not suitable for use on a different site or at a later time. Use of these drawings on another project without the express written consent of the architect and engineer is prohibited. The contract documents for reuse on another project is not authorized.		Civil Engineering & Land Surveying Established 1959							
480054		1140 W GEORGE ST, LA CROSSE, WI 54601		2/10/2017		2/10/2017									