


Luminaire Schedule				
QTY	TYPE	MFR	PART NUMBER	LLF
1	P4SH	McGraw-Edison	GLEON-AF-06-LED-E1-SL4-xx-HSS (30' POLE + FLUSH BASE)	0.900
1	W3	McGraw-Edison	GWC-AF-01-LED-E1-SL3-xx-600	0.900

Calculation Summary					
AREA	AVG	MAX	MIN	AVG/MIN	MAX/MIN
25' Beyond Property Line	0.01	0.04	0.00	N.A.	N.A.
Parking Lot	1.99	4.6	0.4	4.98	11.50

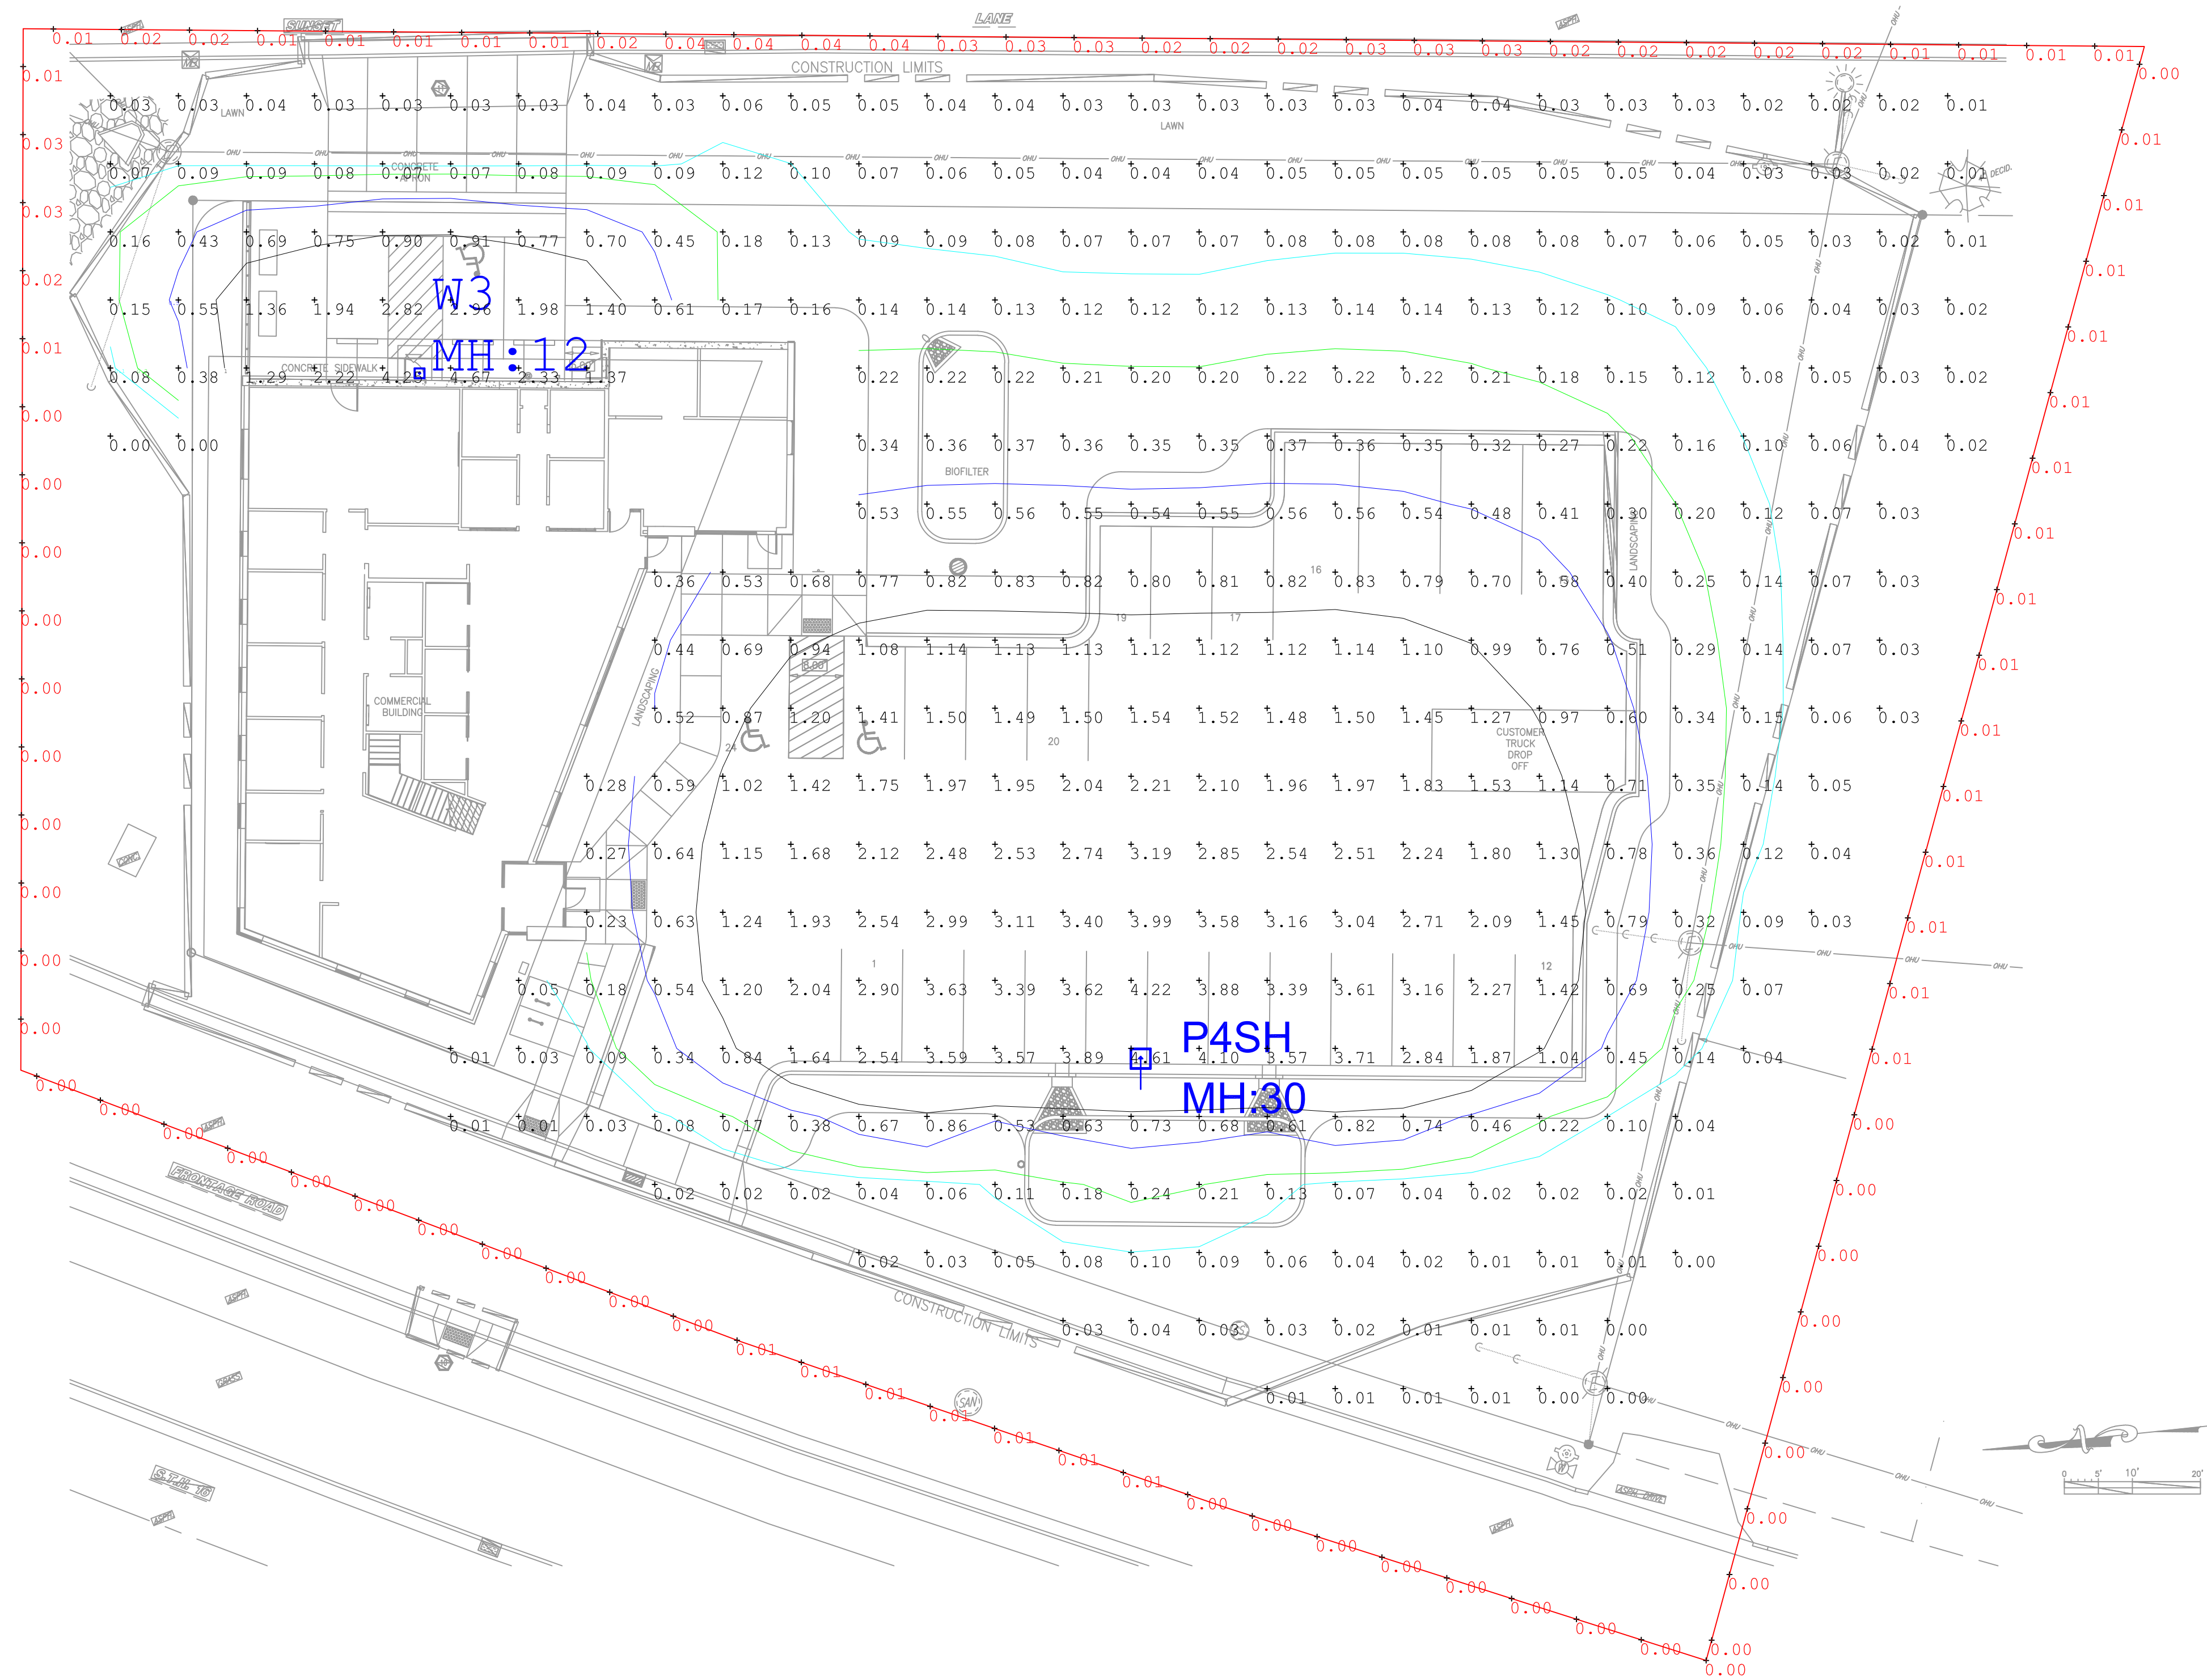

REVISIONS		
#	DATE	COMMENTS

DRAWN BY: JS	DATE: 4 / 4 / 2019	SCALE: 1" = 16'-0"

CASTLE REALTY	LA CROSSE, WI	LED SITE LIGHTING PLAN