




1 OVERALL ARENA FLOOR TECHNOLOGY PLAN
1/16" = 1'-0"

SHEET NOTES	
1. x	
2. x	

TECHNOLOGY KEYNOTE LEGEND	
KEY	KEYNOTE TEXT

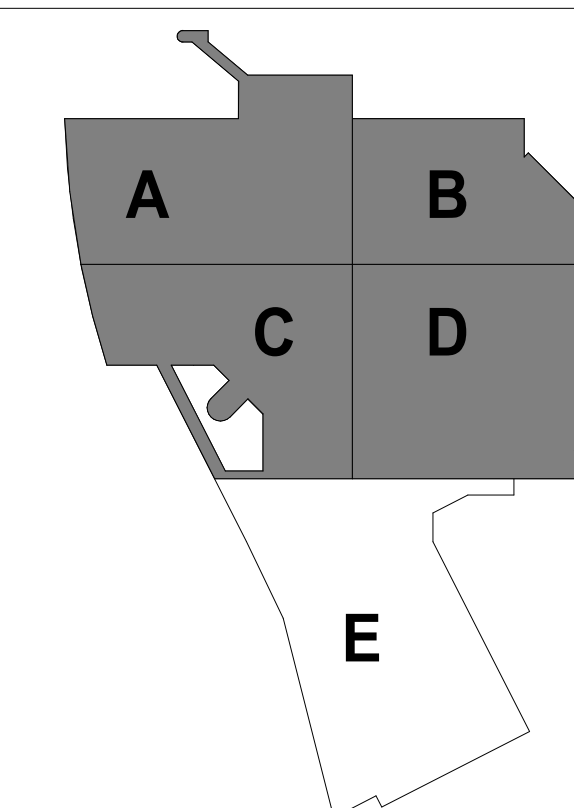

KEYPLAN

THIS DOCUMENT IS THE PROPERTY OF I & S GROUP, INC. AND MAY NOT BE USED, COPIED OR DUPLICATED WITHOUT PRIOR WRITTEN CONSENT.

PROJECT

LA CROSSE CENTER EXPANSION

LA CROSSE WISCONSIN

[illegible]

PROJECT NO.	16-19990
FILE NAME	19990 Tech R18.rvt
DRAWN BY	KCS
DESIGNED BY	ER
REVIEWED BY	MDN
ORIGINAL ISSUE DATE	MM/DD/YYYY
CLIENT PROJECT NO.	

 
CLIENT PROJECT NO.

OVERALL ARENA FLOOR TECHNOLOGY


SHEET

3T2-11

PRELIMINARY NOT FOR CONSTRUCTION




8/30/2019 10:50:23 AM

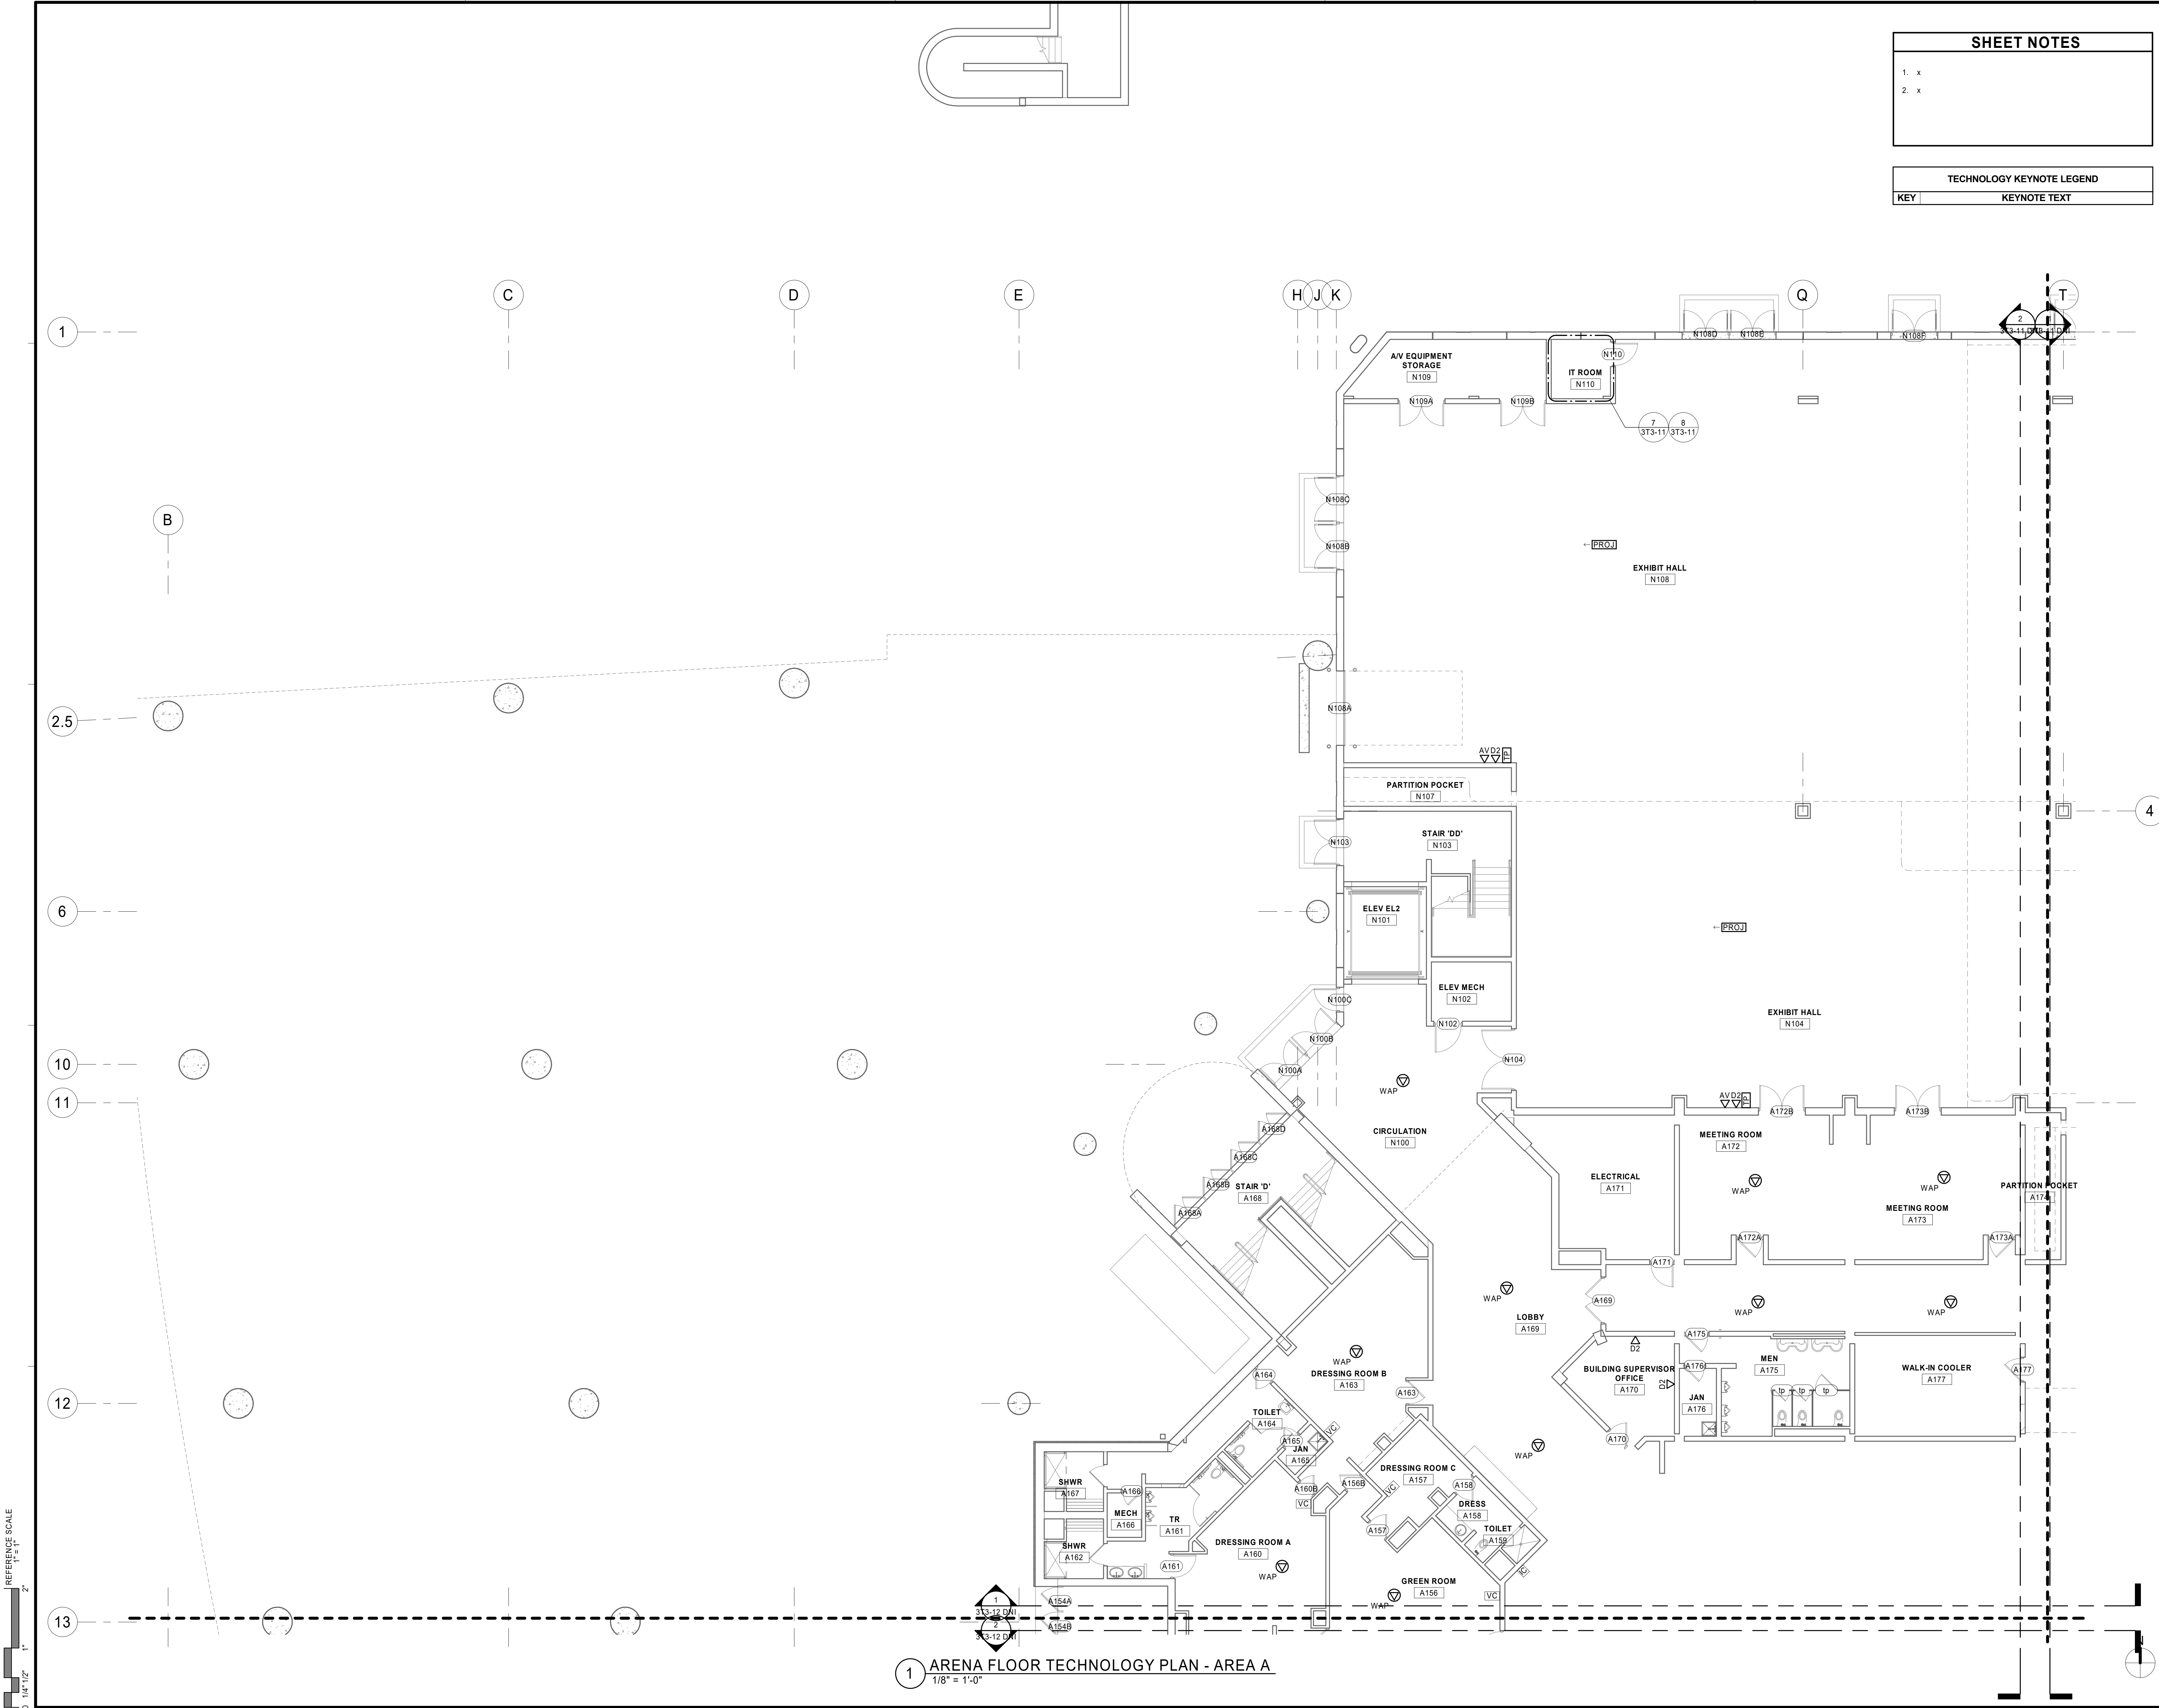

SHEET NOTES	
1. x	
2. x	

TECHNOLOGY KEYNOTE LEGEND	
KEY	KEYNOTE TEXT

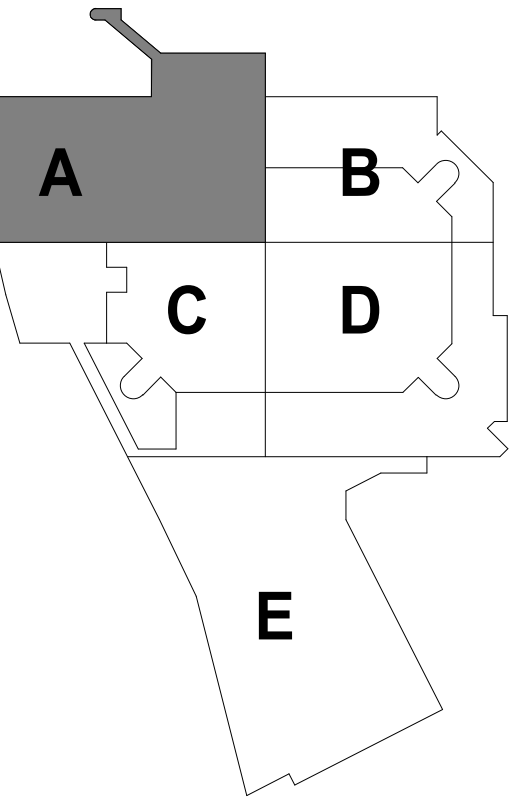

KEYPLAN

THIS DOCUMENT IS THE PROPERTY OF I & S GROUP, INC. AND MAY NOT BE USED, COPIED OR DUPLICATED WITHOUT PRIOR WRITTEN CONSENT.

PROJECT

LA CROSSE CENTER EXPANSION

LA CROSSE WISCONSIN

REVISION SCHEDULE		
DATE	DESCRIPTION	BY

PROJECT NO. 16-19990
FILE NAME 19990 Tech R18.rvt
DRAWN BY KCS
DESIGNED BY ER
REVIEWED BY MDN
ORIGINAL ISSUE DATE MM/DD/YYYY
CLIENT PROJECT NO.

TITLE

ARENA FLOOR TECHNOLOGY - AREA A

SHEET


3T2-11A

1 ARENA FLOOR TECHNOLOGY PLAN - AREA A
1/8" = 1'-0"

REFERENCE SCALE
0 1/4" 1/2" 1" 2"

8/26/2019 10:50:27 AM

PRELIMINARY NOT FOR CONSTRUCTION

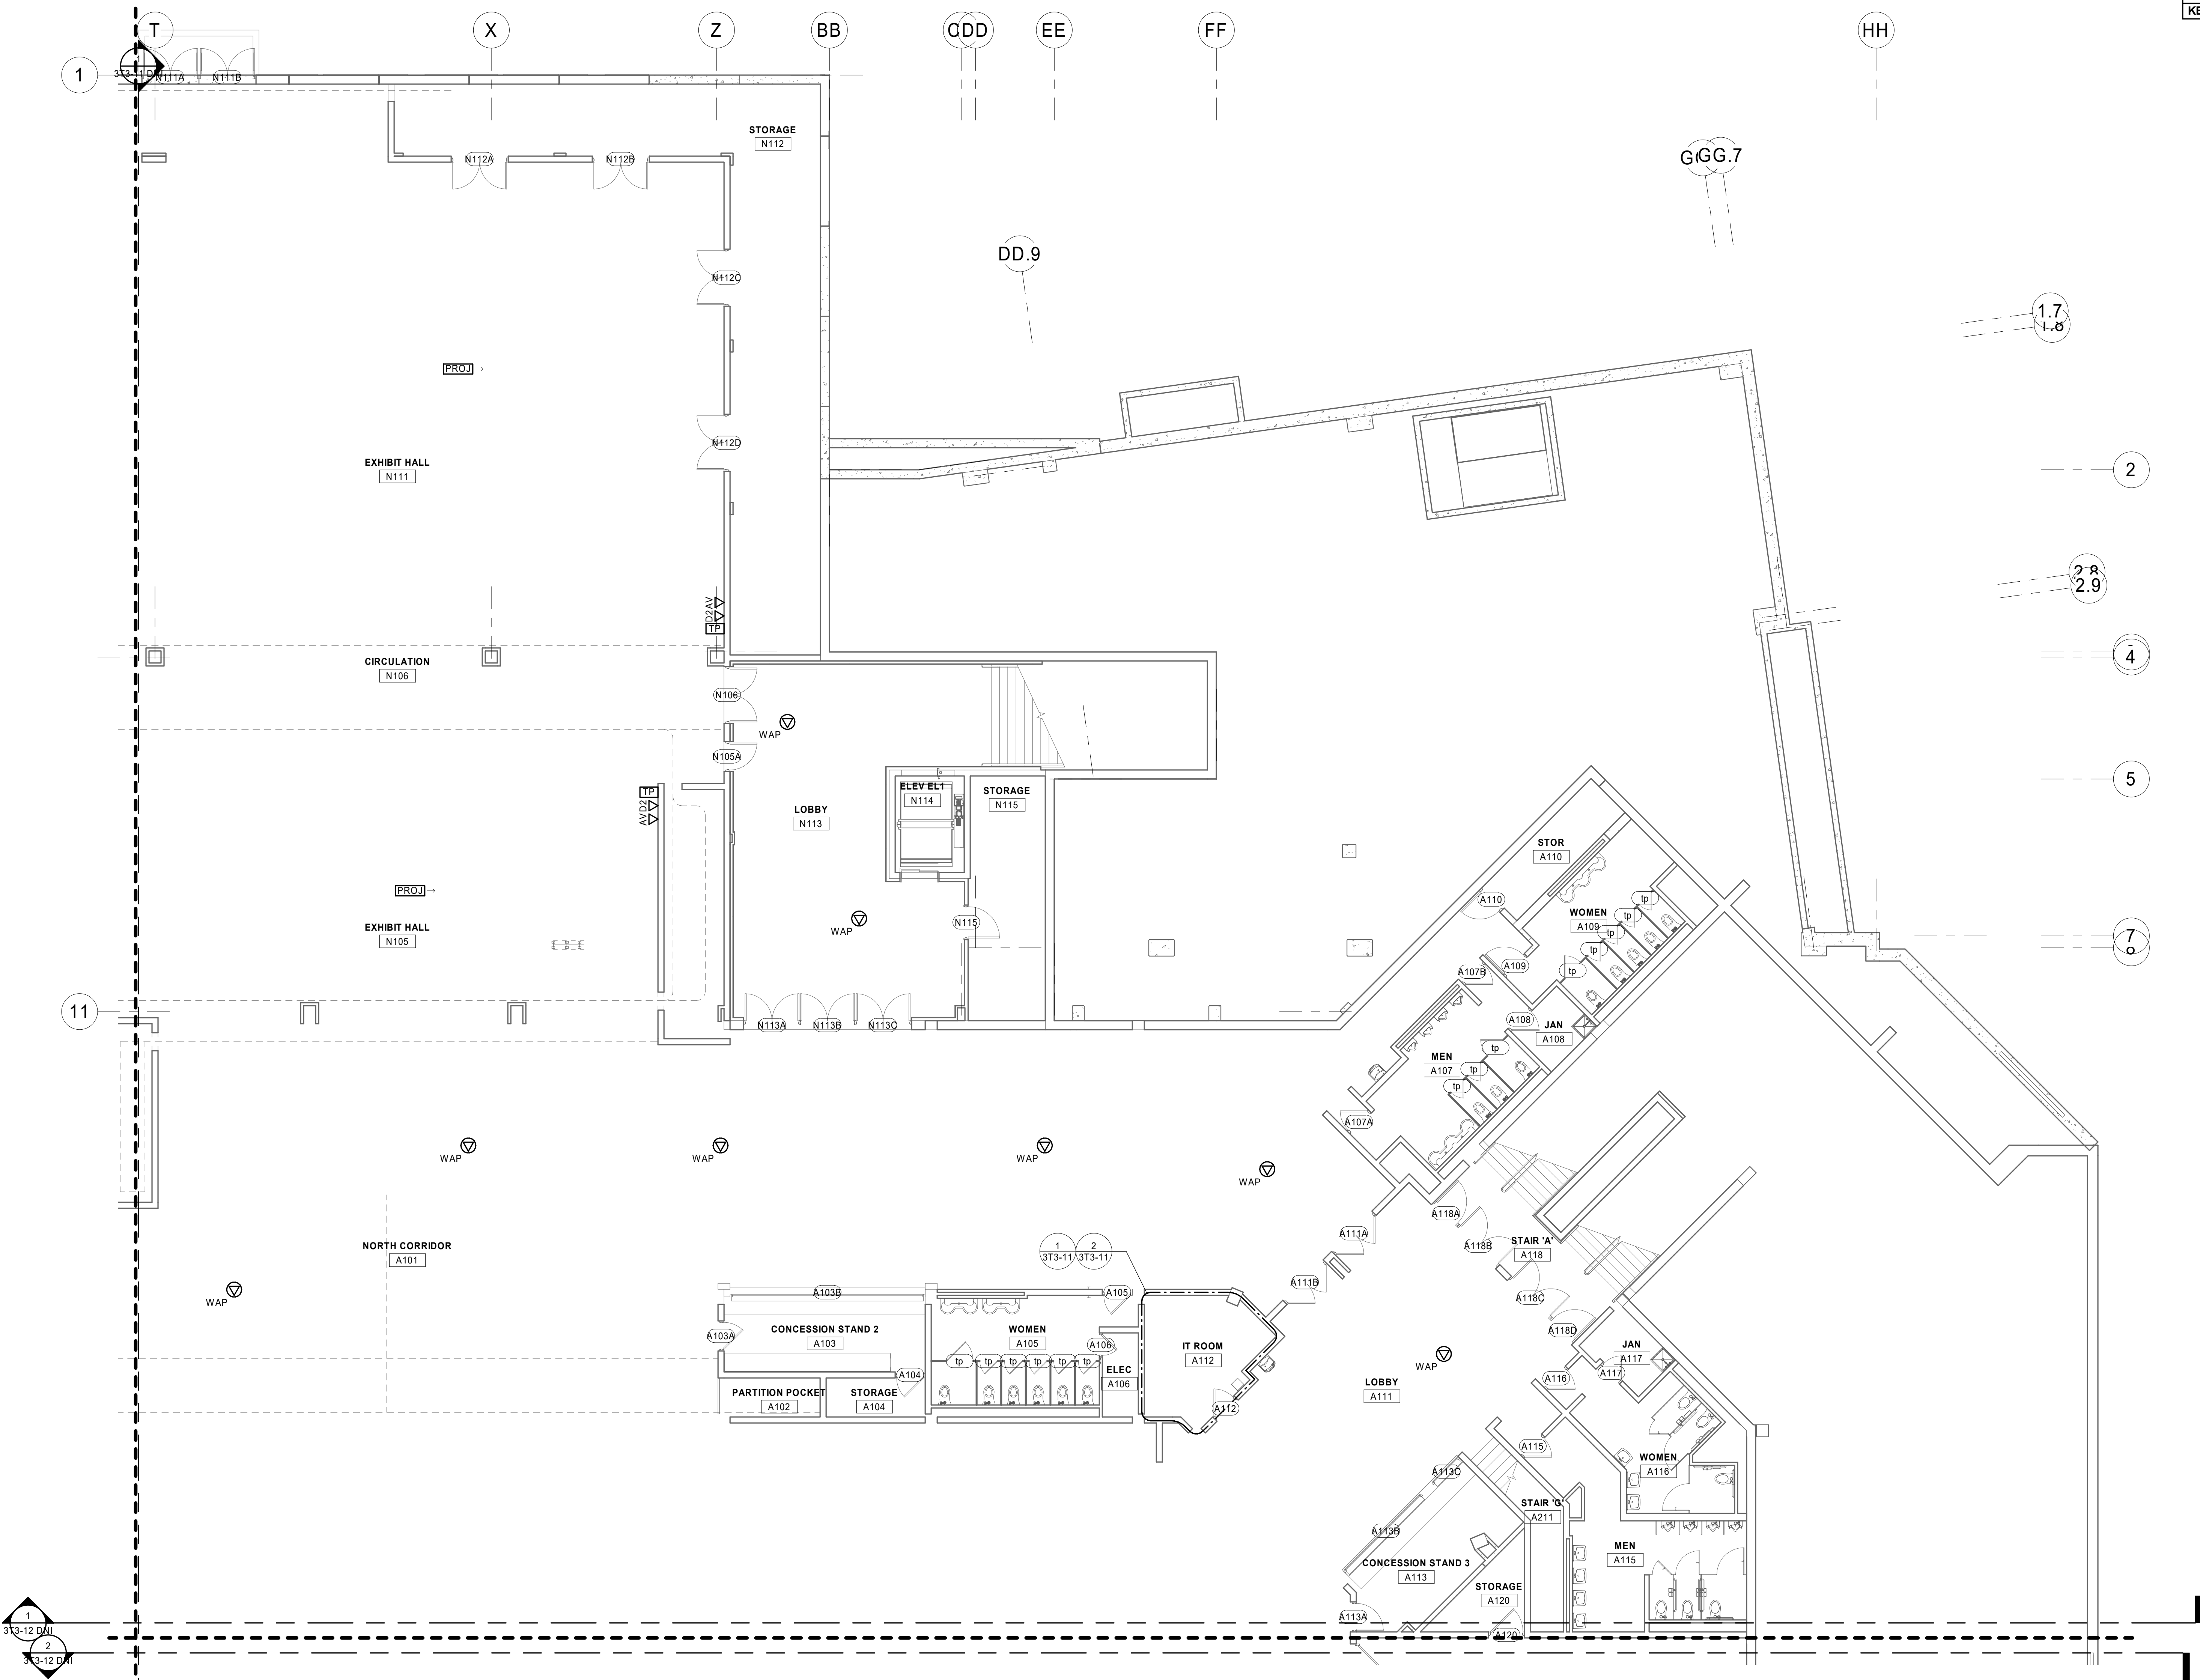

1 ARENA FLOOR TECHNOLOGY PLAN - AREA B
1/8" = 1'-0"


SHEET NOTES

- x
- x

TECHNOLOGY KEYNOTE LEGEND

KEY KEYNOTE TEXT

ISG

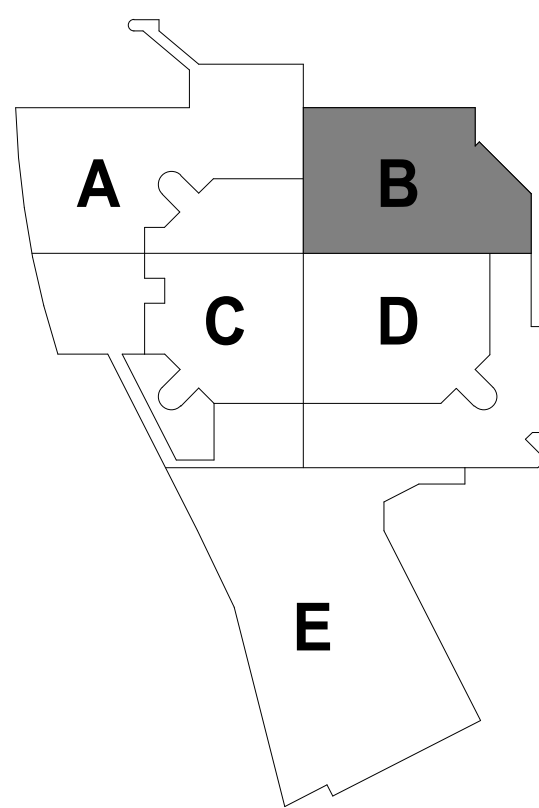

KEYPLAN

THIS DOCUMENT IS THE PROPERTY OF I & S GROUP, INC. AND MAY NOT BE USED, COPIED OR DUPLICATED WITHOUT PRIOR WRITTEN CONSENT.

PROJECT

LA CROSSE
CENTER
EXPANSION

LA CROSSE

WISCONSIN

REVISION SCHEDULE		
DATE	DESCRIPTION	BY

PROJECT NO.	16-19990
FILE NAME	19990 Tech R18.rvt
DRAWN BY	KCS
DESIGNED BY	ER
REVIEWED BY	MDN
ORIGINAL ISSUE DATE	MM/DD/YYYY
CLIENT PROJECT NO.	

TITLE

ARENA FLOOR
TECHNOLOGY -
AREA B

SHEET

3T2-11B

PRELIMINARY NOT FOR CONSTRUCTION



The diagram shows a five-piece jigsaw puzzle. Piece C is shaded gray and is located in the center-left position. Piece A is white and is located to the left of piece C. Piece B is white and is located to the right of piece C. Piece D is white and is located below piece B. Piece E is white and is located below piece D.

THIS DOCUMENT IS THE PROPERTY OF I & S GROUP,
INC. AND MAY NOT BE USED, COPIED OR DUPLICATED
WITHOUT PRIOR WRITTEN CONSENT


LA CROSSE CENTER EXPANSION

WISCONSIN

PROJECT NO.	16-19990
FILE NAME	19990 Tech R18.
DRAWN BY	KCS
DESIGNED BY	ER
REVIEWED BY	MDN
ORIGINAL ISSUE DATE	MM/DD/YYYY
CLIENT PROJECT NO.	

ARENA FLOOR TECHNOLOGY - AREA C

 3T2-11C




1 ARENA FLOOR TECHNOLOGY PLAN - AREA C
1/8" = 1'-0"



REFERENCE SCALE
0 1/4" 1/2" 1" 2"


8/20/2019 10:50:55 AM

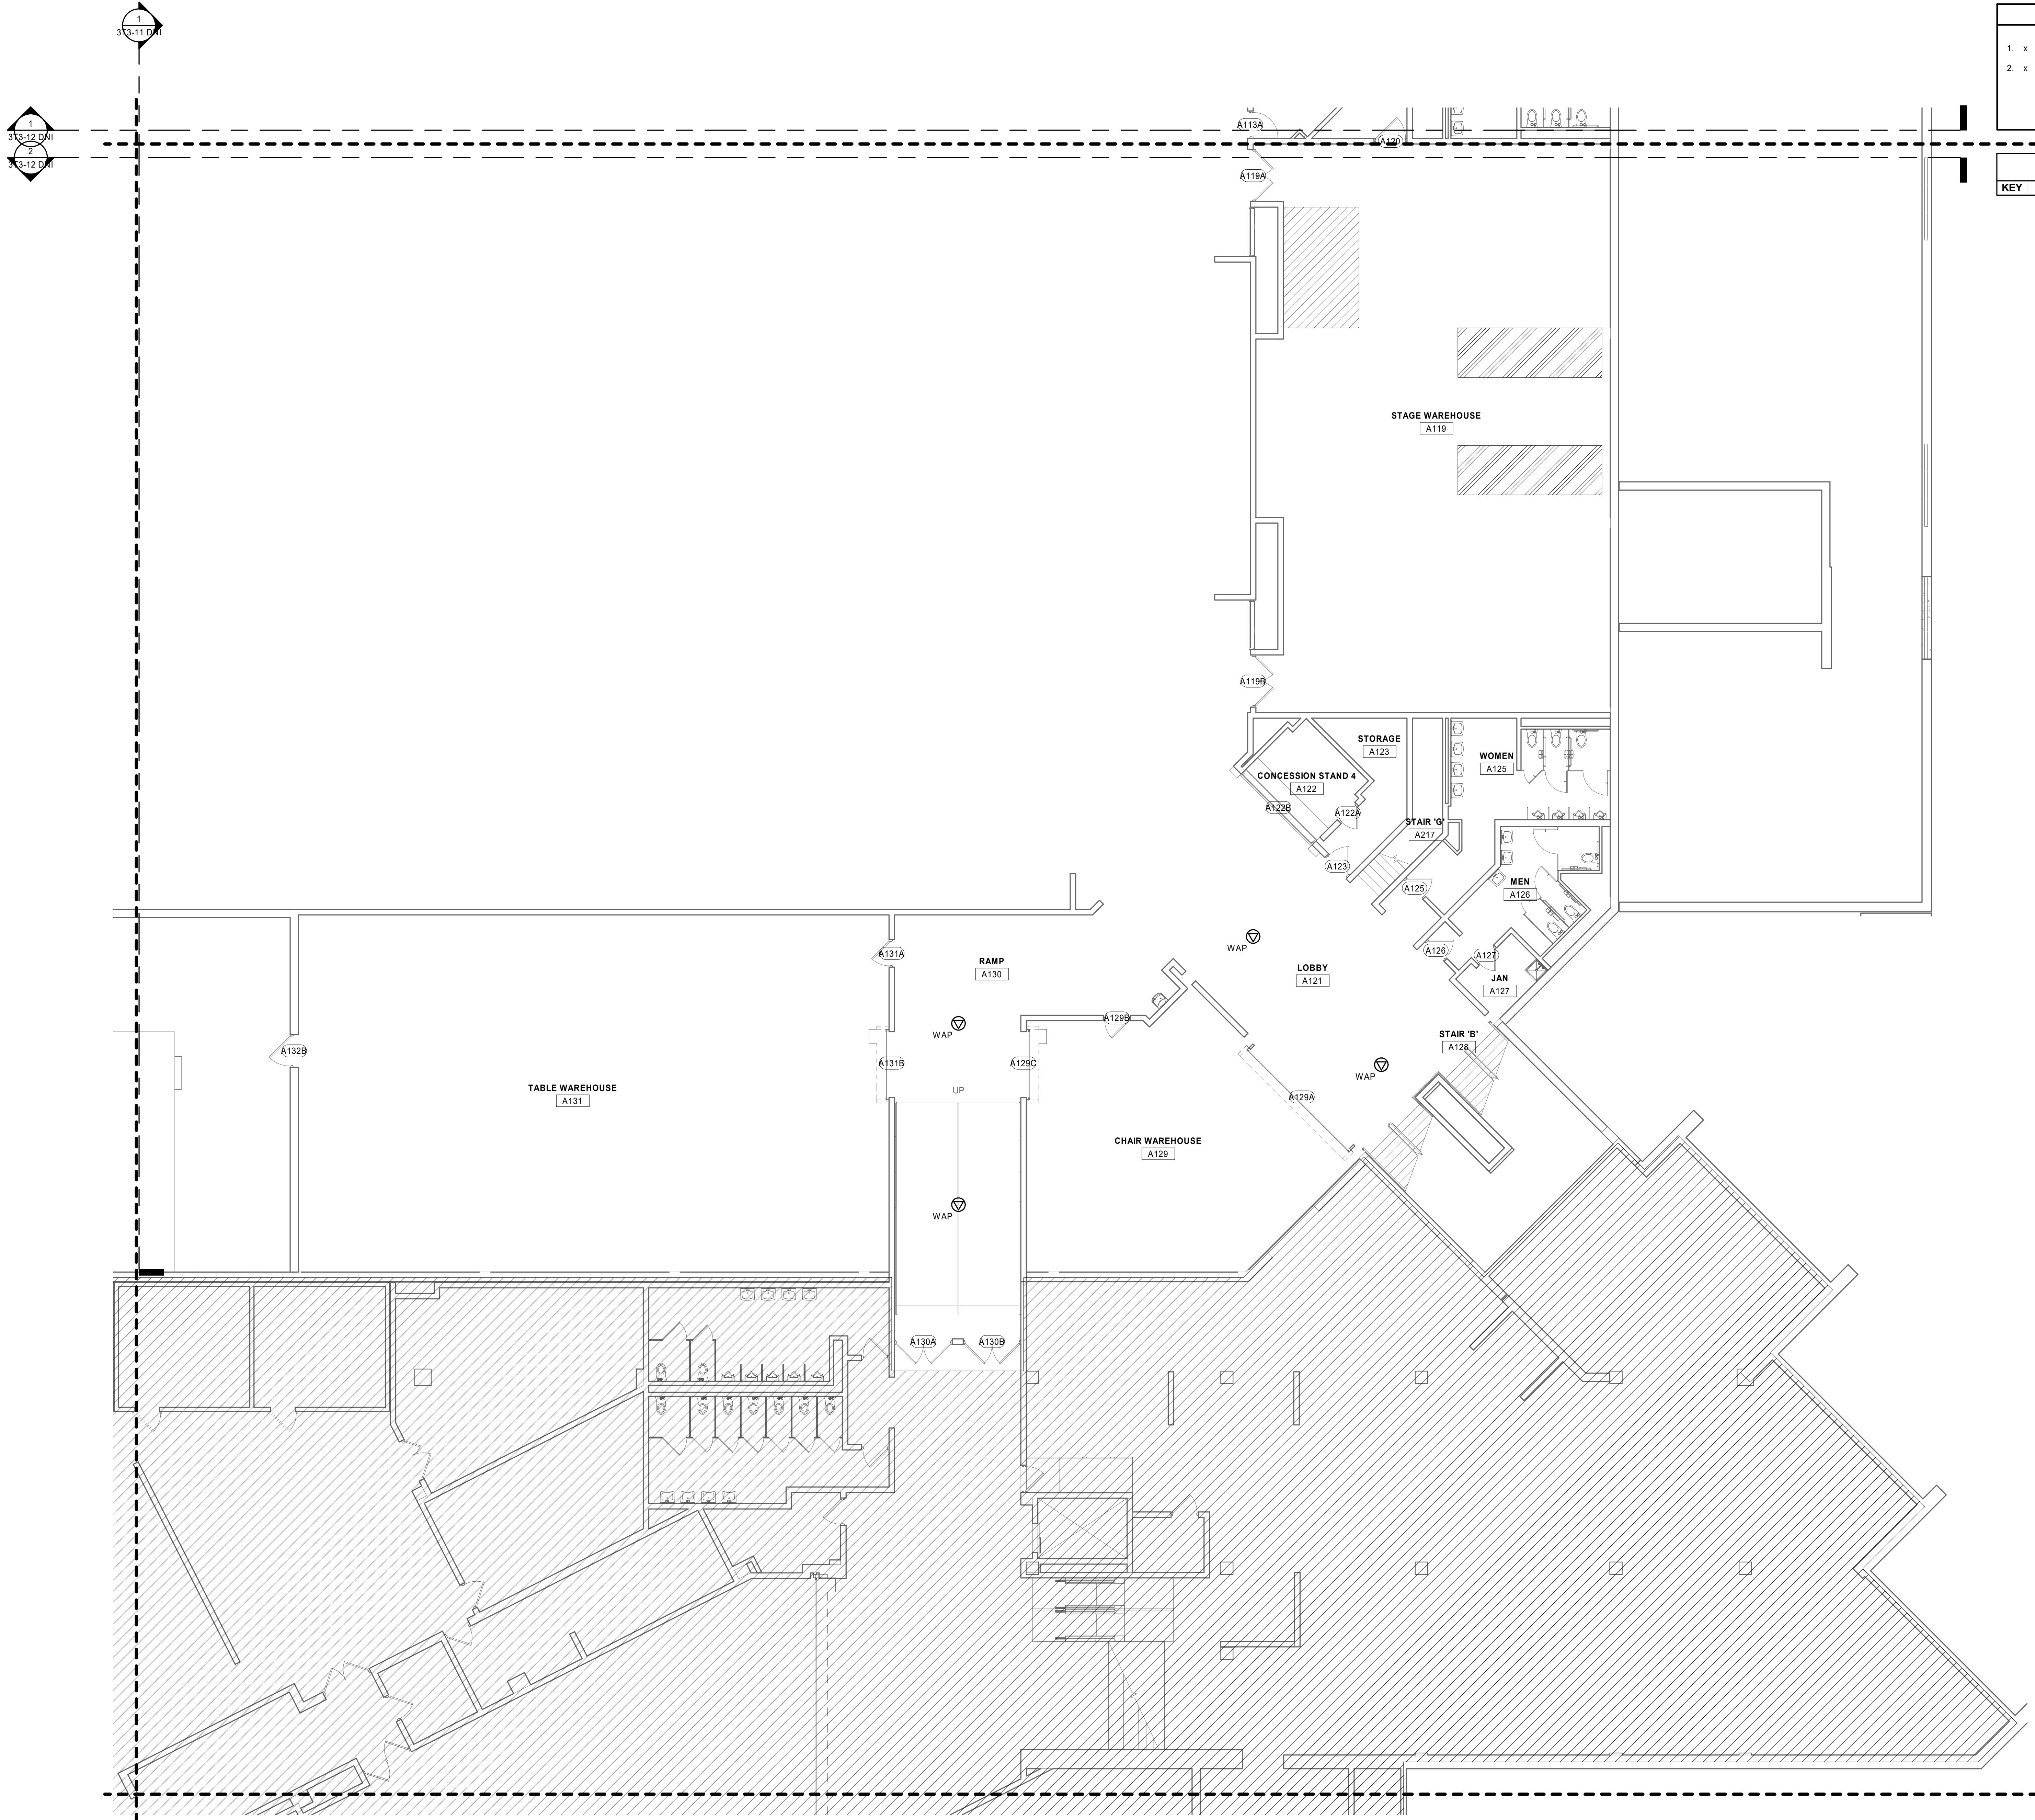

1 ARENA FLOOR TECHNOLOGY PLAN - AREA D
1/8" = 1'-0"

SHEET NOTES	
1.	x
2.	x

TECHNOLOGY KEYNOTE LEGEND	
KEY	KEYNOTE TEXT

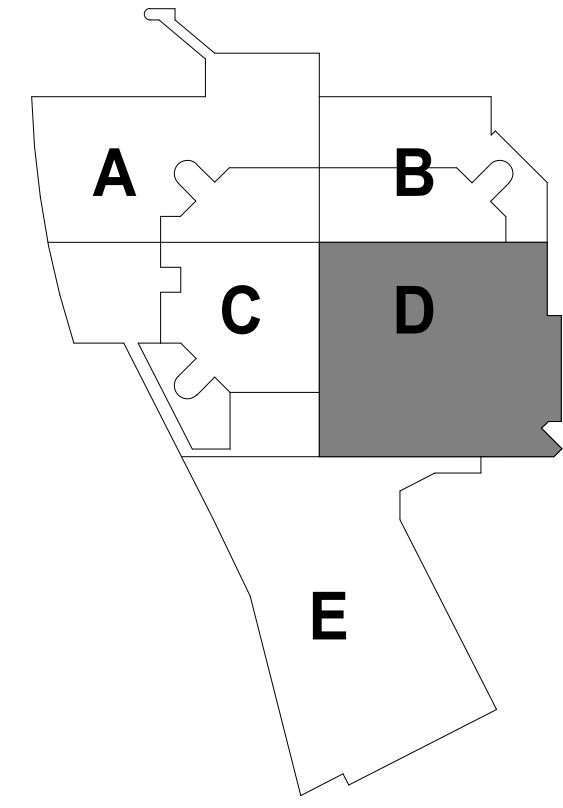

KEYPLAN

THIS DOCUMENT IS THE PROPERTY OF I & S GROUP, INC. AND MAY NOT BE USED, COPIED OR DUPLICATED WITHOUT PRIOR WRITTEN CONSENT.

PROJECT

LA CROSSE
CENTER
EXPANSION

LA CROSSE WISCONSIN

REVISION SCHEDULE		
DATE	DESCRIPTION	BY

PROJECT NO.	16-19990
FILE NAME	19990 Tech R18.rvt
DRAWN BY	KCS
DESIGNED BY	ER
REVIEWED BY	MDN
ORIGINAL ISSUE DATE	MM/DD/YYYY
CLIENT PROJECT NO.	


TITLE

ARENA FLOOR
TECHNOLOGY -
AREA D

SHEET

3T2-11D

PRELIMINARY NOT FOR CONSTRUCTION PRELIMINARY NOT FOR CONSTRUCTION

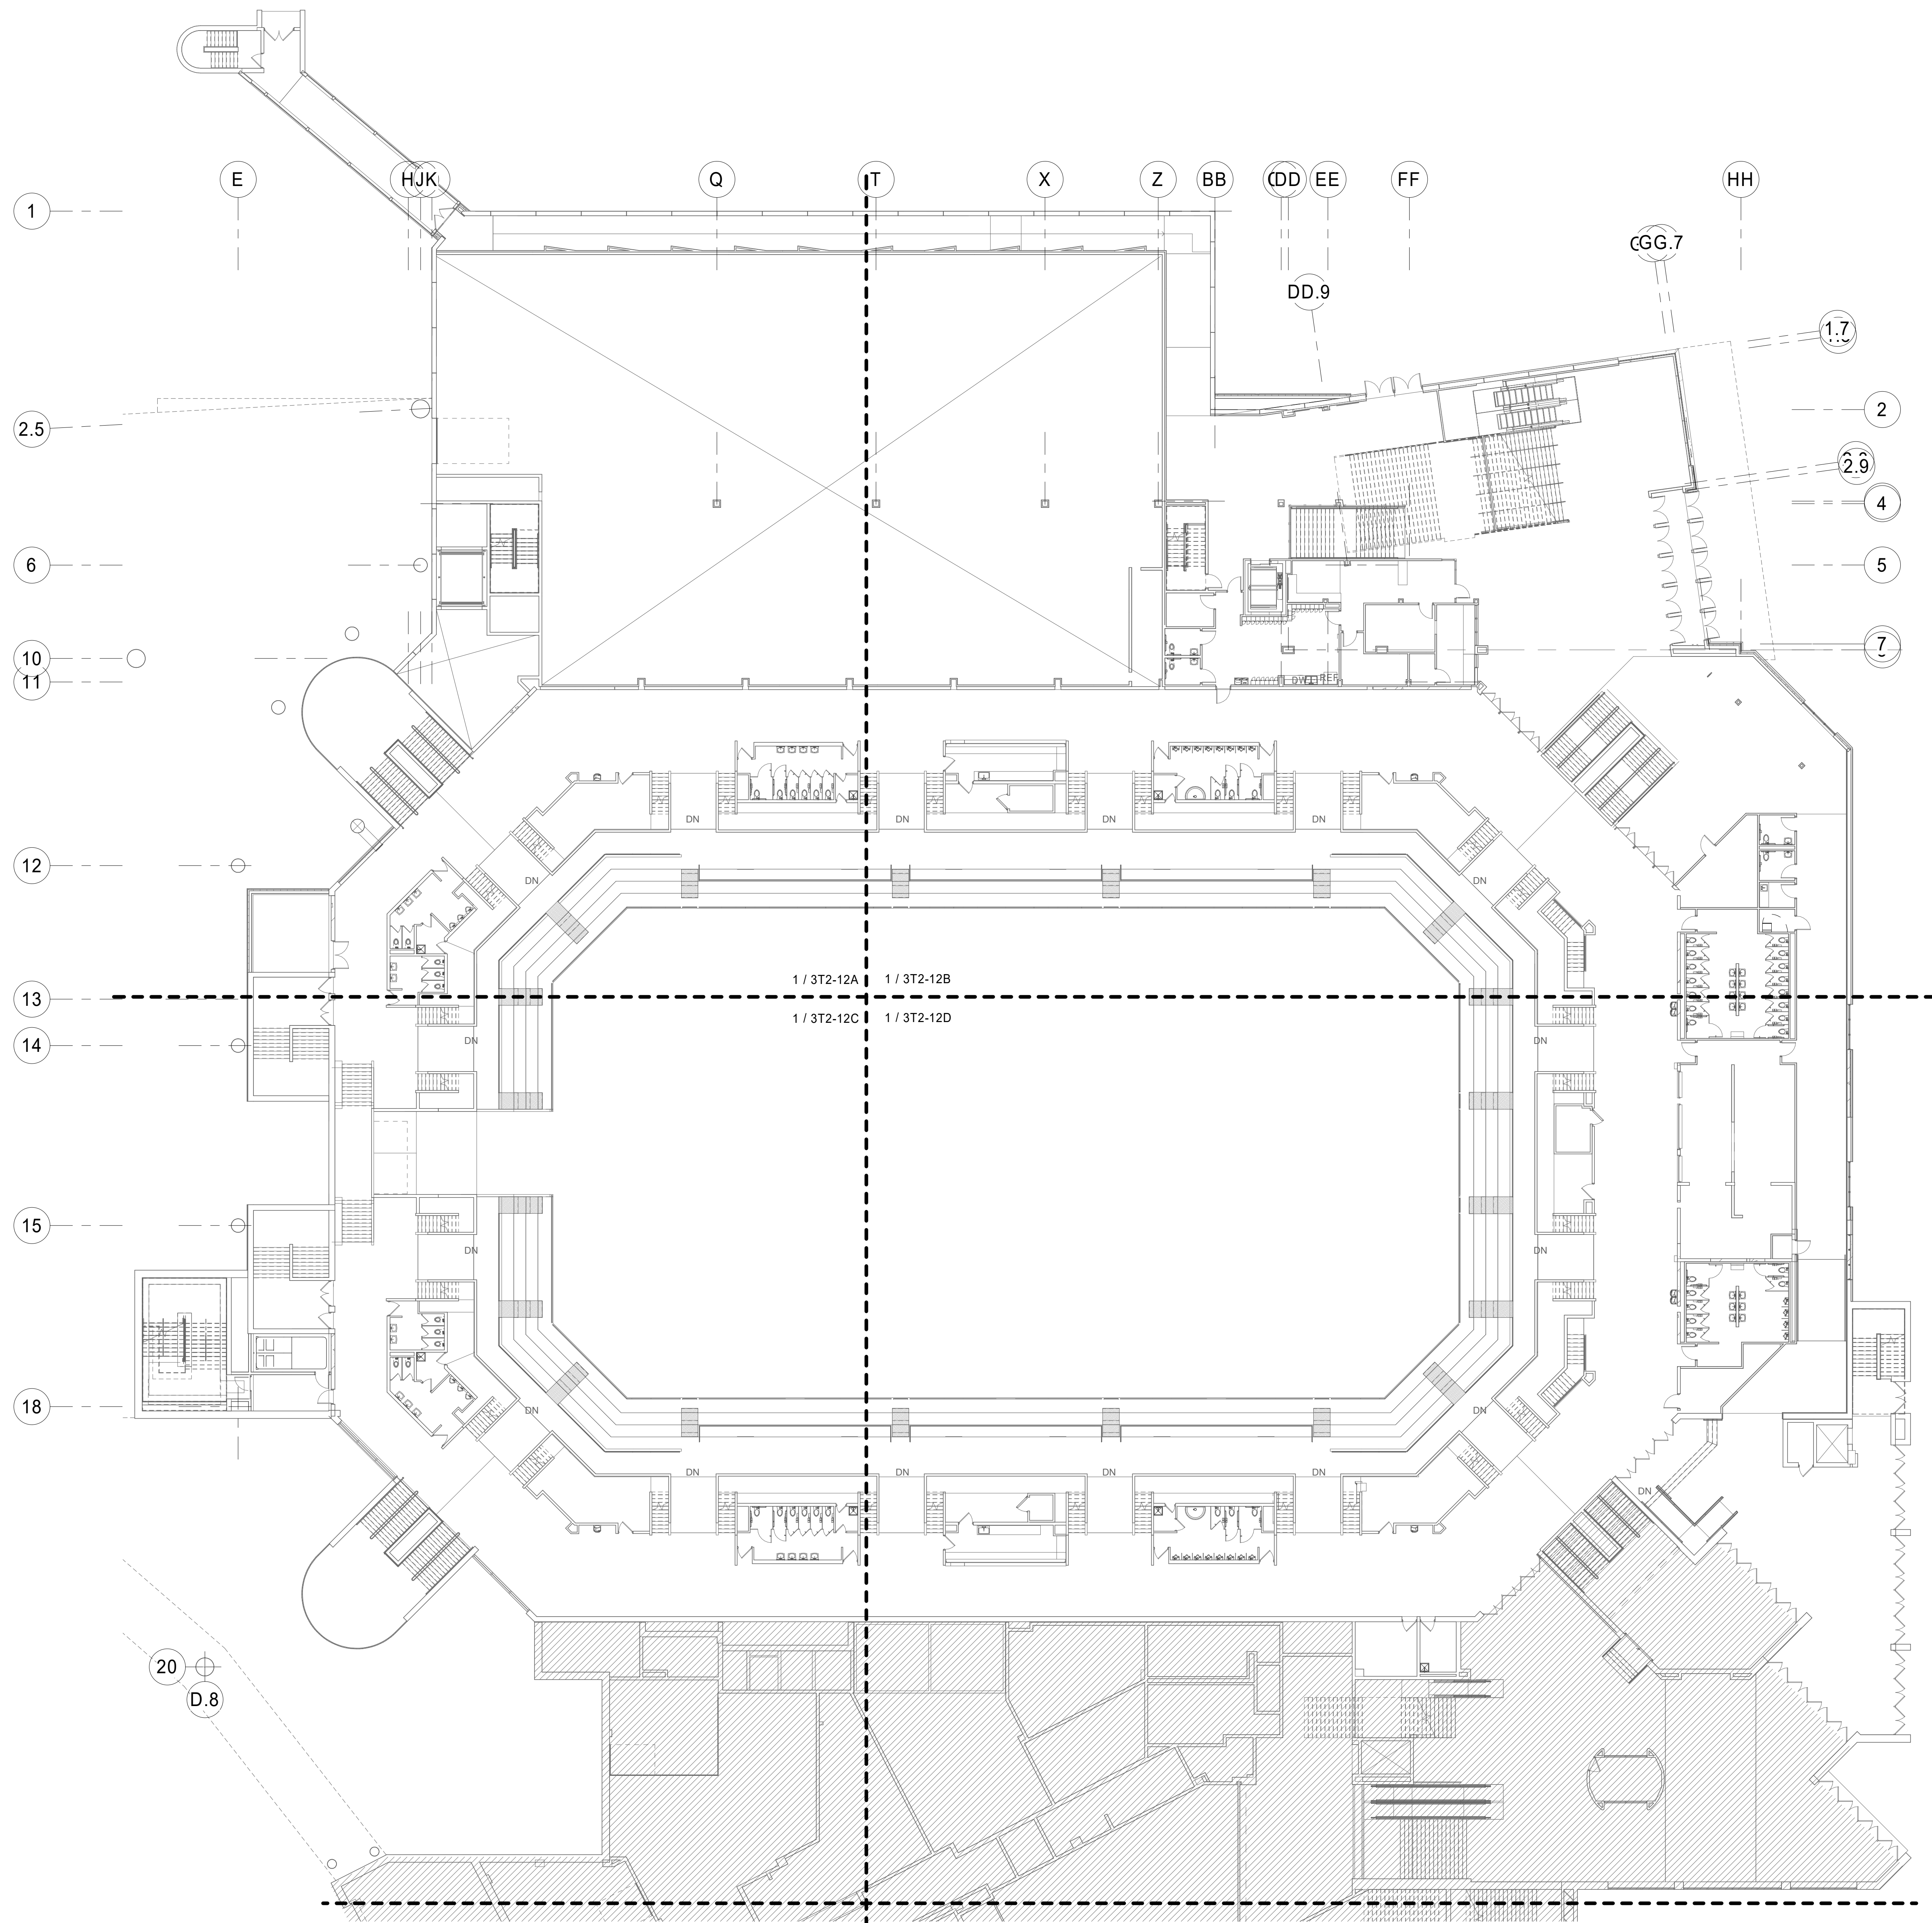


1 OVERALL CONCOURSE FLOOR TECHNOLOGY PLAN
1/16" = 1'-0"

REFERENCE SCALE
0 1/4" 1/2" 1" 2"

8/30/2019 10:51:16 AM

SHEET NOTES	
1. x	
2. x	

TECHNOLOGY KEYNOTE LEGEND	
KEY	KEYNOTE TEXT

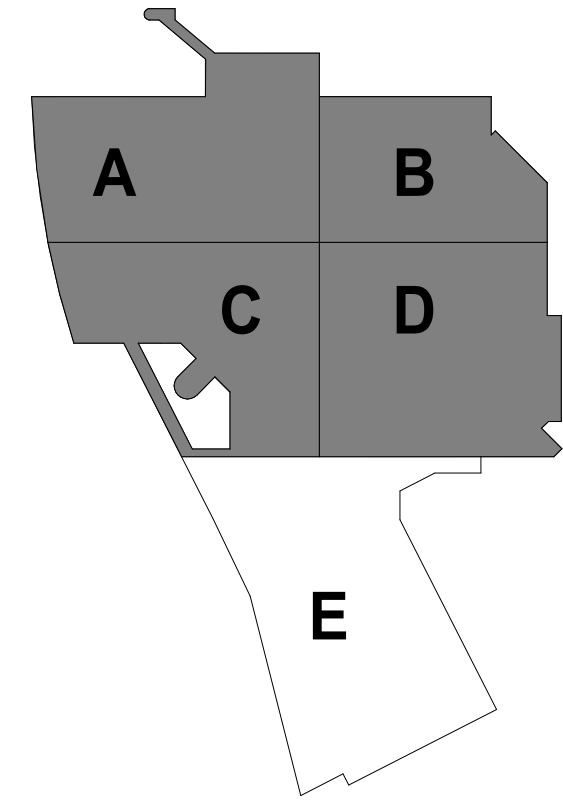

KEYPLAN

THIS DOCUMENT IS THE PROPERTY OF I & S GROUP, INC. AND MAY NOT BE USED, COPIED OR DUPLICATED WITHOUT PRIOR WRITTEN CONSENT.

PROJECT

LA CROSSE
CENTER
EXPANSION

LA CROSSE WISCONSIN

REVISION SCHEDULE		
DATE	DESCRIPTION	BY


PROJECT NO.	16-19990
FILE NAME	19990 Tech R18.rvt
DRAWN BY	KCS
DESIGNED BY	ER
REVIEWED BY	MDN
ORIGINAL ISSUE DATE	MM/DD/YYYY
CLIENT PROJECT NO.	

TITLE



OVERALL
CONCOURSE
FLOOR
TECHNOLOGY

SHEET

3T2-12

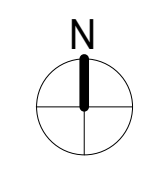

 PRELIMINARY NOT FOR CONSTRUCTION PRELIMINARY NOT FOR CONSTRUCTION

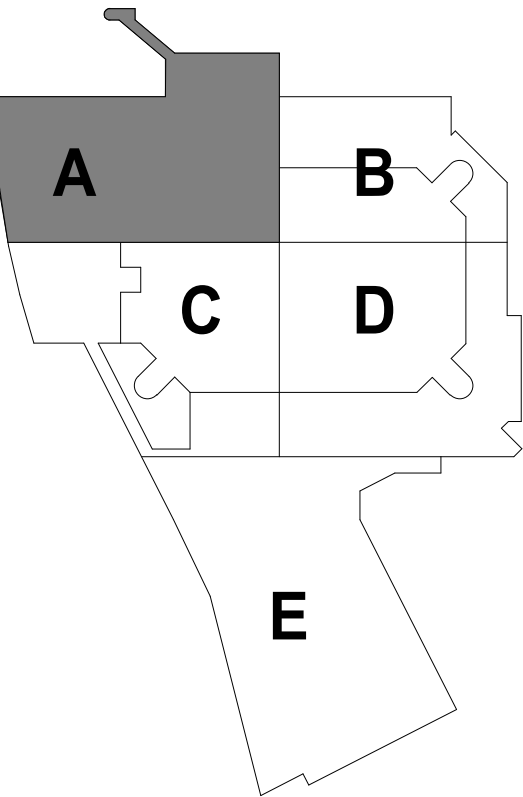

THIS DOCUMENT IS THE PROPERTY OF I & S GROUP, INC. AND MAY NOT BE USED, COPIED OR DUPLICATED WITHOUT PRIOR WRITTEN CONSENT.

PROJECT

LA CROSSE WISCONSIN


PROJECT NO.	16-19990
FILE NAME	19990 Tech R
DRAWN BY	KCS
DESIGNED BY	ER
REVIEWED BY	MDN
ORIGINAL ISSUE DATE	MM/DD/YYYY
CLIENT PROJECT NO.	

TITLE

SHEET


3T2-12A

PRELIMINARY NOT FOR CONSTRUCTION PRELIMINARY NOT FOR CONSTRUCTION

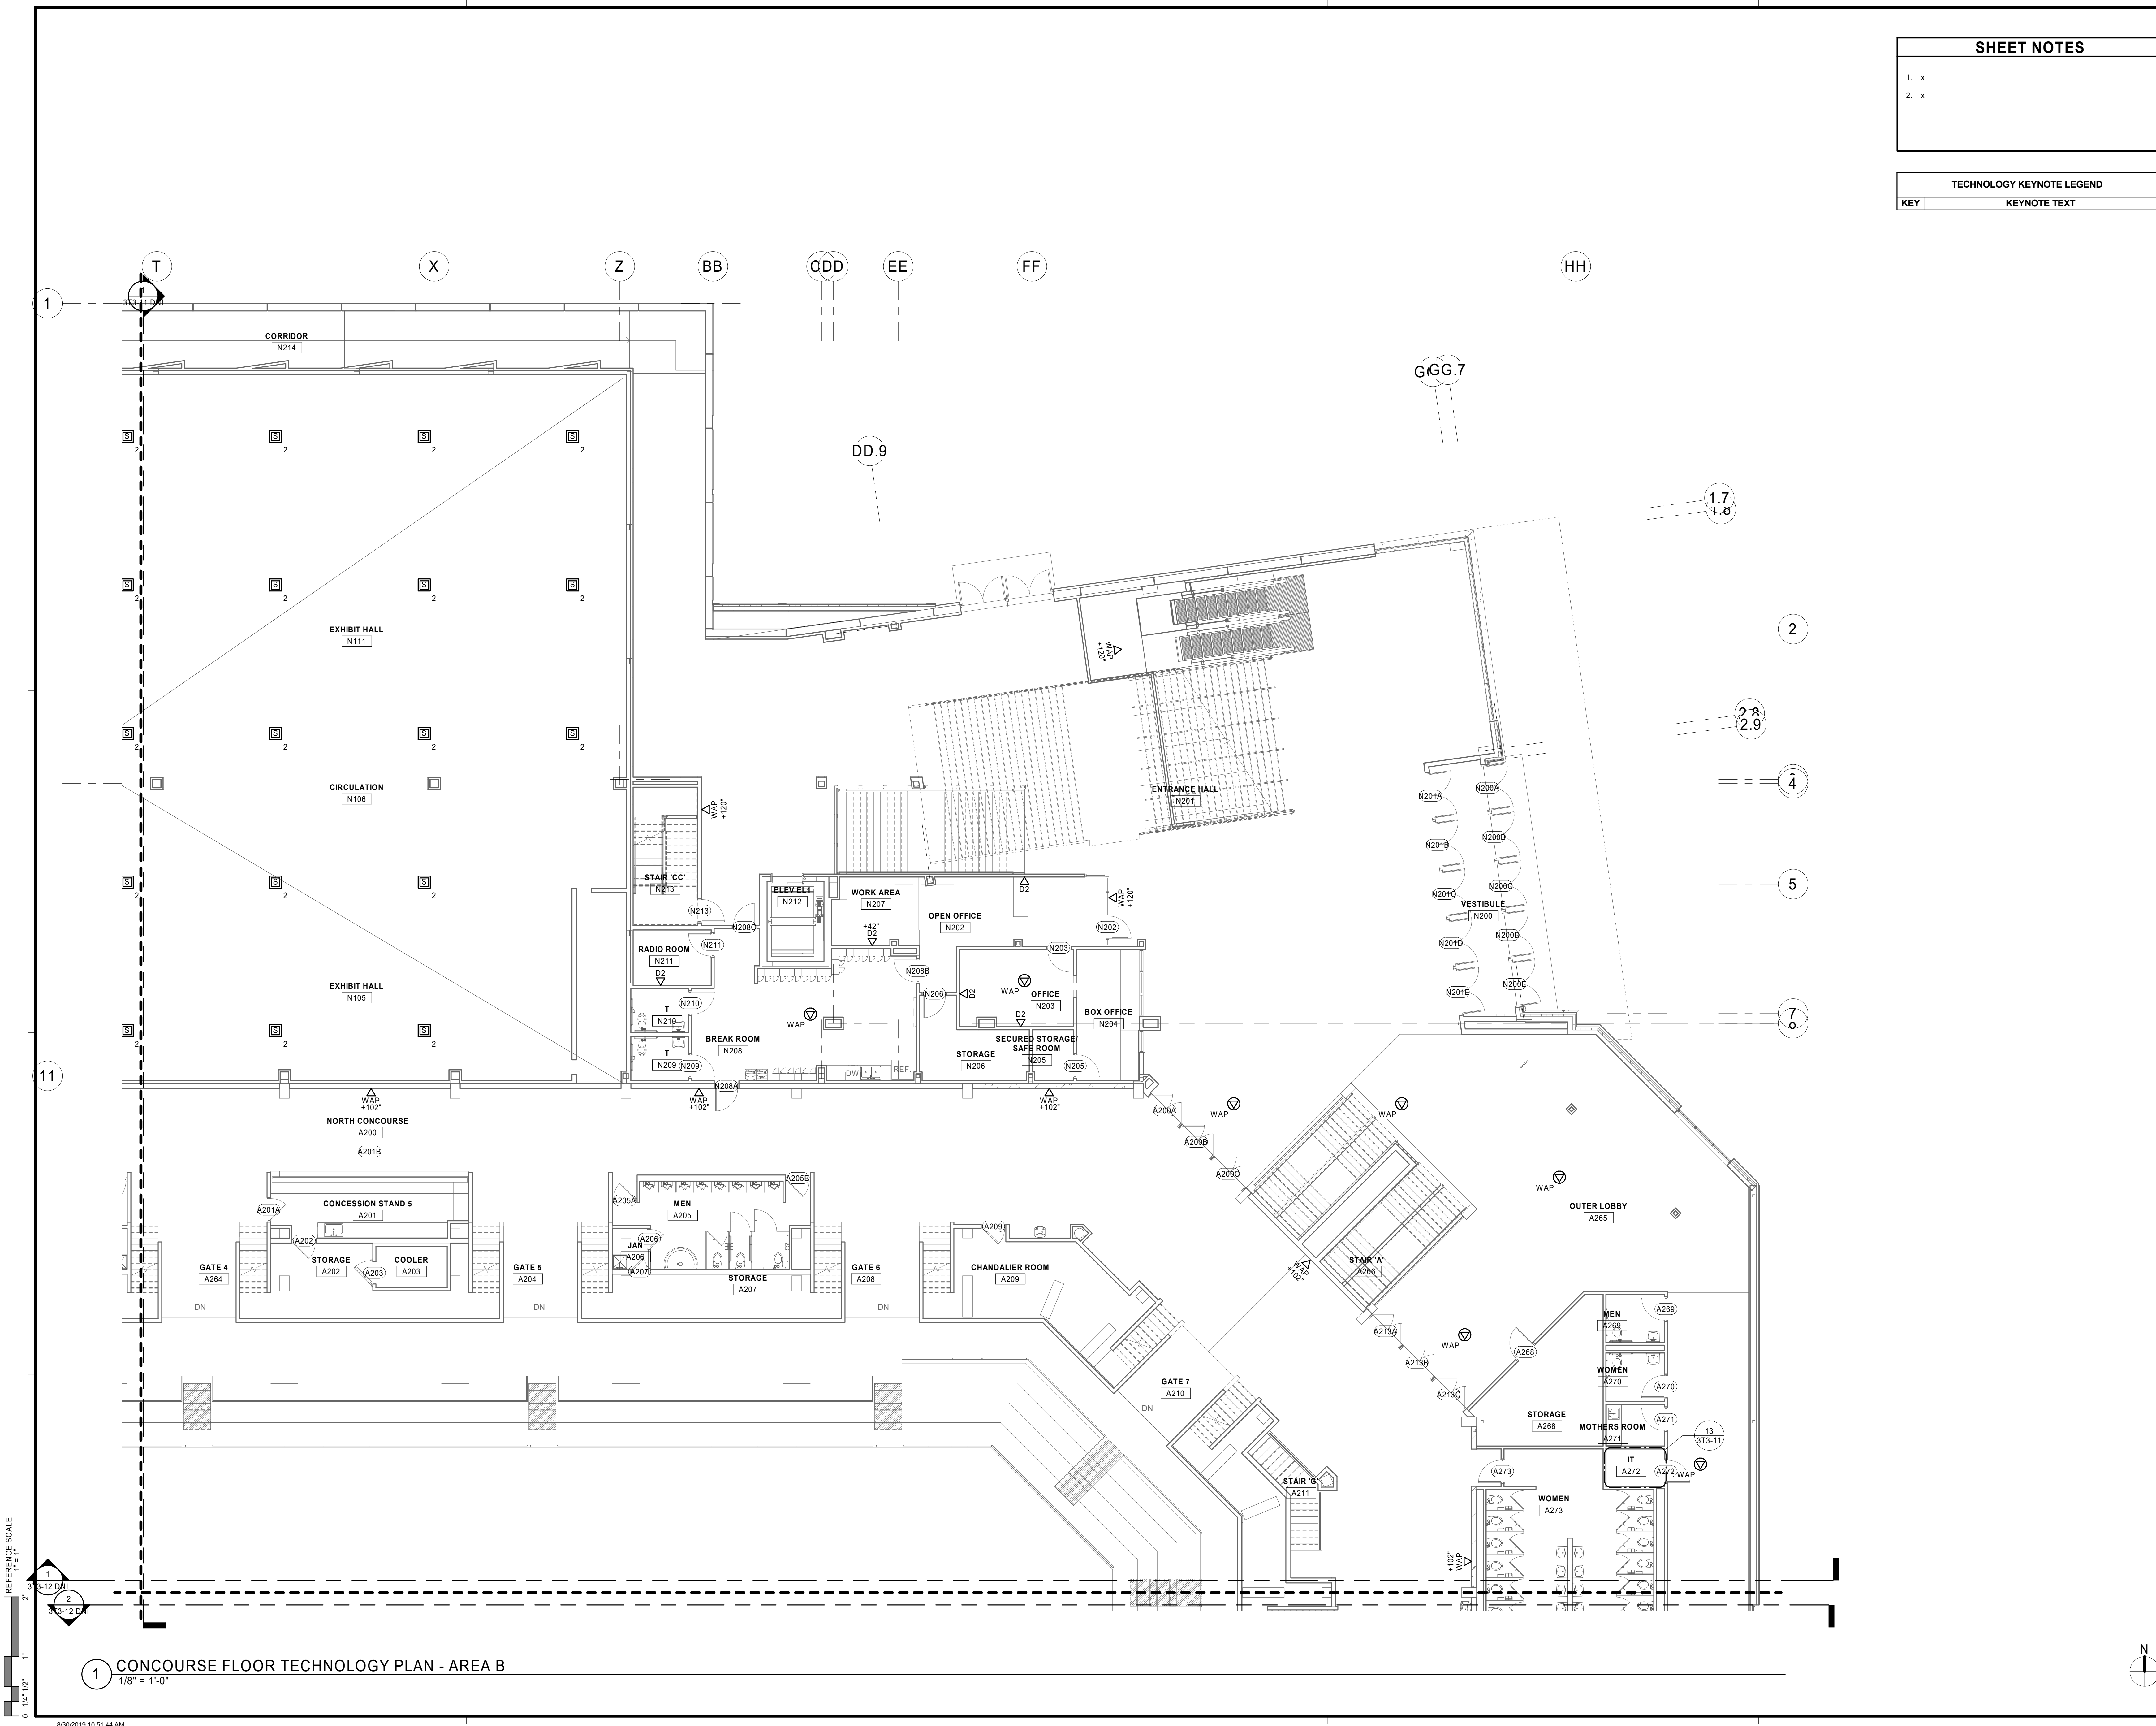

SHEET NOTES	
1.	x
2.	x

TECHNOLOGY KEYNOTE LEGEND	
KEY	KEYNOTE TEXT

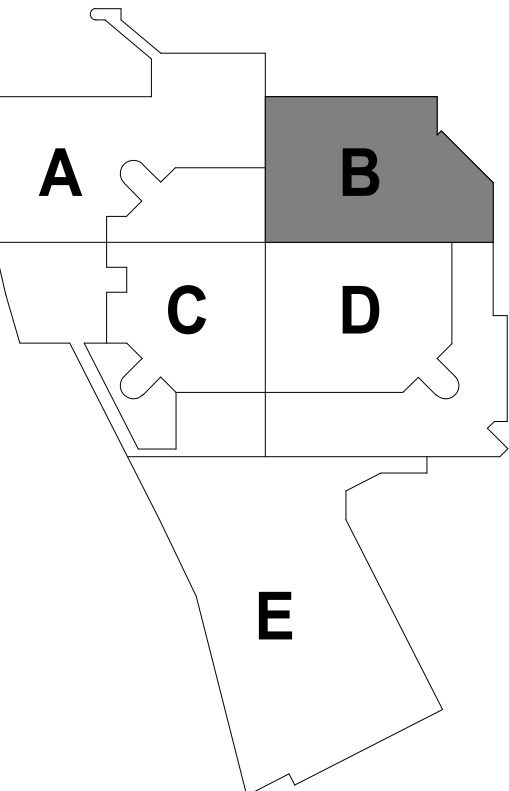

KEYPLAN

THIS DOCUMENT IS THE PROPERTY OF I & S GROUP, INC. AND MAY NOT BE USED, COPIED OR DUPLICATED WITHOUT PRIOR WRITTEN CONSENT.

PROJECT

LA CROSSE
CENTER
EXPANSION

LA CROSSE WISCONSIN

REVISION SCHEDULE		
DATE	DESCRIPTION	BY

PROJECT NO.	16-19990
FILE NAME	19990 Tech R18.rvt
DRAWN BY	KCS
DESIGNED BY	ER
REVIEWED BY	MDN
ORIGINAL ISSUE DATE	MM/DD/YYYY
CLIENT PROJECT NO.	

TITLE


CONCOURSE
FLOOR
TECHNOLOGY -
AREA B

SHEET
3T2-12B

REFERENCE SCALE
0 1/4" 1/2" 1" 2"
3'-12" DN
3'-12" DN


1 CONCOURSE FLOOR TECHNOLOGY PLAN - AREA B
1/8" = 1'-0"

PRELIMINARY NOT FOR CONSTRUCTION

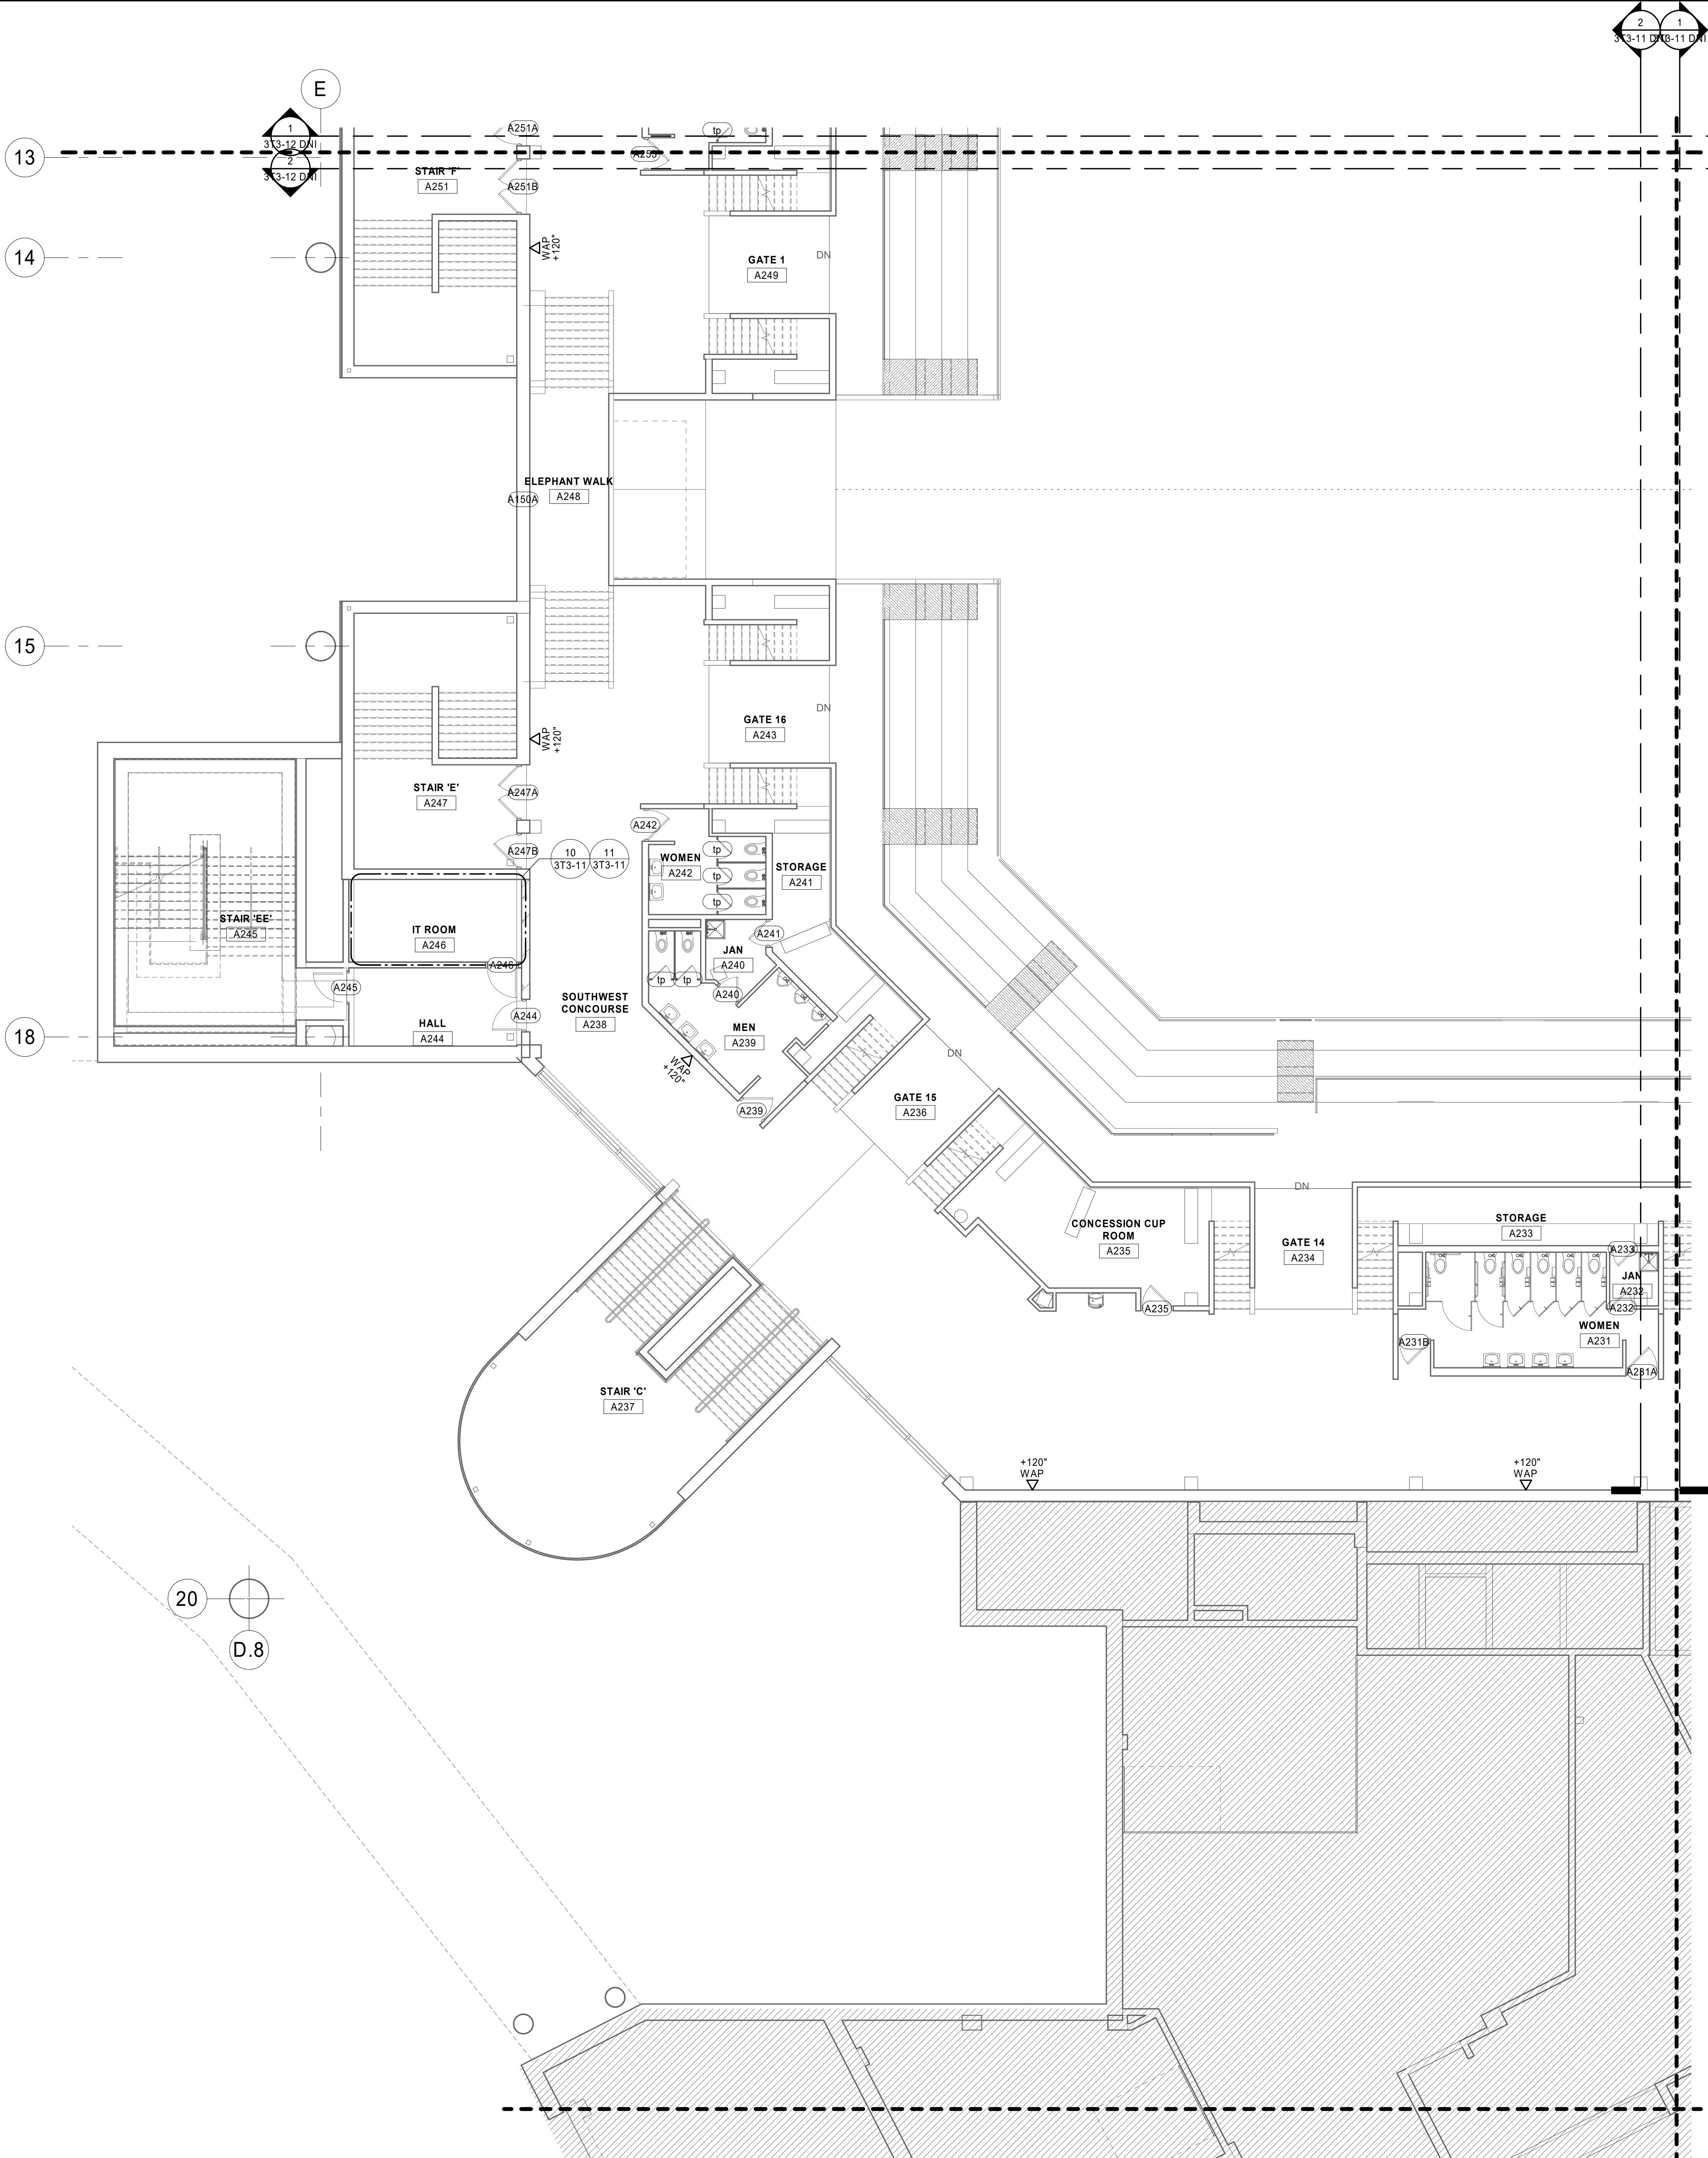

SHEET NOTES	
1. x	
2. x	

TECHNOLOGY KEYNOTE LEGEND	
KEY	KEYNOTE TEXT

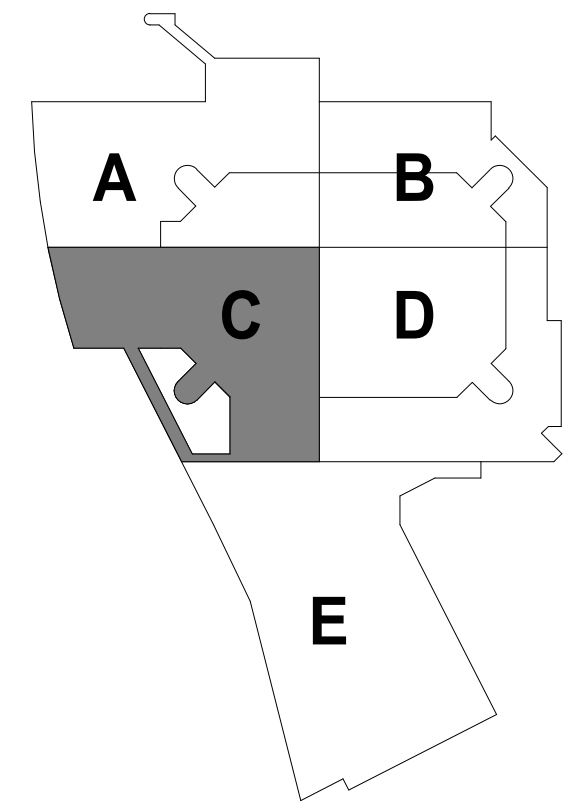

KEYPLAN

THIS DOCUMENT IS THE PROPERTY OF I & S GROUP, INC. AND MAY NOT BE USED, COPIED OR DUPLICATED WITHOUT PRIOR WRITTEN CONSENT.

PROJECT

LA CROSSE
CENTER
EXPANSION

LA CROSSE

WISCONSIN

REVISION SCHEDULE		
DATE	DESCRIPTION	BY

PROJECT NO.	16-19990
FILE NAME	19990 Tech R18.rvt
DRAWN BY	KCS
DESIGNED BY	ER
REVIEWED BY	MDN
ORIGINAL ISSUE DATE	MM/DD/YYYY
CLIENT PROJECT NO.	

TITLE

CONCOURSE
FLOOR
TECHNOLOGY -
AREA C

 
SHEET

3T2-12C


1 CONCOURSE FLOOR TECHNOLOGY PLAN - AREA C
1/8" = 1'-0"

REFERENCE SCALE
0 1/4" 1/2" 1" 2"

8/20/2019 10:57:35 AM




PRELIMINARY NOT FOR CONSTRUCTION PRELIMINARY NOT FOR CONSTRUCTION

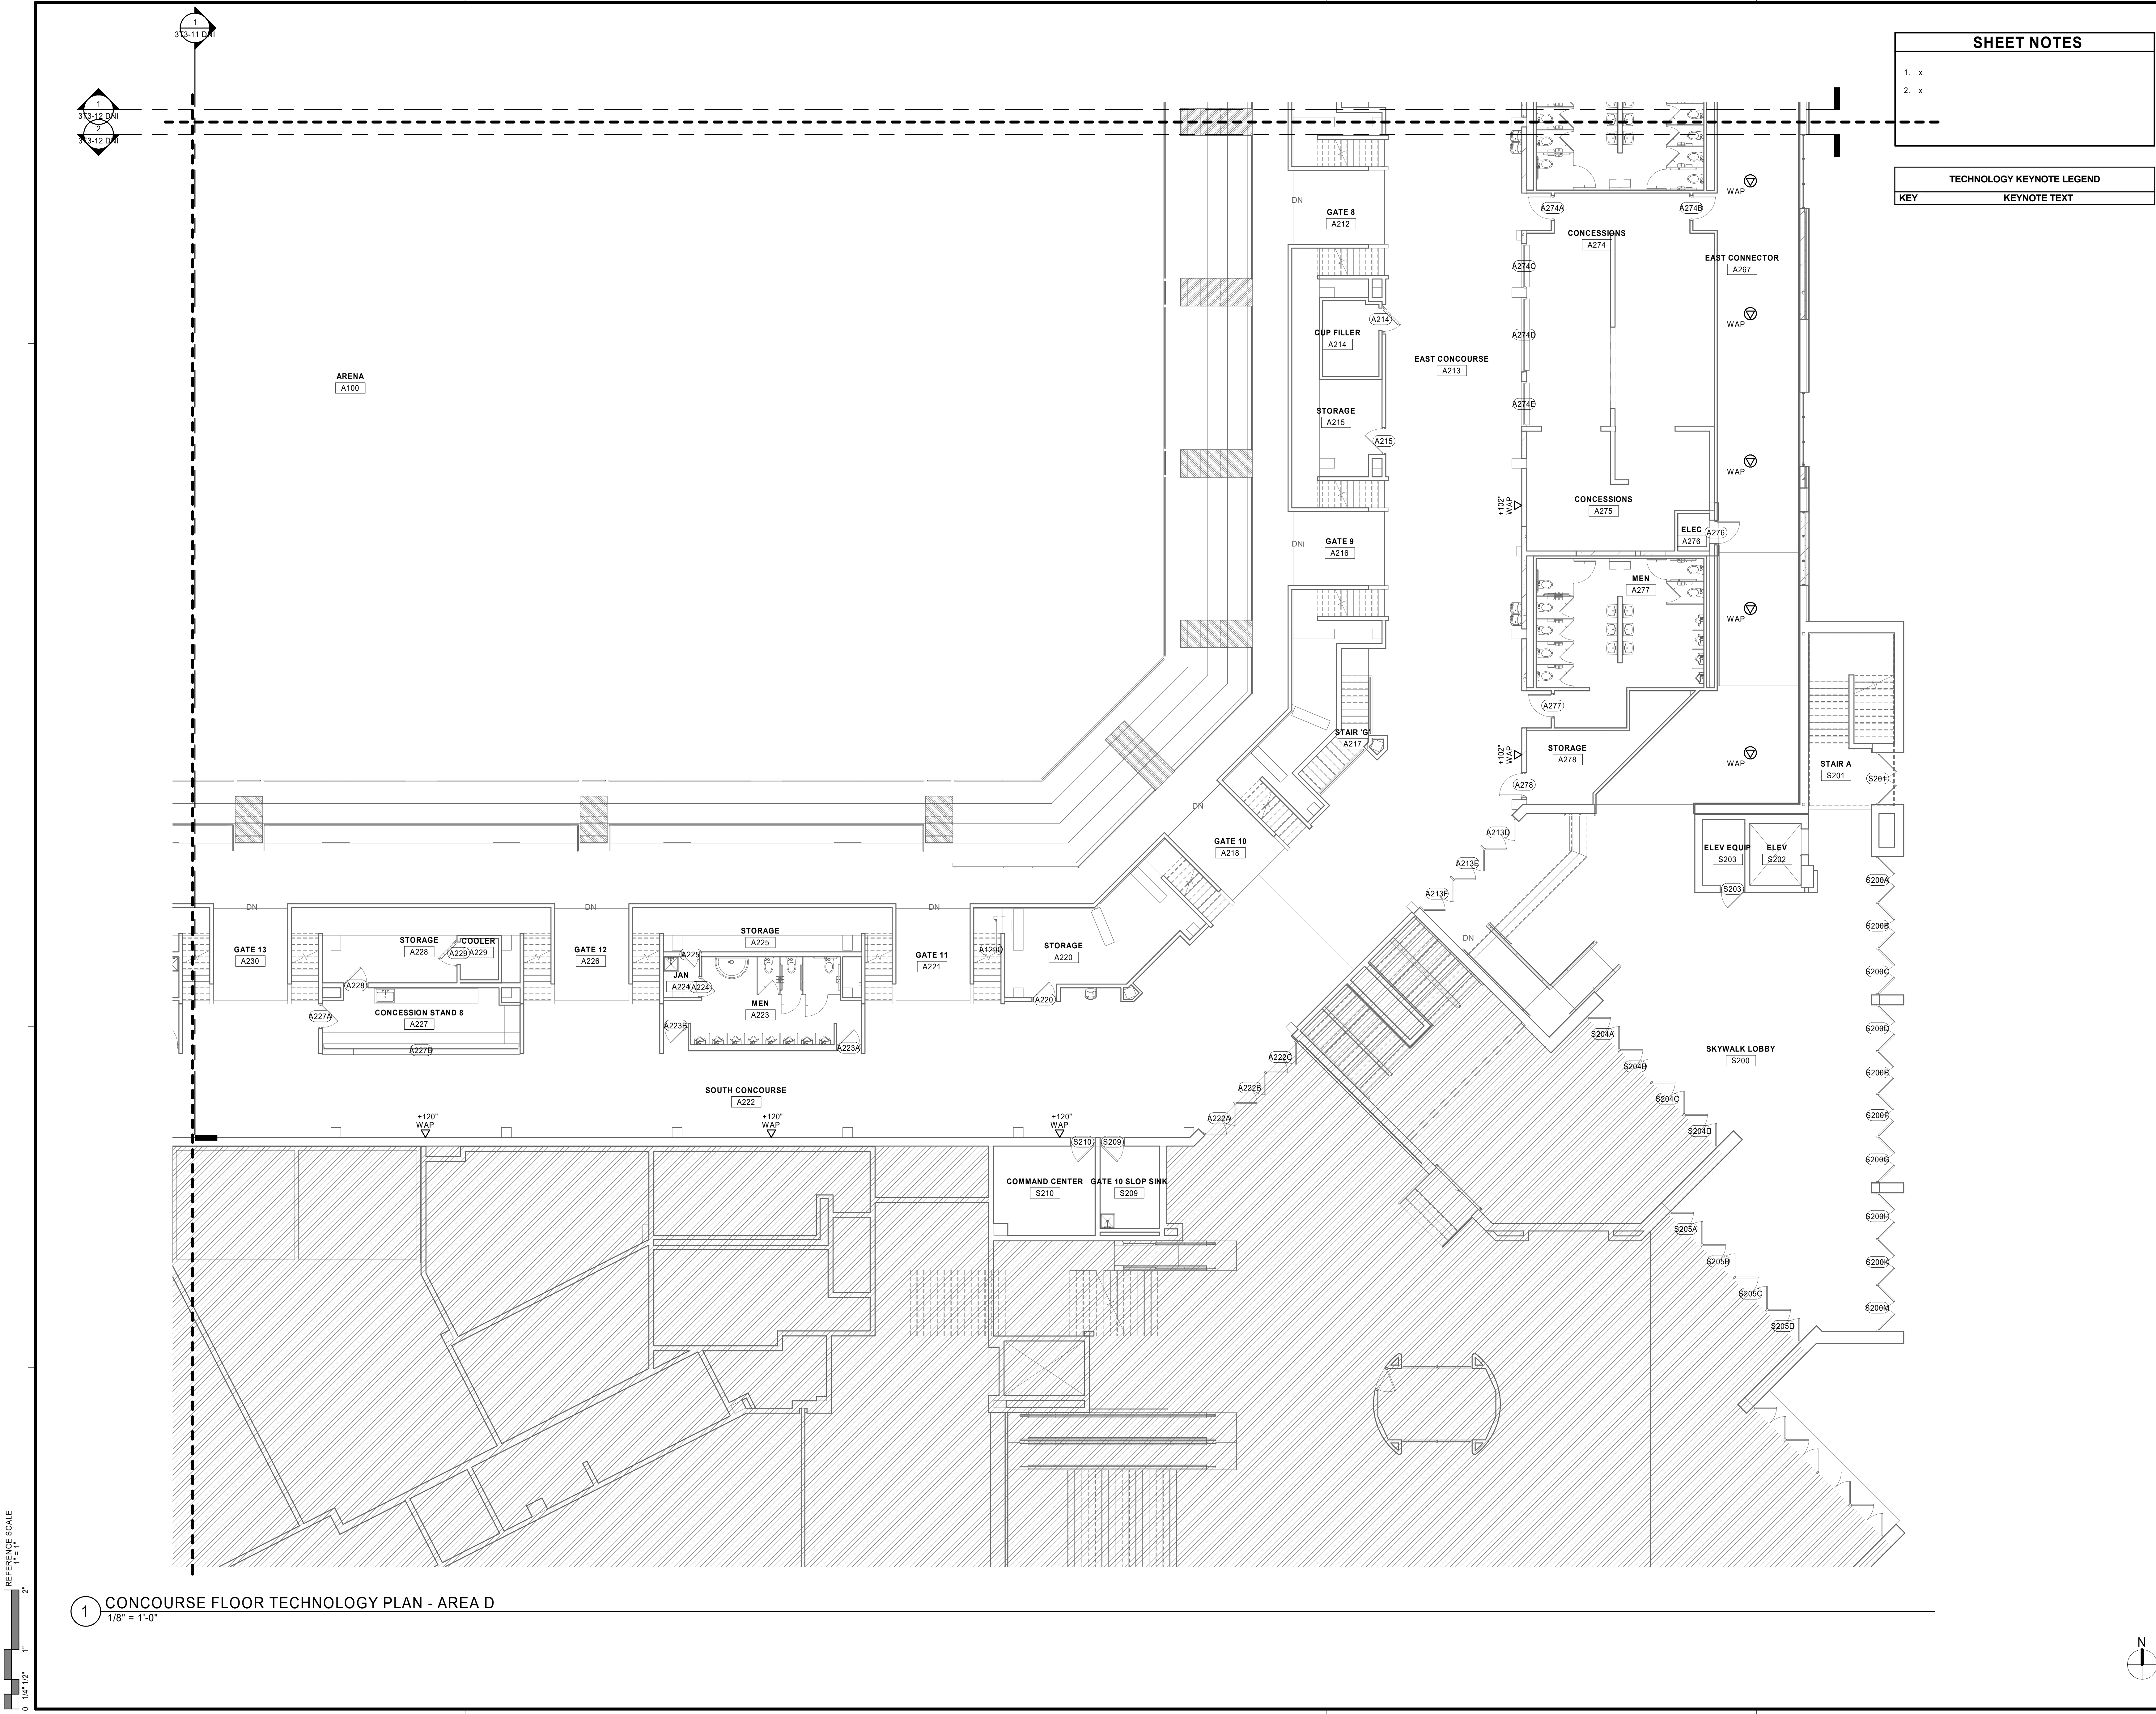

SHEET NOTES	
1. x	
2. x	

TECHNOLOGY KEYNOTE LEGEND	
KEY	KEYNOTE TEXT

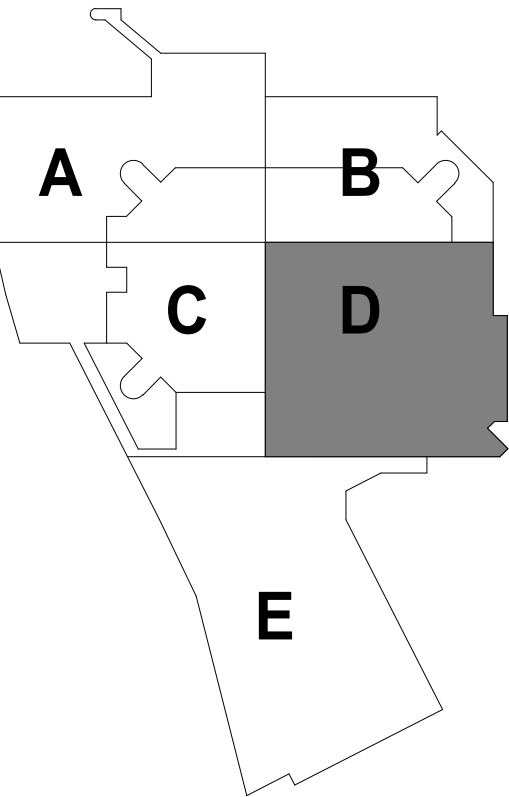

KEYPLAN

THIS DOCUMENT IS THE PROPERTY OF I & S GROUP, INC. AND MAY NOT BE USED, COPIED OR DUPLICATED WITHOUT PRIOR WRITTEN CONSENT.

PROJECT

LA CROSSE
CENTER
EXPANSION

LA CROSSE WISCONSIN

REVISION SCHEDULE		
DATE	DESCRIPTION	BY

PROJECT NO.	16-19990
FILE NAME	19990 Tech R18.rvt
DRAWN BY	KCS
DESIGNED BY	ER
REVIEWED BY	MDN
ORIGINAL ISSUE DATE	MM/DD/YYYY
CLIENT PROJECT NO.	

TITLE

 
CONCOURSE
FLOOR
TECHNOLOGY -
AREA D

SHEET


3T2-12D

1 CONCOURSE FLOOR TECHNOLOGY PLAN - AREA D
1/8" = 1'-0"

REFERENCE SCALE
0 1/4" 1/2" 1" 2"




PRELIMINARY NOT FOR CONSTRUCTION

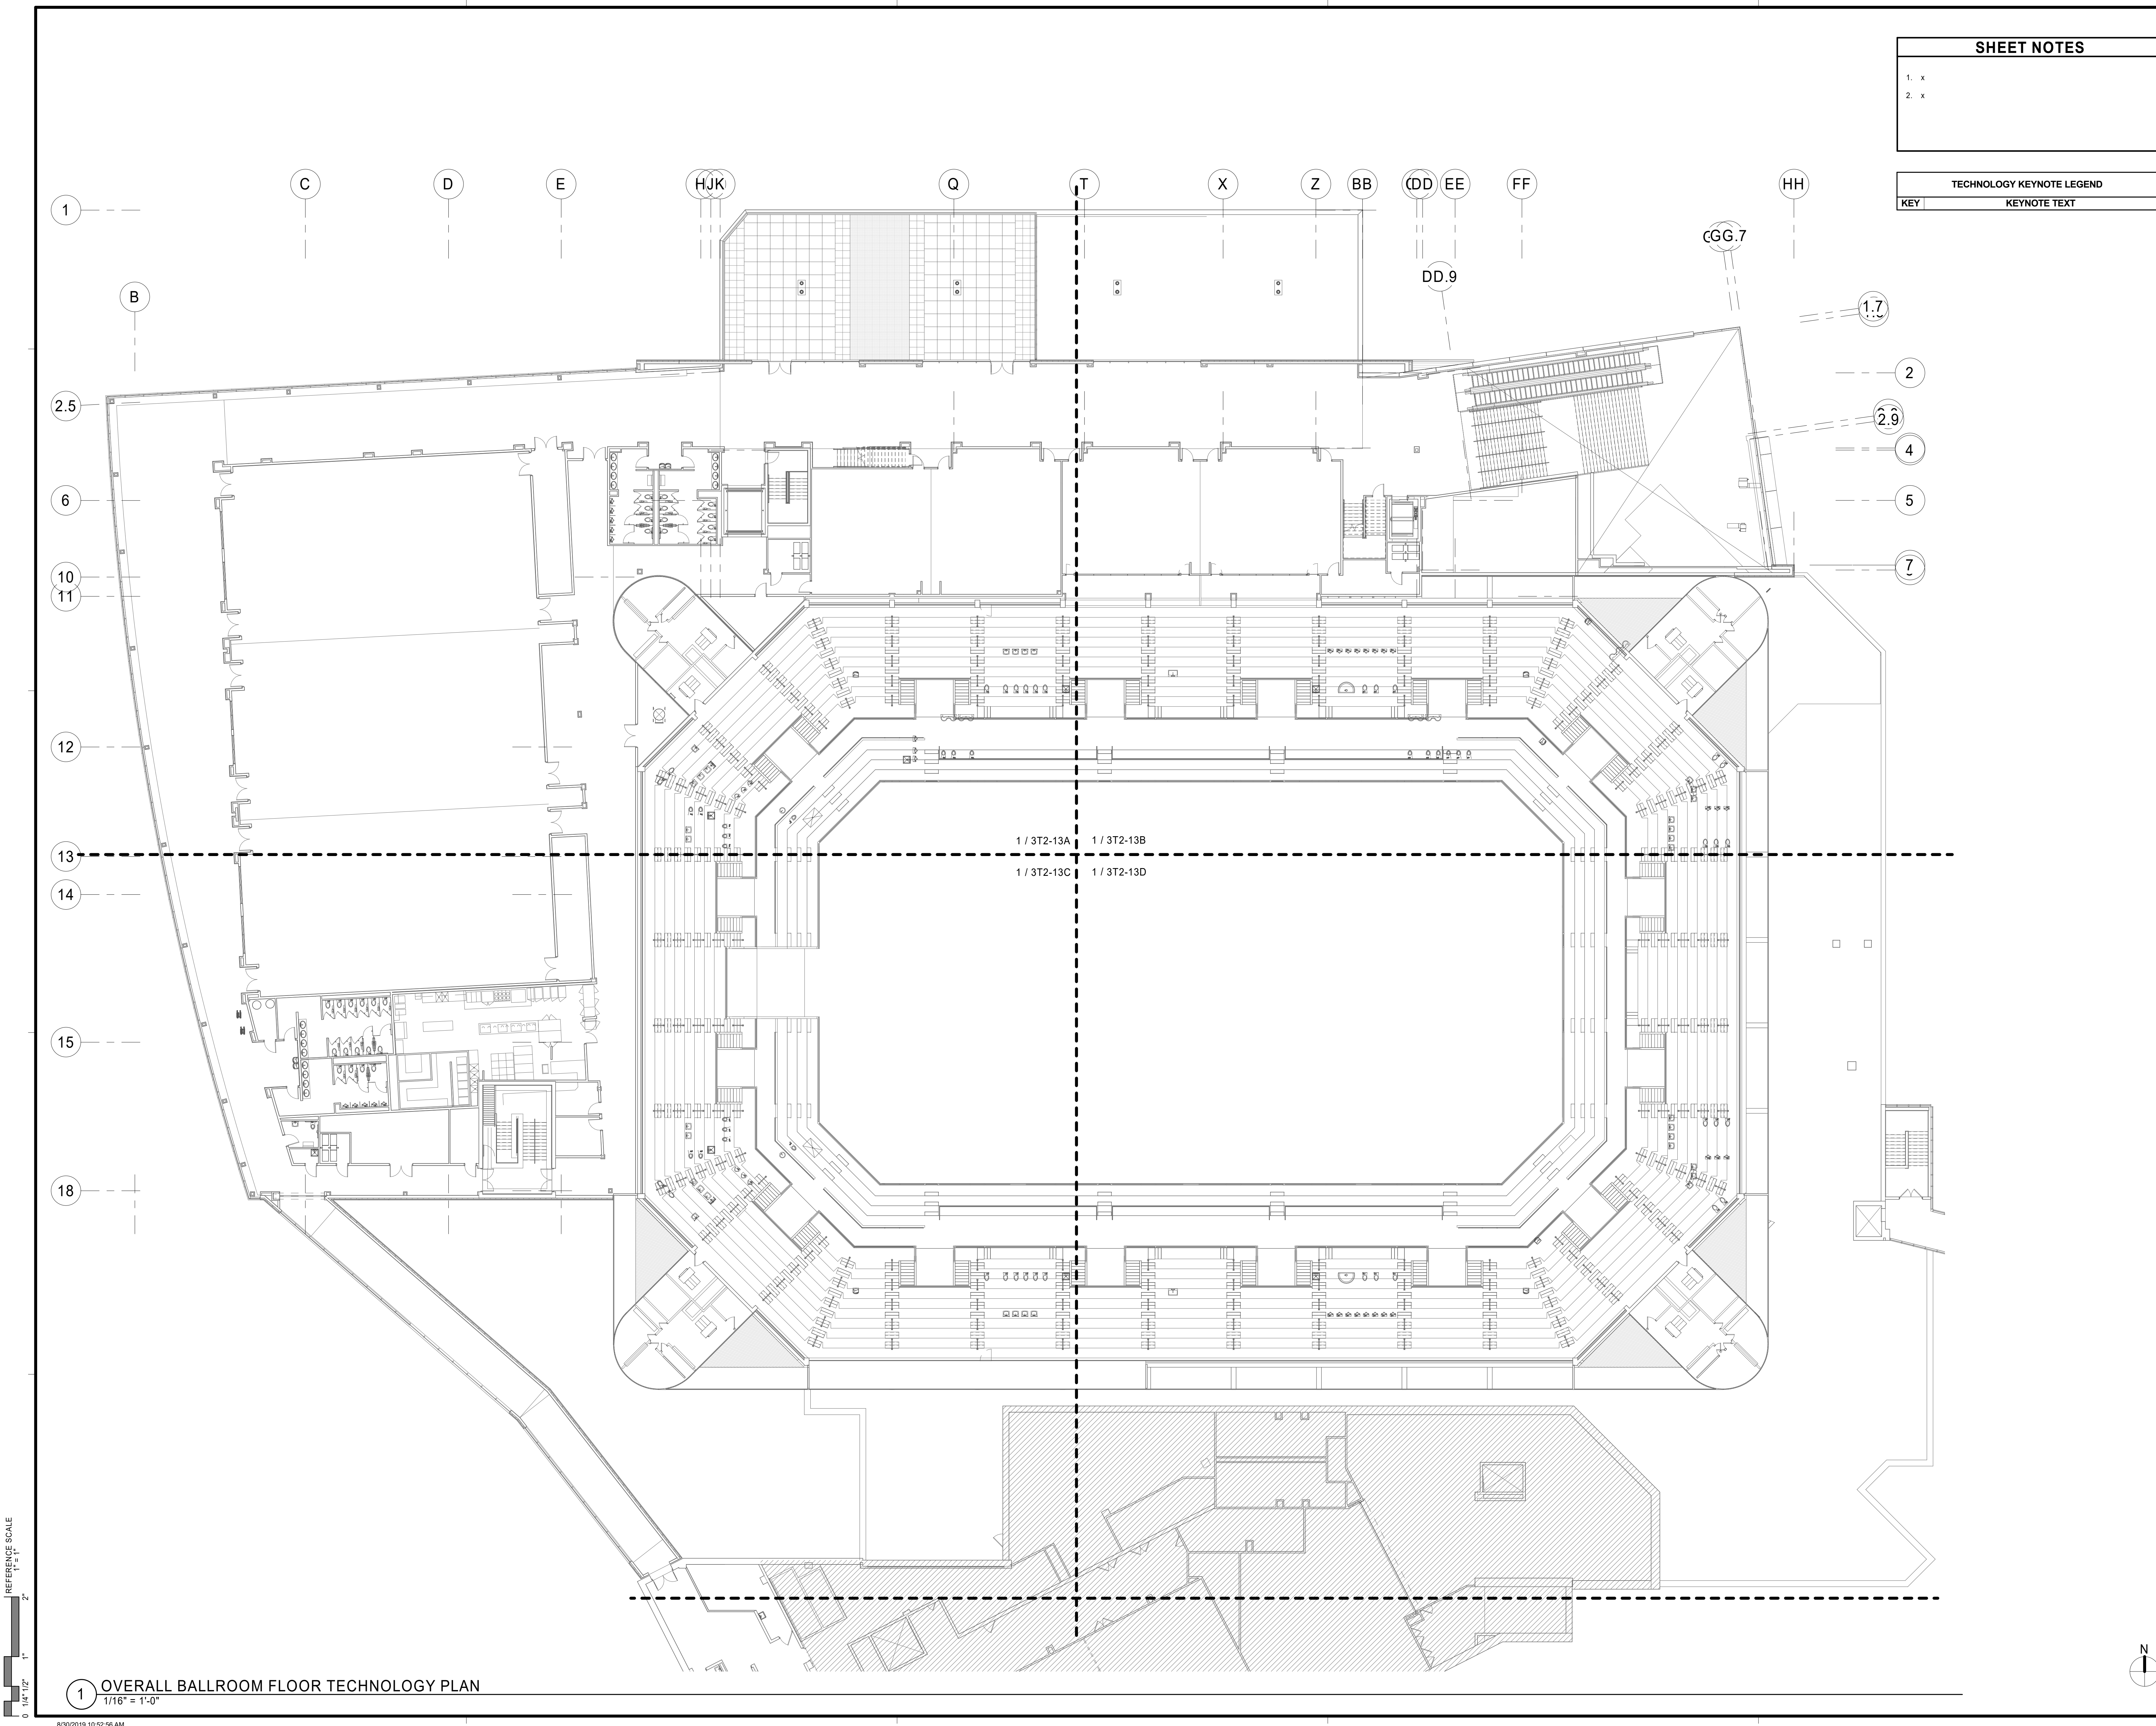

SHEET NOTES	
1. x	
2. x	

TECHNOLOGY KEYNOTE LEGEND	
KEY	KEYNOTE TEXT

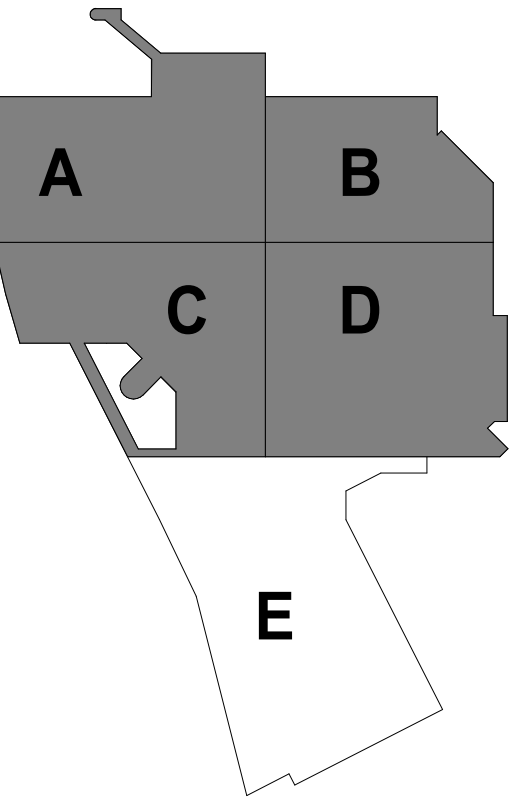

KEYPLAN

THIS DOCUMENT IS THE PROPERTY OF I & S GROUP, INC. AND MAY NOT BE USED, COPIED OR DUPLICATED WITHOUT PRIOR WRITTEN CONSENT.

PROJECT

LA CROSSE
CENTER
EXPANSION

LA CROSSE WISCONSIN

REVISION SCHEDULE		
DATE	DESCRIPTION	BY

PROJECT NO.	16-19990
FILE NAME	19990 Tech R18.rvt
DRAWN BY	KCS
DESIGNED BY	ER
REVIEWED BY	MDN
ORIGINAL ISSUE DATE	MM/DD/YYYY
CLIENT PROJECT NO.	

TITLE

OVERALL
BALLROOM FLOOR
TECHNOLOGY

 
SHEET

3T2-13


REFERENCE SCALE
0 1/4" 1/2" 1" 2"

1 OVERALL BALLROOM FLOOR TECHNOLOGY PLAN
1/16" = 1'-0"

9/20/2019 10:52:56 AM



PRELIMINARY NOT FOR CONSTRUCTION PRELIMINARY NOT FOR CONSTRUCTION

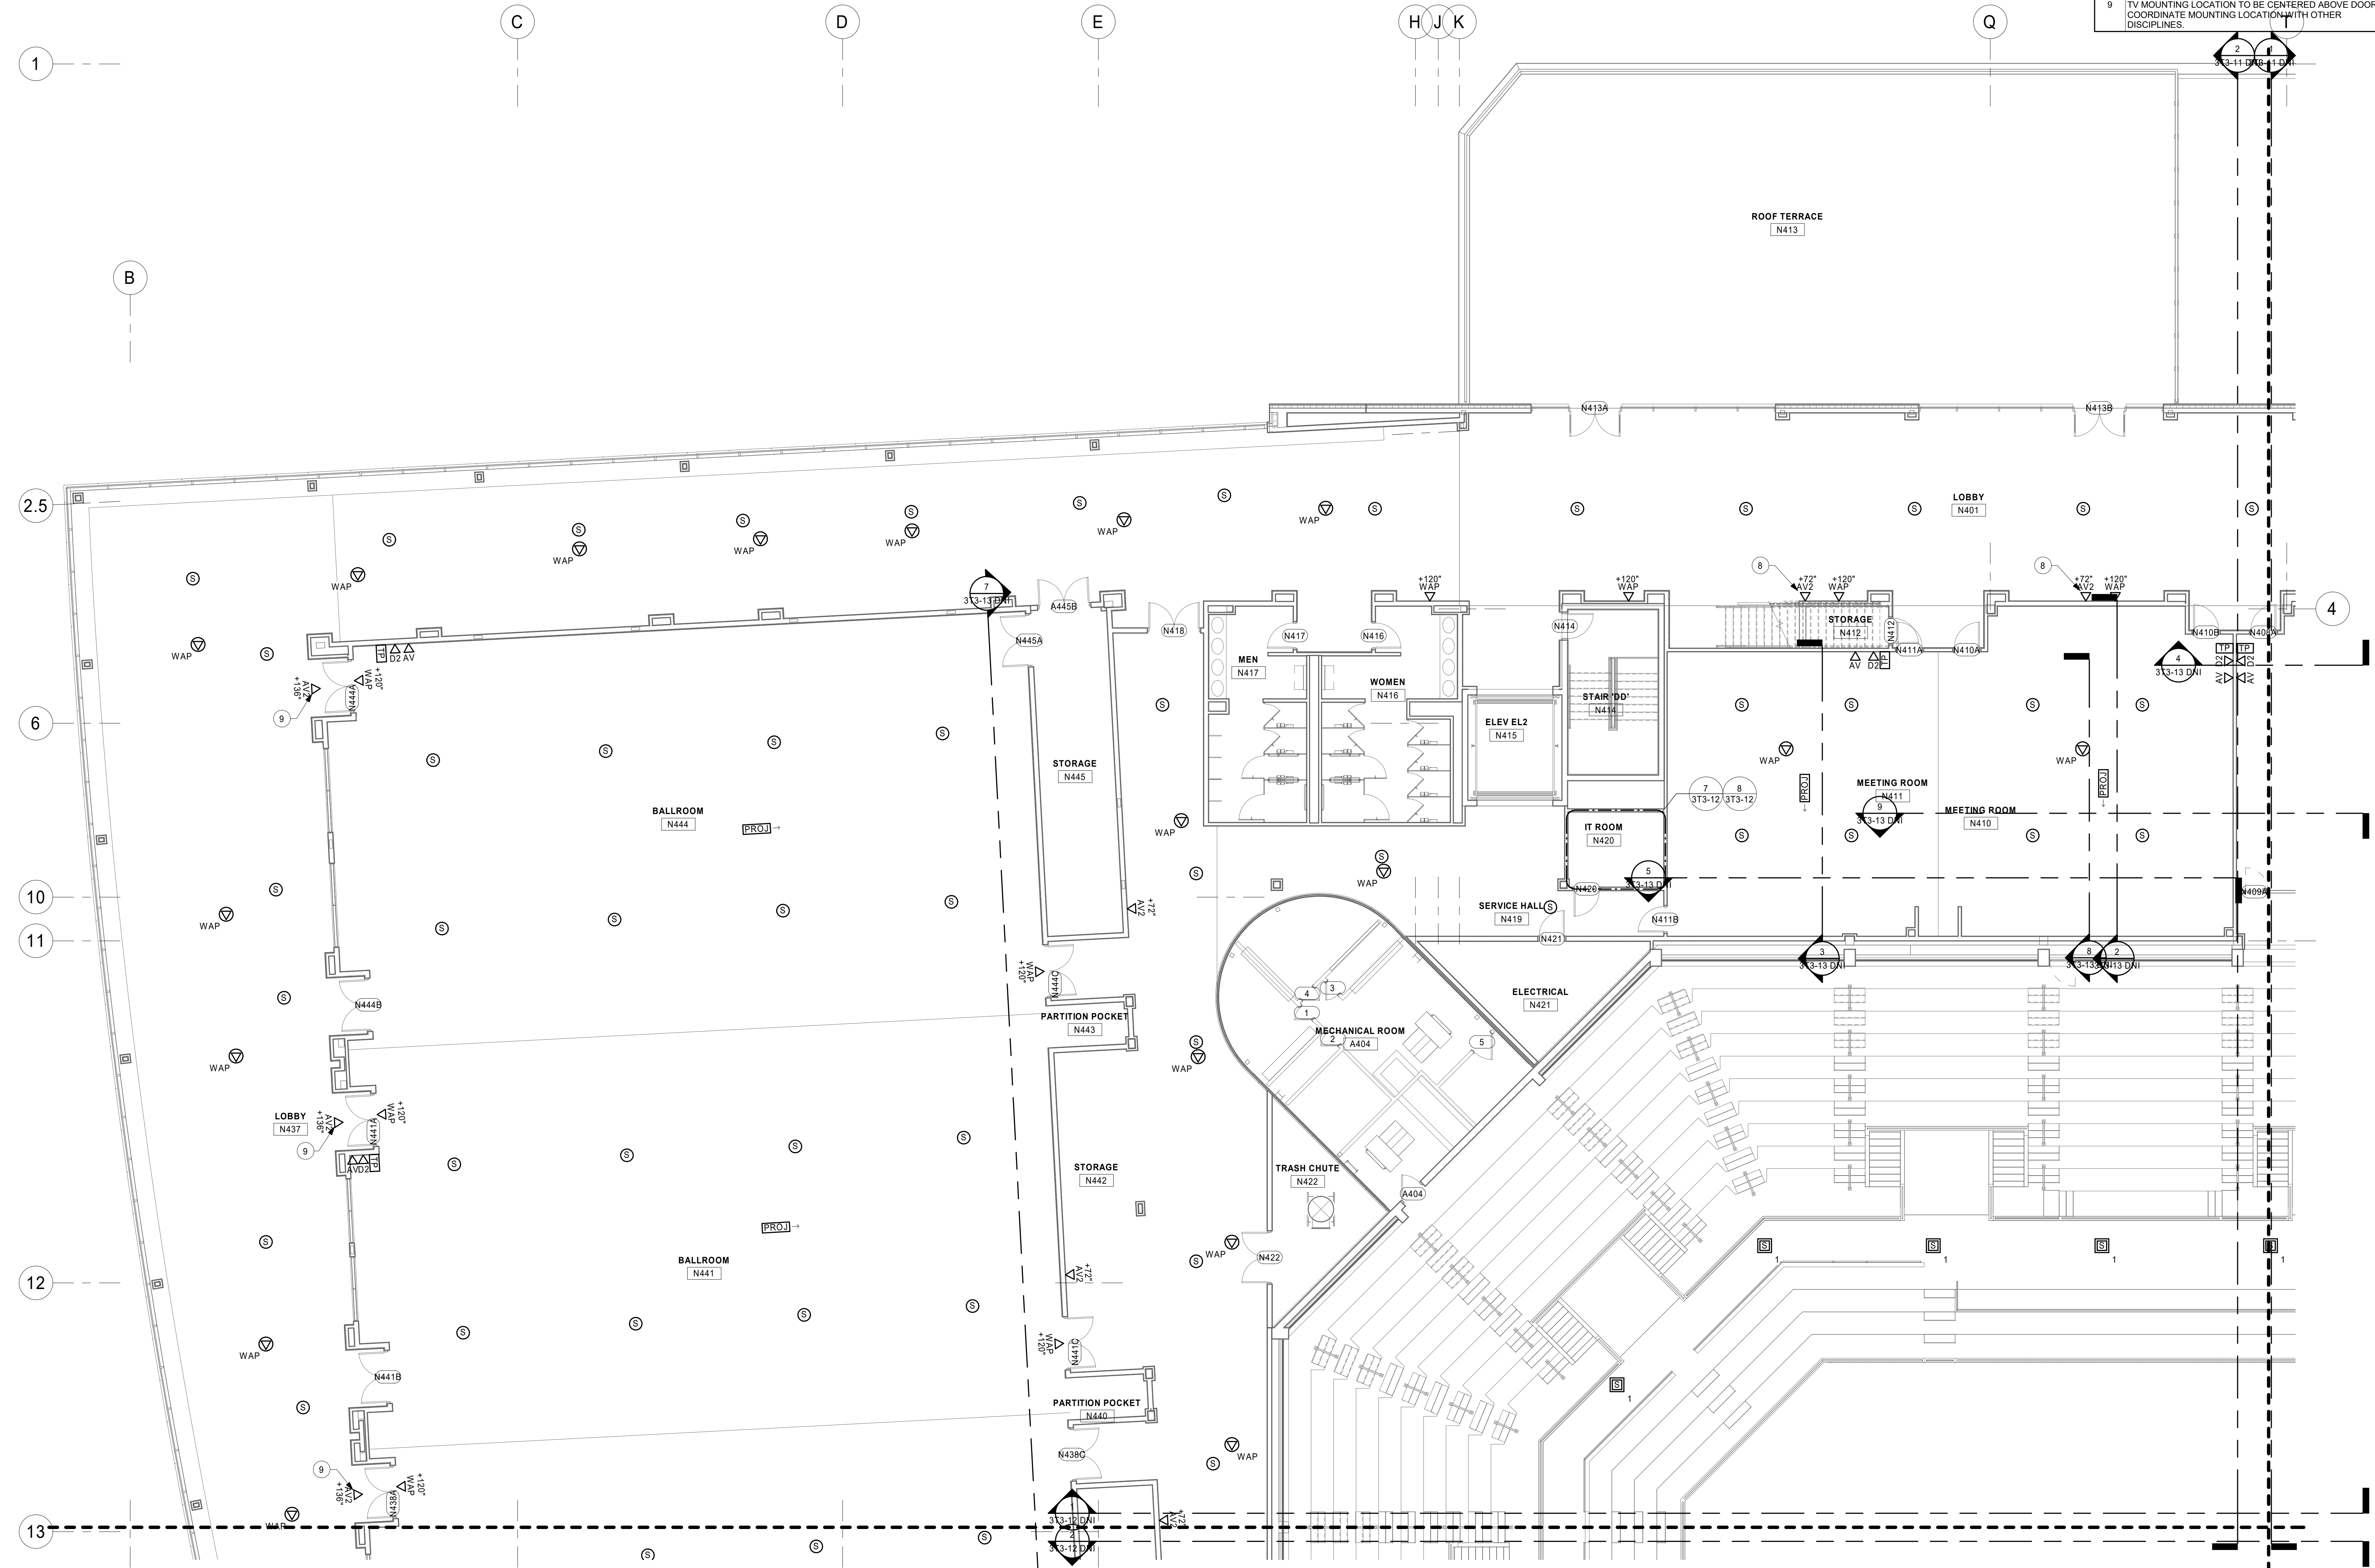


1 BALLROOM FLOOR TECHNOLOGY PLAN - AREA A
1/8" = 1'-0"

SHEET NOTES
1. x
2. x

TECHNOLOGY KEYNOTE LEGEND

KEY	KEYNOTE TEXT
8	TV MOUNTING LOCATION TO BE CENTERED ON WALL. COORDINATE MOUNTING LOCATION WITH OTHER DISCIPLINES.
9	TV MOUNTING LOCATION TO BE CENTERED ABOVE DOOR. COORDINATE MOUNTING LOCATION WITH OTHER DISCIPLINES.

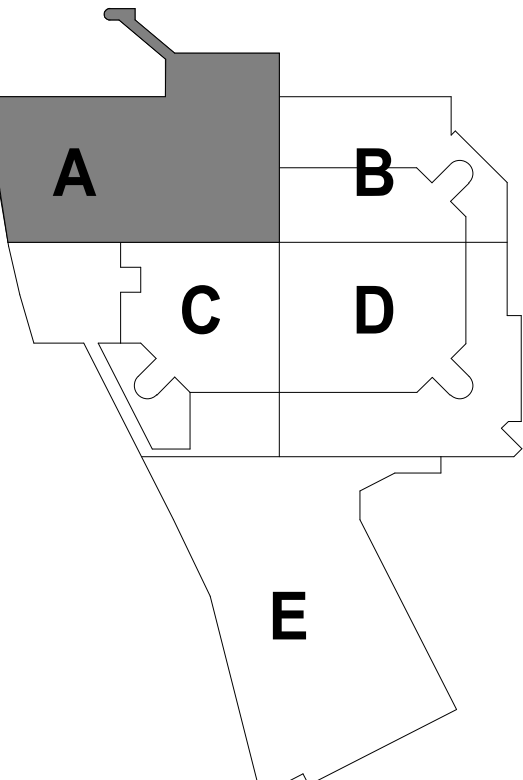

KEYPLAN

THIS DOCUMENT IS THE PROPERTY OF I & S GROUP, INC. AND MAY NOT BE USED, COPIED OR DUPLICATED WITHOUT PRIOR WRITTEN CONSENT.

PROJECT

LA CROSSE
CENTER
EXPANSION

LA CROSSE WISCONSIN

REVISION SCHEDULE		
DATE	DESCRIPTION	BY

PROJECT NO.	16-19990
FILE NAME	19990 Tech R18.rvt
DRAWN BY	KCS
DESIGNED BY	ER
REVIEWED BY	MDN
ORIGINAL ISSUE DATE	MM/DD/YYYY
CLIENT PROJECT NO.	


TITLE

BALLROOM FLOOR
TECHNOLOGY -
AREA A

SHEET


3T2-13A

PRELIMINARY NOT FOR CONSTRUCTION

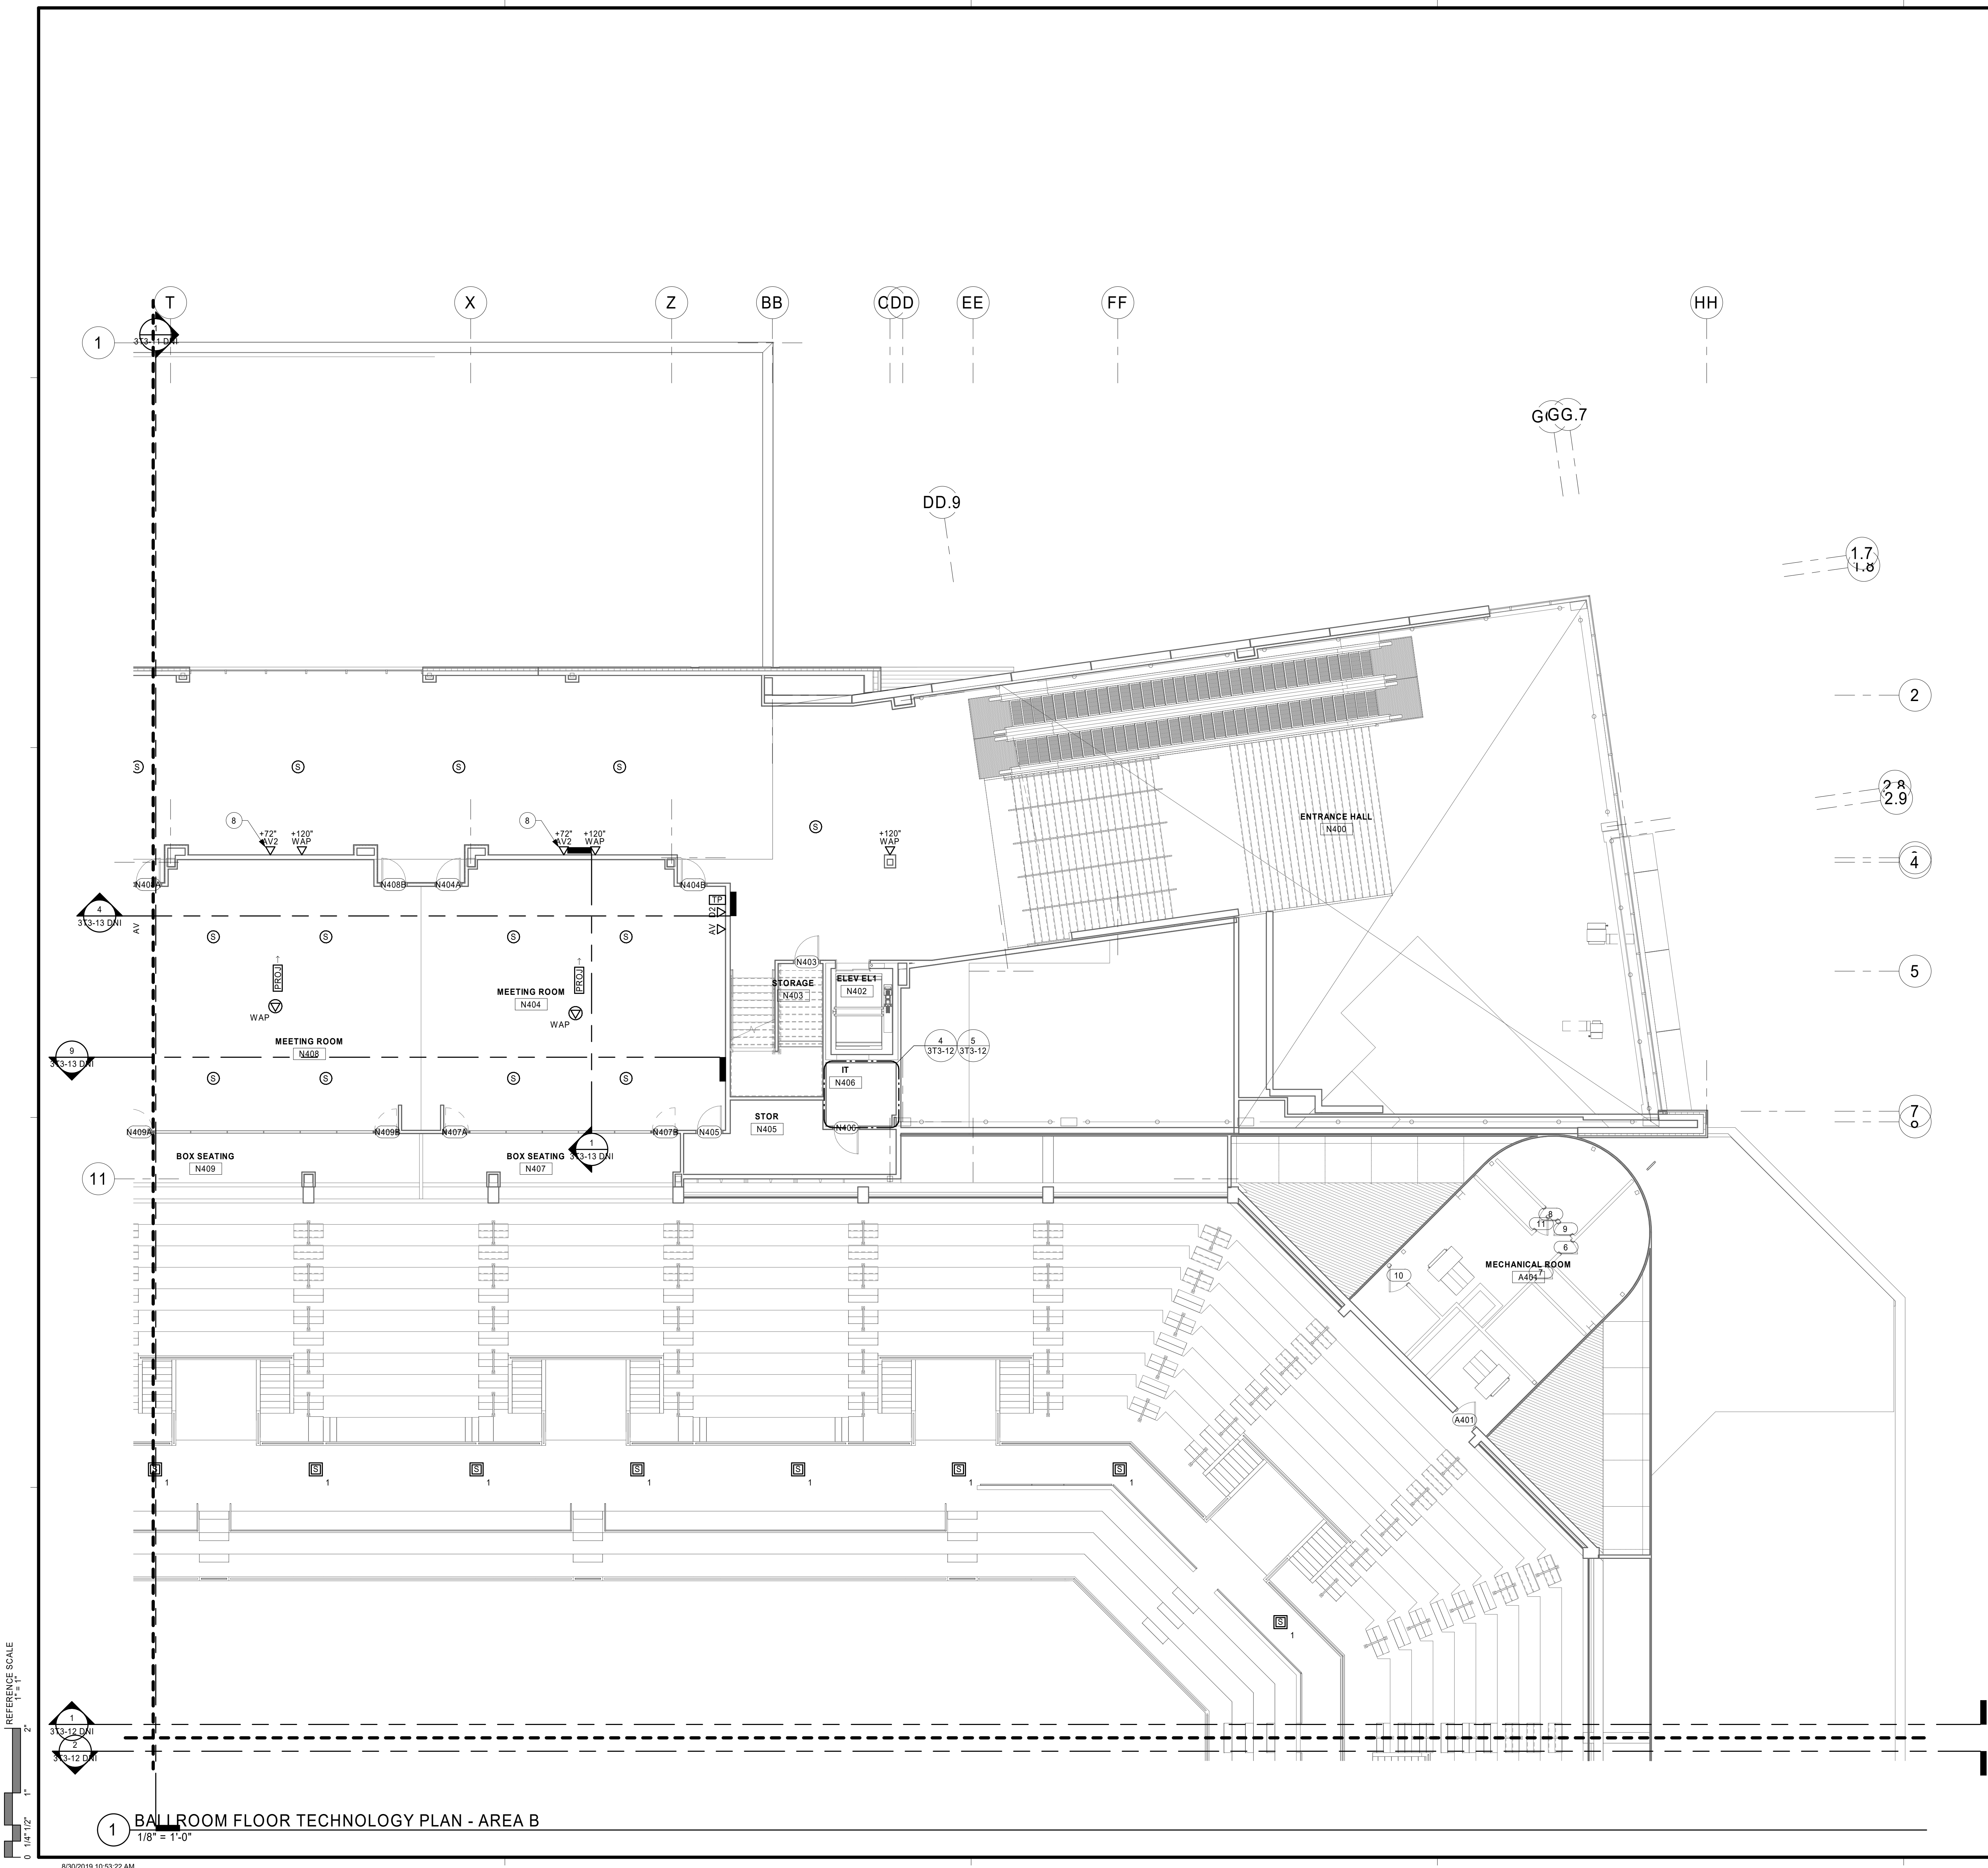

SHEET NOTES	
1.	x
2.	x

TECHNOLOGY KEYNOTE LEGEND	
KEY	KEYNOTE TEXT
8	TV MOUNTING LOCATION TO BE CENTERED ON WALL. COORDINATE MOUNTING LOCATION WITH OTHER DISCIPLINES.

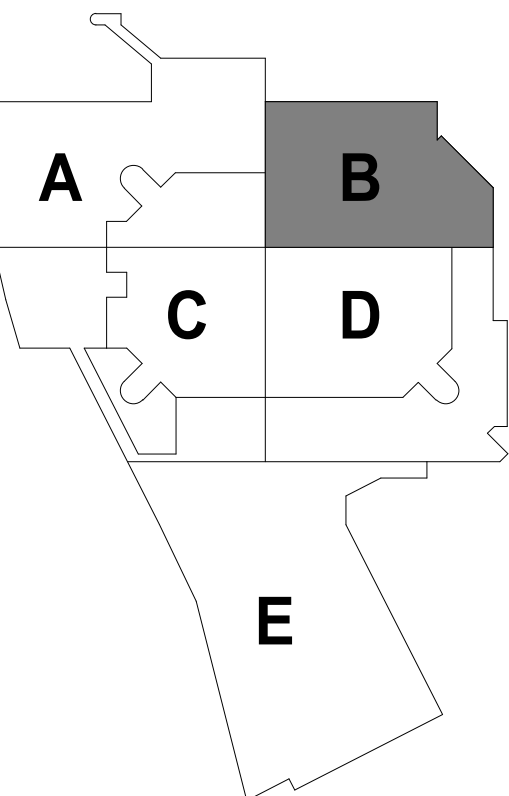

KEYPLAN

THIS DOCUMENT IS THE PROPERTY OF I & S GROUP, INC. AND MAY NOT BE USED, COPIED OR DUPLICATED WITHOUT PRIOR WRITTEN CONSENT.

PROJECT

LA CROSSE
CENTER
EXPANSION

LA CROSSE WISCONSIN

REVISION SCHEDULE		
DATE	DESCRIPTION	BY

PROJECT NO.	16-19990
FILE NAME	19990 Tech R18.rvt
DRAWN BY	KCS
DESIGNED BY	ER
REVIEWED BY	MDN
ORIGINAL ISSUE DATE	MM/DD/YYYY
CLIENT PROJECT NO.	

TITLE

BALLROOM FLOOR
TECHNOLOGY -
AREA B

SHEET

3T2-13B

REFERENCE SCALE
1" = 1'-0"
0 1/4" 1/2" 1" 2"

1 BALLROOM FLOOR TECHNOLOGY PLAN - AREA B
1/8" = 1'-0"



8/26/2019 10:53:22 AM

PRELIMINARY NOT FOR CONSTRUCTION PRELIMINARY NOT FOR CONSTRUCTION




SHEET

3T2-13C

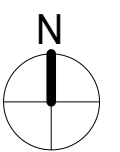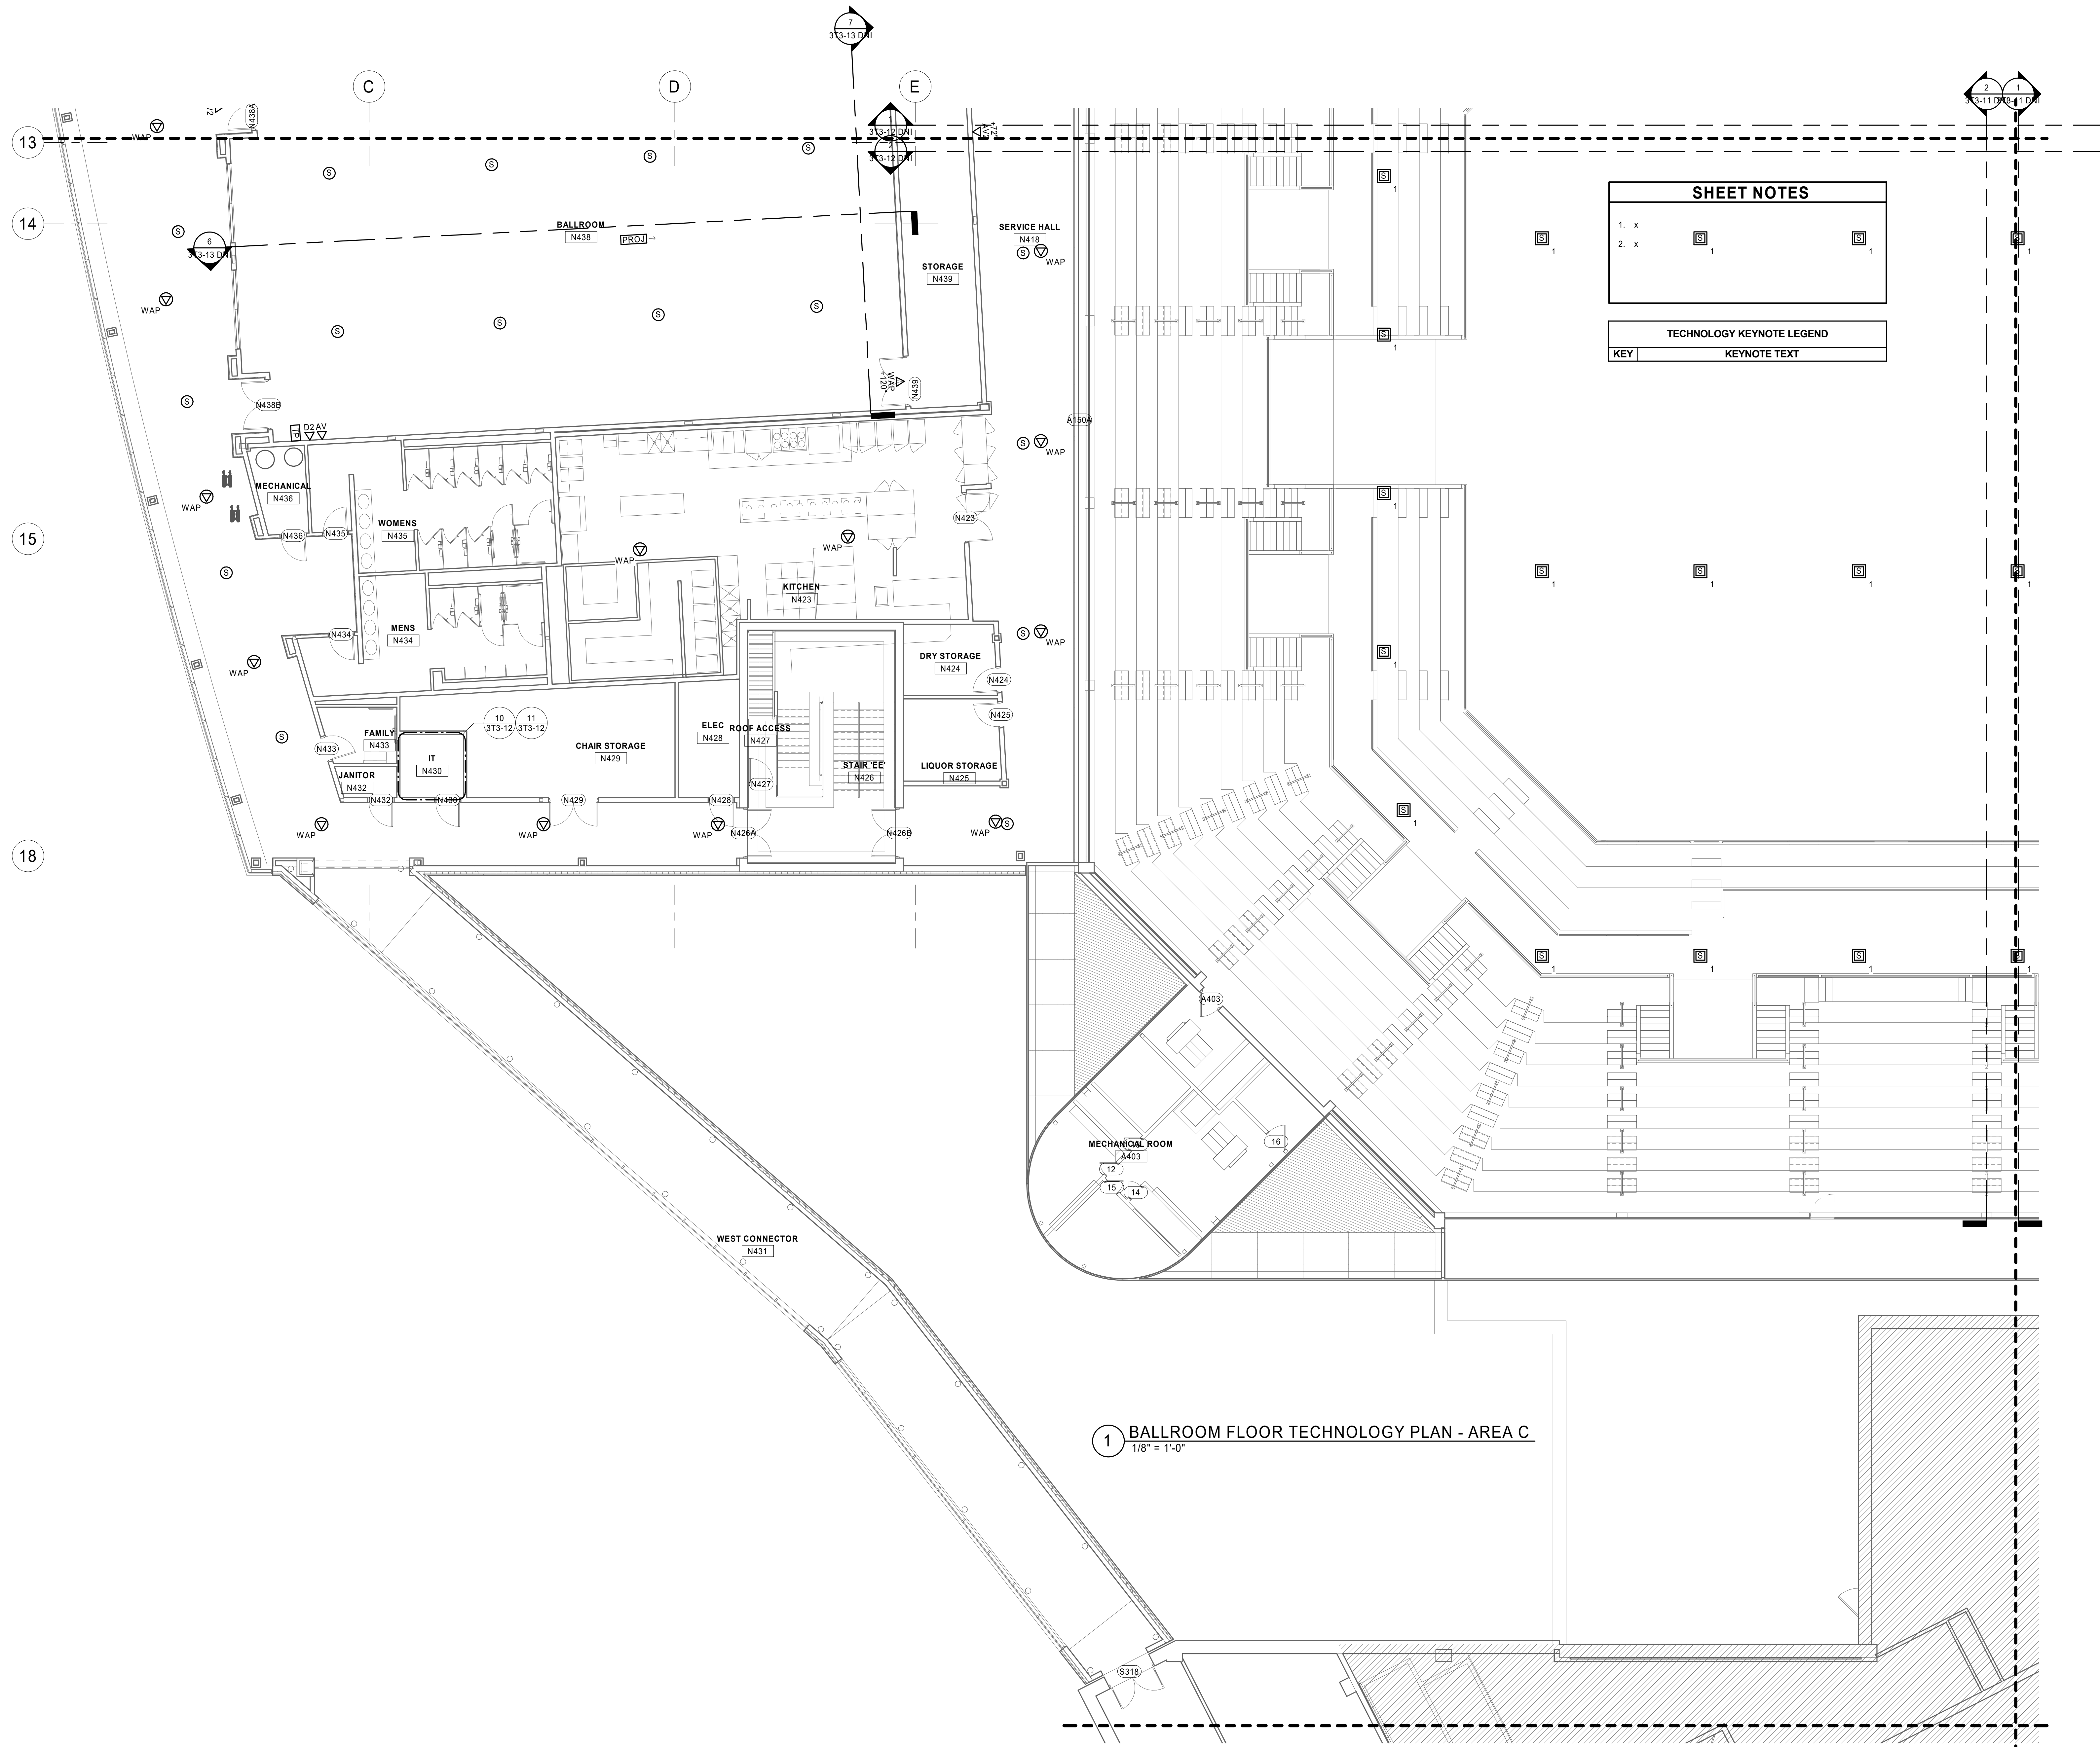

REFERENCE SCALE
0 1/4" 1/2" 1" 2"

1 BALLROOM FLOOR TECHNOLOGY PLAN - AREA D
1/8" = 1'-0"

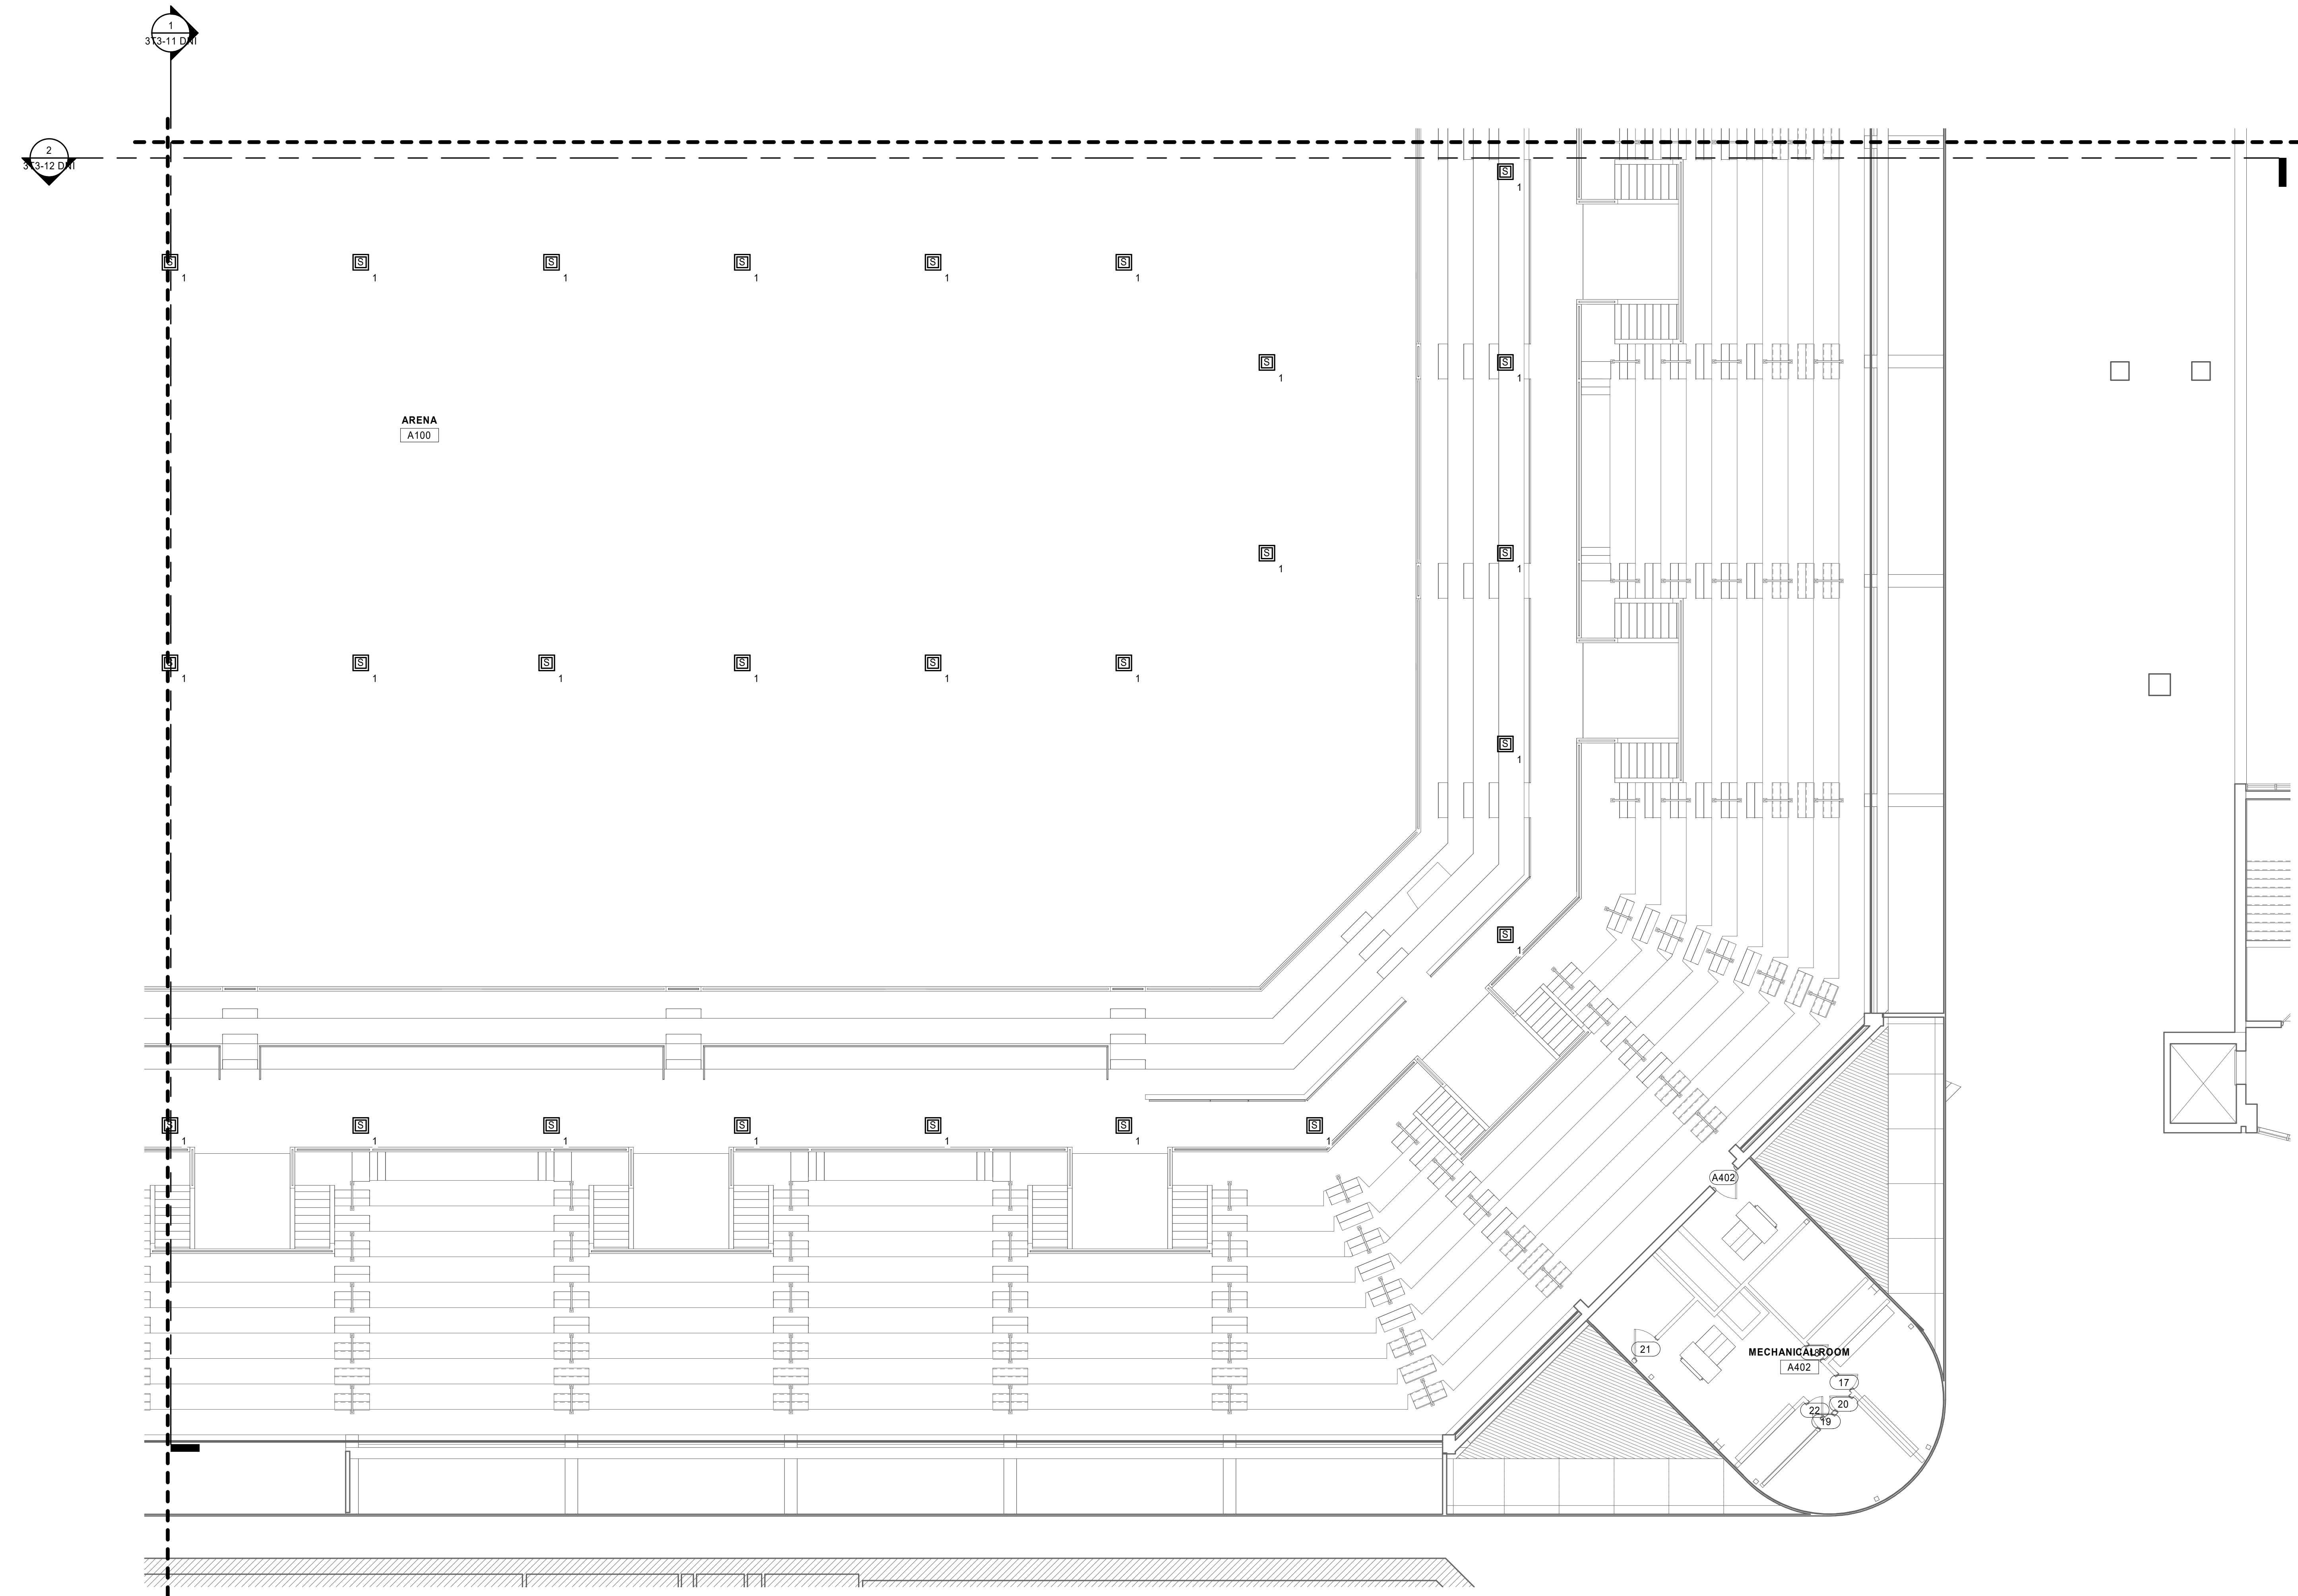


SHEET NOTES

- x
- x

TECHNOLOGY KEYNOTE LEGEND

KEY	KEYNOTE TEXT
-----	--------------

ISG

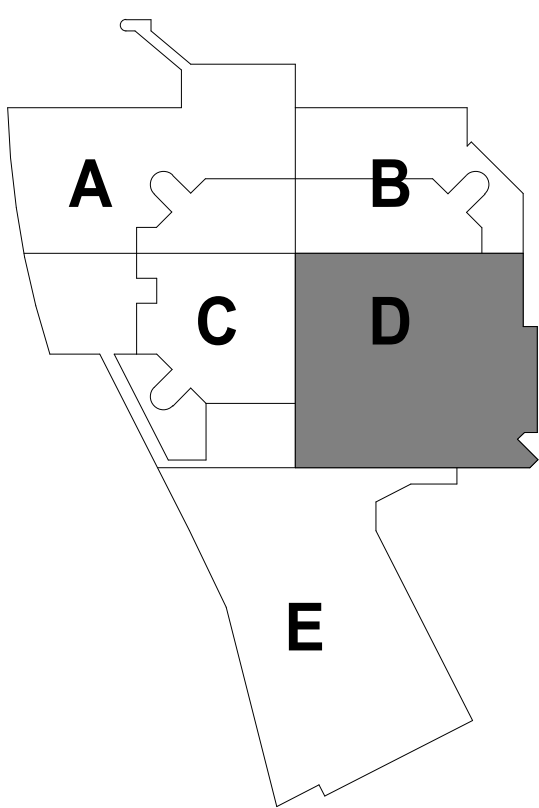

KEYPLAN

THIS DOCUMENT IS THE PROPERTY OF I & S GROUP, INC. AND MAY NOT BE USED, COPIED OR DUPLICATED WITHOUT PRIOR WRITTEN CONSENT.

PROJECT

LA CROSSE
CENTER
EXPANSION

LA CROSSE

WISCONSIN

REVISION SCHEDULE

DATE	DESCRIPTION	BY

PROJECT NO.	16-19990
FILE NAME	19990 Tech R18.rvt
DRAWN BY	KCS
DESIGNED BY	ER
REVIEWED BY	MDN
ORIGINAL ISSUE DATE	MM/DD/YYYY
CLIENT PROJECT NO.	

TITLE

BALLROOM FLOOR
TECHNOLOGY -
AREA D

SHEET

3T2-13D


PRELIMINARY NOT FOR CONSTRUCTION PRELIMINARY NOT FOR CONSTRUCTION




PRELIMINARY NOT FOR CONSTRUCTION

SHEET NOTES	
1.	x
2.	x

TECHNOLOGY KEYNOTE LEGEND	
KEY	KEYNOTE TEXT
8	TV MOUNTING LOCATION TO BE CENTERED ON WALL. COORDINATE MOUNTING LOCATION WITH OTHER DISCIPLINES.

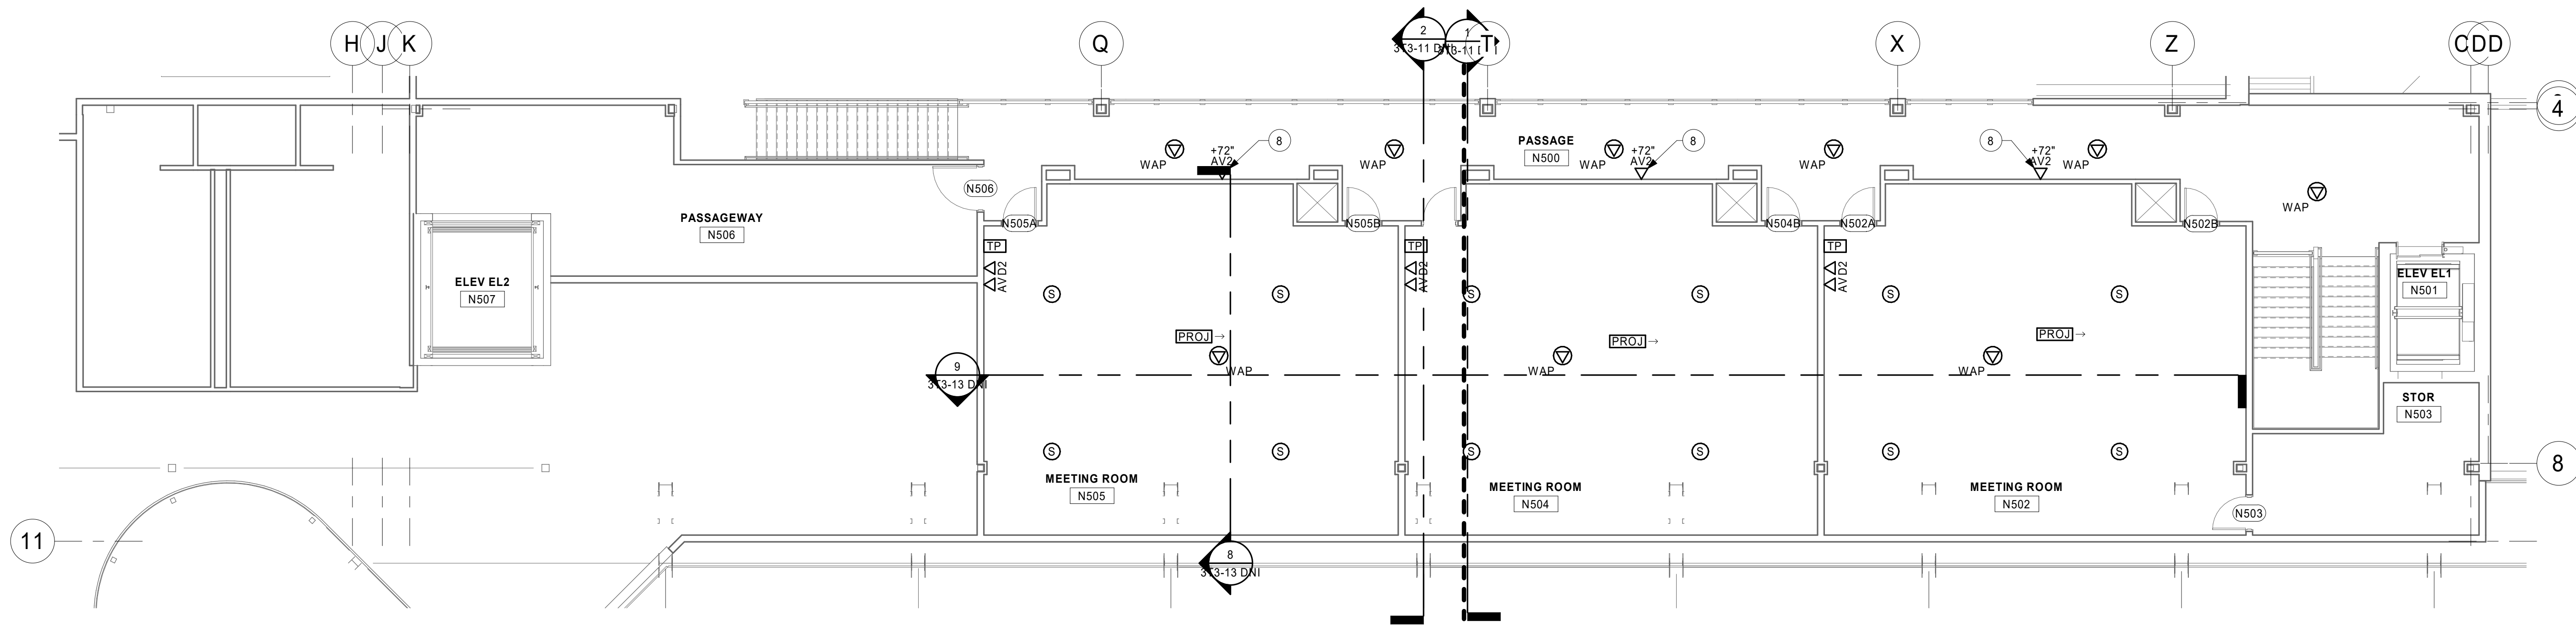

1 MEETING MEZZANINE TECHNOLOGY PLAN
1/8" = 1'-0"

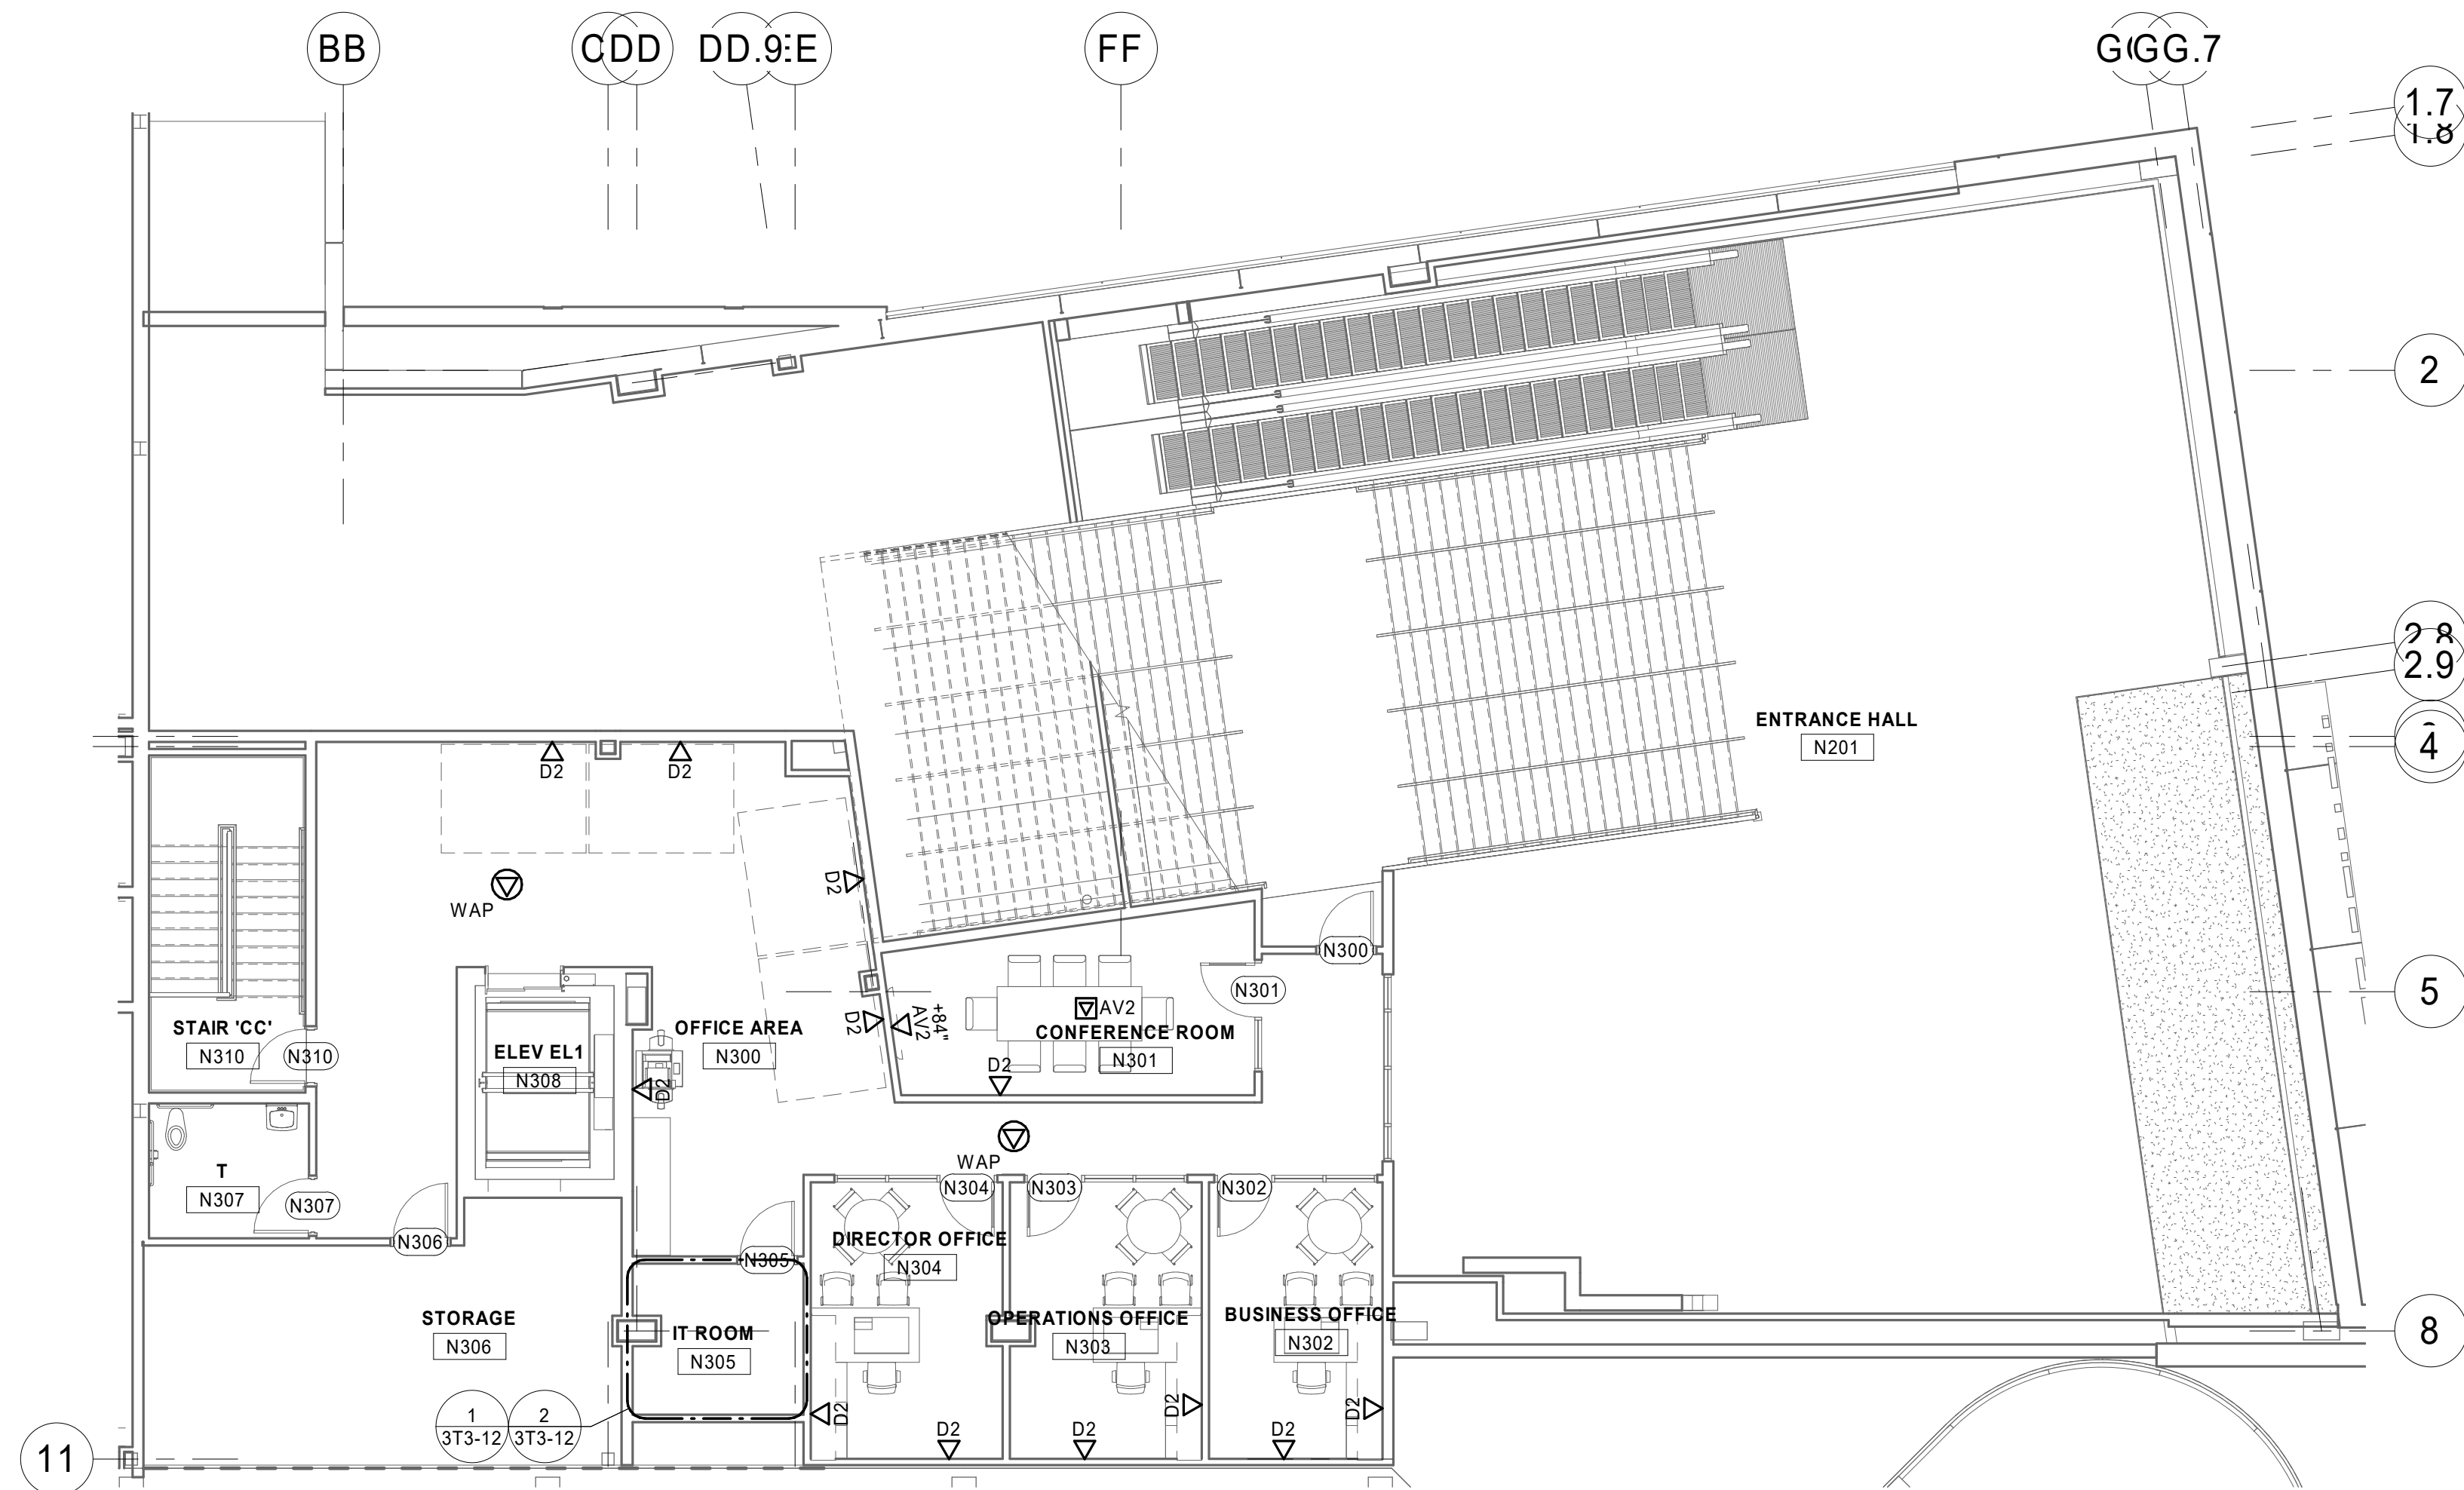

2 OFFICE MEZZANINE - AREA B
1/8" = 1'-0"

THIS DOCUMENT IS THE PROPERTY OF I & S GROUP, INC. AND MAY NOT BE USED, COPIED OR DUPLICATED WITHOUT PRIOR WRITTEN CONSENT.

PROJECT

LA CROSSE CENTER EXPANSION

LA CROSSE

WISCONSIN

REVISION SCHEDULE		
DATE	DESCRIPTION	BY

PROJECT NO.	16-19990
FILE NAME	19990 Tech R18.rvt
DRAWN BY	KCS
DESIGNED BY	ER
REVIEWED BY	MDN
ORIGINAL ISSUE DATE	MM/DD/YYYY
CLIENT PROJECT NO.	

TITLE

MEETING MEZZANINE LEVEL TECHNOLOGY PLANS

SHEET

3T2-14

REFERENCE SCALE
0 1/4" 1/2" 1" 2"

8/30/2019 10:53:58 AM

TECHNOLOGY SYMBOLS	
	ACCS-00
	AC-CR-01
	AV-PROJ-01
	SC-TP-07
	PA-LS-01
	PA-LS-02
	PA-LS-03
	SC-IO-WALL
	SC-IO-FB
	SC-IO-CLG
	CAMERA

TECHNOLOGY SCHEDULE				
DEVICE	DESCRIPTION	MANUFACTURER	PART#	COMMUNICATION NOTES
AC-ACS-00	ACCESS CONTROLLED DOOR			ACCESS CONTROLLED DOOR. PROVIDED PATHWAY WITHIN WALL AND DOOR FRAME FOR ELECTRONIC LOCKSET, DOOR POSITION SWITCH, REQUEST TO EXIT AND CARD READER. PROVIDE DOUBLE-GANG BACKBOX ABOVE SECURE SIDE CEILING WITH 1" CONDUIT TO ACCESSIBLE CEILING. ACCESS CONTR
AC-CR-01	CARD READER	HID	PROXPOINT PLUS	PROXIMITY CARD READER FOR ACCESS CONTROLLED DOOR.
AV-AMP-01	POWER AMPLIFIER	CROWN	DCI 4 1250DA	
AV-CTR-01	AV CONTROLLER	CRESTRON	CP3	1RU RACK MOUNTED CONTROL PROCESSOR FOR AV SYSTEMS.
AV-DIR-80	DIGITALMEDIA DIRECTOR	CRESTRON	DM-XIO-DIR-80	AV OVER IP NETWORK MANAGER AND MATRIX SWITCHER FOR ENCODERS/DECODERS.
AV-DSP-128	12X8 DIGITAL SIGNAL PROCESSOR	CRESTRON	DSP-1283	DIGITAL SIGNAL PROCESSOR, 12 INPUT, 8 OUTPUT, 32X32 DANTE INTERFACE.
AV-NVX-08	DIGITALMEDIA CHASSIS	CRESTRON	DMF-CI-8	2RU CHASSIS FOR STORING UP TO 8 DIGITALMEDIA NVX CARDS PER CHASSIS.
AV-NVX-352C	DIGITALMEDIA ENCODER/DECODER CARD	CRESTRON	DM-NVX-352C	RACK MOUNTED AV OVER IP ENCODER/DECODER.
AV-NVX-D30C	NETWORK VIDEO DECODER	CRESTRON	DM-NVX-D30C	NETWORK OVER IP DECODER.
AV-PROJ-01	PROJECTOR	DPI	E-VISION LASER 8500	VIDEO PROJECTOR, WUXGA, 8,500 LUMENS, HDMI AND 3GSDI INPUTS. PROVIDE LENS AS NEEDED FOR THROW DISTANCE AS SHOWN.
AV-PROJ-SCN	PROJECTION SCREEN	DA-LITE	MOTORIZED SCENIC ROLLAR 22.5x30'	PROVIDE RETRACTABLE SCREEN, ALL MOUNTING HARDWARE AND CONNECTION TO CONTROL SYSTEM.
AV-RMS-01	RACK-MOUNT SHELF	CHATSWORTH PRODUCTS INC	40974-719 OR EQUAL	1RU RACK MOUNTED SHELF. VENTILATED WITH MULTIPLE TIE-DOWN POINTS. PROVIDE QUANTITY NECESSARY FOR MOUNTING OF ALL HDMI EXTENDER TRANSMITTERS AND RECEIVERS.
AV-RX-01	HDMI RECEIVER	CRESTRON	HD-RX-101-C-E	SURFACE MOUNT HDMI OVER IP RECEIVER. CONNECT TO RACK MOUNTED AV-NVX-352C, AND PAIR WITH AV-TX-W1 LOCATED AT SOURCE LOCATION.
AV-RX-W1	HDMI RECEIVER - WALL OUTLET	CRESTRON	HD-RX-101-C-1G-E	HDMI EXTENDER RECEIVER, DECORA OUTLET FORM FACTOR.
AV-TP-07	CONTROL TOUCH PANEL	CRESTRON	TSW-760-NC-B-S	TOUCHSCREEN CONTROL PANEL. PROVIDE WITH ALL NECESSARY CABLING, HARDWARE, CONNECTION AND PROGRAMMING. PROVIDE WITH APPROPRIATE WALL OR DESKTOP MOUNTING ACCESSORIES FOR LOCATION.
AV-TX-01	HDMI TRANSMITTER	CRESTRON	HD-TX-101-C-E	SURFACE MOUNT HDMI OVER IP TRANSMITTER. CONNECT TO RACK MOUNTED AV-NVX-D30C OR AV-NVX-352C, AND PAIR WITH AV-RX-01 OR AV-RX-W1 LOCATED AT DISPLAY LOCATION.
AV-TX-W1	HDMI TRANSMITTER - WALL OUTLET	CRESTRON	HD-TX-101-C-1G-E	HDMI EXTENDER TRANSMITTER, DECORA OUTLET FORM FACTOR.
AV-WB-04	WALL BOX - RECESSED	LEGRAND	EF5B4	EVOLUTION SERIES, 4-GANG RECESSED WALL BOX. PROVIDE FOR EACH TV LOCATION. COORDINATE MOUNTING OF POWER, DATA, AND AV IN AVAILABLE GANGS.
PA-LS-01	LOUDSPEAKER	COMMUNITY	R.5	
PA-LS-02	LOUDSPEAKER	COMMUNITY	R.5COAX	
PA-LS-03	LOUDSPEAKER - CEILING	COMMUNITY	D10	8" CEILING SPEAKER. CONTRACTOR TO VERIFY LOUID-SPEAKER CATALOG NUMBER AND INSTALLATION REQUIREMENTS PRIOR TO ORDERING. PROVIDE MANUFACTURER RECOMMENDED CABLING BASED ON POWER AND DISTANCE OF FINAL CONFIGURATION.
SC-CAB-01	EQUIPMENT CABINET	CHATSWORTH PRODUCTS INC	11840-X24	EQUIPMENT CABINET, WALL MOUNTED, 12RU (24" H), 24" D, 24" W, 300LB LOAD CAPACITY.
SC-CT-12	CABLE TRAY	CHATSWORTH PRODUCTS INC	84821-512	WIRE BASKET CABLE TRAY 12"x4". PROVIDE ALL NECESSARY HARDWARE AND MOUNTING. COORDINATE FINAL MOUNTING WITH OTHER TRADES.
SC-ER-01	EQUIPMENT RACK	CHATSWORTH PRODUCTS INC	UNIVERSAL RACK	2-POST EQUIPMENT RACK SUPPORTING STANDARD 19" PANEL MOUNTING. PROVIDE VERTICAL CABLE MANAGEMENT (SC-VWM-06) AS INDICATED ON PLANS.
SC-FDC-01	FIBER DISTRIBUTION CABINET	CORNING	CCH-01U	FIBER DISTRIBUTION CABINET, 1RU. PROVIDE ADAPTER PANELS AS NECESSARY.
SC-GND-01	GROUNDING BUSBAR	CHATSWORTH PRODUCTS INC	13622-012	TELECOMMUNICATIONS GROUNDING BUSBAR.
SC-HWM-01	HORIZONTAL WIRE MANAGER	CHATSWORTH PRODUCTS INC	13930-701	HORIZONTAL CABLE MANAGER, 1 RACK UNIT, T-SHAPED CABLE GUIDES (FINGERS), SNAP-ON COVER THAT CAN BE HINGED FROM TOP OR BOTTOM.
SC-HWM-02	HORIZONTAL WIRE MANAGER	CHATSWORTH PRODUCTS INC	13930-702	HORIZONTAL CABLE MANAGER, 2 RACK UNIT, T-SHAPED CABLE GUIDES (FINGERS), SNAP-ON COVER THAT CAN BE HINGED FROM TOP OR BOTTOM.
SC-IO-CLG	INFORMATION OUTLET - CEILING			REFER TO INFORMATION OUTLET SCHEDULE FOR ADDITIONAL INFORMATION.
SC-IO-FB	INFORMATION OUTLET - FLOOR BOX			REFER TO ELECTRICAL PLANS AND INFORMATION OUTLET SCHEDULE FOR ADDITIONAL INFORMATION.
SC-IO-WALL	INFORMATION OUTLET - WALL			REFER TO INFORMATION OUTLET SCHEDULE FOR ADDITIONAL INFORMATION.
SC-LR-12	12" LADDER RACK	CHATSWORTH PRODUCTS INC	10250-X12	PROVIDE ALL NECESSARY ACCESSORIES FOR PROPER INSTALLATION AND TRANSITIONS FOR A COMPLETE SYSTEM.
SC-MPP-24	MODULAR PATCH PANEL			24-PORT MODULAR PATCH PANEL. REFER TO SPECIFICATIONS FOR ADDITIONAL INFORMATION.
SC-MPP-48	MODULAR PATCH PANEL			48-PORT MODULAR PATCH PANEL. REFER TO SPECIFICATIONS FOR ADDITIONAL INFORMATION.
SC-SWI-48	NETWORK SWITCH - 48 PORT	EXTREME	X440-G2-48P-10GE4	NETWORK SWITCH, MANAGED, 48-PORT GBE, POE, FULL DUPLEX, ENERGY EFFICIENT ETHERNET.
SC-UPS-01	UNINTERRUPTABLE POWER SUPPLY	EATON	9PX MODEL 6000	UNINTERRUPTIBLE POWER SUPPLY, RACK MOUNT, 1-HOUR RUN TIME.
SC-VWM-06	VERTICAL WIRE MANAGER	CHATSWORTH PRODUCTS INC	13912-703	RACK MOUNTED VERTICAL CABLE MANAGEMENT FOR 2-POST EQUIPMENT RACKS. VELOCITY SERIES, DOUBLE SIDED TO MATCH RACK HEIGHT.
VS-NVR-32	NETWORK VIDEO RECORDER	HANVHA	XRN-3010	NETWORK VIDE RECORDER, 64-CHANNELS, H.264/H.265/MJPEG, SUPPORTS CAMERA RESOLUTION UP TO 12MP, 300FPS RECORDING THROUGHPUT, UP TO (8) 6TB HDD'S. PROVIDE 30 DAYS OF STORED VIDEO FOR ALL CAMERAS.



THIS DOCUMENT IS THE PROPERTY OF I & S GROUP, INC. AND MAY NOT BE USED, COPIED OR DUPLICATED WITHOUT PRIOR WRITTEN CONSENT.

PROJECT

LA CROSSE
CENTER
EXPANSION

LA CROSSE WISCONSIN

REVISION SCHEDULE		
DATE	DESCRIPTION	BY

PROJECT NO.	16-19990
FILE NAME	19990 Tech R18.rvt
DRAWN BY	KCS
DESIGNED BY	ER
REVIEWED BY	MDN
ORIGINAL ISSUE DATE	MM/DD/YYYY
CLIENT PROJECT NO.	

TITLE

TECHNOLOGY
SCHEDULES

SHEET

3T5-21

PRELIMINARY NOT FOR CONSTRUCTION