



RIVER VALLEY ARCHITECTS
33300 Birch Street, Suite 1A | Eau Claire, WI 54703

- THE CONTRACTOR SHALL BE RESPONSIBLE FOR VERIFYING ALL EXISTING CONDITIONS INCLUDING LOCATIONS OF EXISTING UTILITIES AND EASEMENTS.
- ALL WORK SHALL BE IN COMPLIANCE WITH LOCAL, STATE AND NATIONAL CODES FOR RESPECTIVE TRADES.
- DO NOT SCALE DRAWINGS.
- THE CONTRACTOR SHALL VERIFY ALL DIMENSIONS.
- DRAWINGS AND SPECIFICATIONS ARE TO BE CONSIDERED AS SUPPLEMENTING EACH OTHER. WORK SPECIFIED, BUT NOT SHOWN, OR SHOWN, BUT NOT SPECIFIED SHALL BE PERFORMED AS THOUGH MENTIONED IN BOTH SPECIFICATIONS AND DRAWINGS.
- THERE IS SOME OVERLAP BETWEEN ARCHITECTURAL AND STRUCTURAL PLANS. REVIEW COMPLETE PLANS FOR ARCHITECTURAL/STRUCTURAL WORK.

OWNER:
DAIRYLAND POWER COOPERATIVE
3200 EAST AVENUE S.
LA CROSSE, WI 54601
PHONE: 608.788.4000

ARCHITECT:
RIVER VALLEY ARCHITECTS, INC.
3300 BIRCH STREET, SUITE 1A
EAU CLAIRE, WI 54703
PHONE: 715.832.0875

CIVIL DESIGN:
AEC
1360 INTERNATIONAL DRIVE
EAU CLAIRE, WI 54703
PHONE: 715.552.0330

ELECTRICAL DESIGN BUILD CONTRACTOR:
TD PADESKY ELECTRIC INC.
224 CUNNINGHAM STREET
LA CROSSE, WI 54603
PHONE: 608.788.7500

PLUMBING & HVAC DESIGN BUILD CONTRACTOR:
MODERN MECHANICAL
CONTRACTORS
1303 WESTON STREET
PHONE: 608.783.0730

GENERAL CONTRACTOR:
FOWLER & HAMMER
313 MONITOR STREET
LA CROSSE, WI 54603
PHONE: 608.782.6849

STRUCTURAL DESIGN:
ERA
3410 OAKWOOD MALL DRIVE
EAU CLAIRE, WI 54701
PHONE: 715.552.5336

PROJECT LOCATION:
EAST AVENUE S.
LA CROSSE, WI 54601



ARCHITECTURAL

A0.1 TITLE SHEET

GENERAL

A0.2 DRAWING CONVENTIONS

A0.3 CODE PLAN

ARCHITECTURAL

A2.1 FLOOR PLAN

A2.2 DIMENSION PLAN

A2.4 REFLECTED CEILING PLAN

A4.1 INTERIOR ELEVATIONS

A5.1 OPENING SCHEDULES AND DOOR & WINDOW TYPES

A6.2 EXTERIOR ELEVATIONS

A7.1 BUILDING SECTIONS

NOT FOR CONSTRUCTION - SD

DESIGNATION						
DATE						
WARRANT						

DRAWN BY: XXX

PM: LP


JOB NO: 19-049

DATE: 01.29.2020

TITLE SHEET

AO.1

1/27/2020 3:38:17 PM C:\Revit Locals\19-049 DAIRYLAND POWER - PRINT SERVICES adamX2DX2.rvt

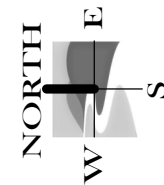

FIRST FLOOR CODE PLAN

$$1/8'' = 1'-0''$$


CODE PLAN LEGEND

FIRE WALLS:

 2-HOUR FIRE WALL

 3-HOUR FIRE WALL

FIRE BARRIERS:

	1-HOUR FIRE BARRIER
	2-HOUR FIRE BARRIER
	3-HOUR FIRE BARRIER

SMOKE BARRIERS:

SMOKE BARRIER WITH 1-HOUR
FIRE BARRIER CONSTRUCTION

MEANS OF EGRESS:

EGRESS PATH

 EXIT LIGHT

FIRE EXTINGUISHERS:

 FIRE EXTINGUISHER

 FIRE EXTINGUISHER CABINET

PROJECT INFORMATION / CODE DATA

- APPLICABLE CODES:

2015 INTERNATIONAL BUILDING CODE WITH WISCONSIN
AMENDMENTS

ENTIRE BUILDING SHALL COMPLY WITH THE A117.1 ACCESSIBILITY
STANDARD 2009 EDITION

- BUILDING OCCUPANCY:

—

- CONSTRUCTION TYPE:

—

- FIRE PROTECTION:

COMPLETE NFPA 13

- ALLOWABLE HEIGHT AND AREA:

BUILDING AREAS

OCCUPANCY CALCULATIONS

FIRST FLOOR	0
TOTAL OCCUPANT LOAD =	0

EXIT REQUIREMENTS

LEVEL	OCCUPANCY LOAD	EGRESS WIDTH REQUIRED (INCHES)	EGRESS WIDTH PROVIDED (INCHES)
FIRST FLOOR	0	0.0	

PLUMBING FIXTURE COUNTS

FIXTURE	REQUIRED	PROVIDED
WATER CLOSETS (MALE)	0	0
URINALS	0	0
WATER CLOSETS (FEMALE)	0	0
LAVATORIES (MALE)	0	0
LAVATORIES (FEMALE)	0	0
WATER COOLERS	0	0
SERVICE SINKS	1	0



DAIRYLAND POWER COOPERATIVE
PUBLICATION SERVICES
LA CROSSE, WISCONSIN


NOT FOR CONSTRUCTION - SD

[illegible]

DRAWN BY: Author
PM: LP
JOB NO: 19-049
DATE: 01.29.2020

CODE PLAN

A0.3

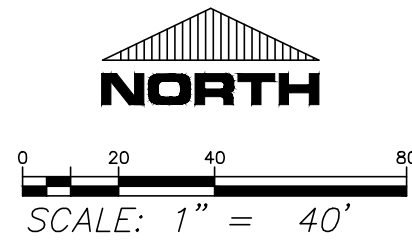

LEGEND

- EXISTING BUILDING
- EXISTING CONCRETE SURFACE
- EXISTING BITUMINOUS SURFACE
- EXISTING GRAVEL SURFACE
- FM --- EXISTING SANITARY FORCE MAIN
- STN --- EXISTING SANITARY SERVICES
- VTR --- EXISTING WATER SERVICES
- SAN --- EXISTING SANITARY SERVICES
- CH --- EXISTING OVERHEAD LINES
- E --- EXISTING UNDERGROUND ELECTRIC
- G --- EXISTING UNDERGROUND GAS
- T --- EXISTING UNDERGROUND TELEPHONE
- < --- EXISTING GUY WIRE
- EXISTING TELEPHONE PEDESTAL
- EXISTING POWER POLE
- TV --- EXISTING UNDERGROUND CABLE
- FO --- EXISTING UNDERGROUND FIBER OPTIC
- EXISTING SANITARY MANHOLE
- EXISTING STORM MANHOLE
- EXISTING CURB INLET
- EXISTING CURB STOP
- EXISTING FIRE HYDRANT
- EXISTING WATER VALVE
- EXISTING UTILITY MANHOLE
- EXISTING CABLE PEDESTAL
- EXISTING GAS METER
- EXISTING FENCE
- EXISTING LIGHT POLE
- EXISTING SANITARY CLEANOUT
- EXISTING CONCRETE BOLLARD
- EXISTING DECIDUOUS TREE
- EXISTING CONIFEROUS TREE
- EXISTING TRAFFIC SIGN
- EXISTING ELECTRIC METER
- EP --- EXISTING ELECTRIC PEDESTAL

CONTROL - 19343			
POINT #	TYPE	NORTHING	EASTING
12	60d SPIKE	118970.742'	452342.508'
13	MAG NAIL	118526.900'	452277.622'
16	MAG NAIL	118492.653'	451651.664'
17	60d SPIKE	118898.242'	451657.890'

BENCHMARK		
BENCHMARK ID	LOCATION	ELEVATION
#1	TOP NUT ON HYDRANT	665.14'
#2	TOP NUT ON HYDRANT	663.50'
#3	TOP NUT ON HYDRANT	659.96'

REAL LAND SURVEYING

1360 INTERNATIONAL DRIVE

EAU CLAIRE, WI 54701

(715) 514-4116



FIELD WORK WAS COMPLETED ON 10/24/19


COPYRIGHT 2013
REAL LAND SURVEYING

CADD No. 19343 TOPO

TOPOGRAPHIC SURVEY

LOCATED IN SECTION 16,
TOWNSHIP 15 NORTH, RANGE 7 WEST,
CITY OF LA CROSSE, LA CROSSE COUNTY, WISCONSIN

FOR: DAIRYLAND POWER

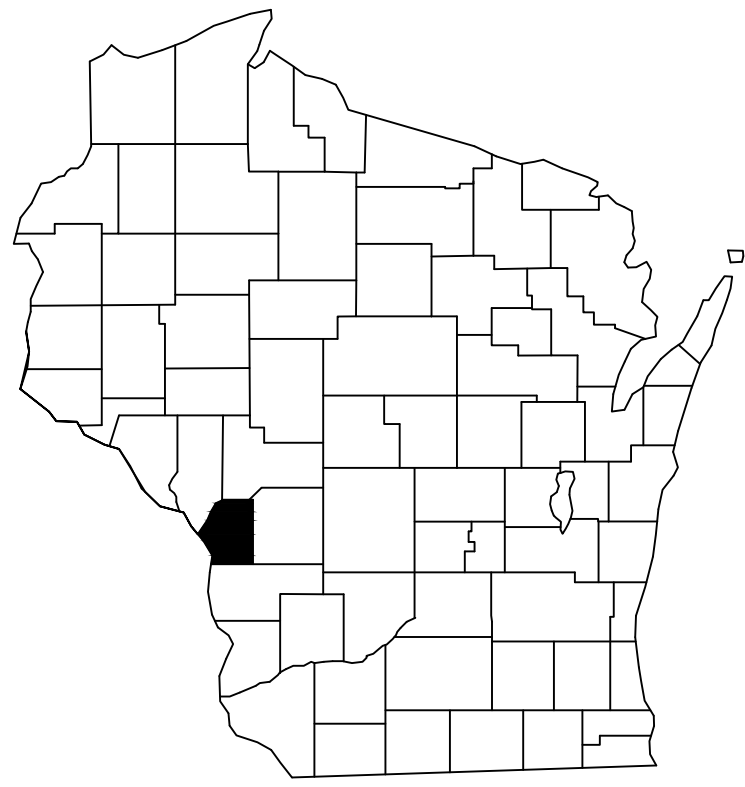

LACROSSE COUNTY




Know what's below.
Call before you dig.

VICINITY MAP

PROJECT LOCATION

CONTACTS

CONTACTS	
DIRECTOR OF ENGINEERING	CITY OF LA CROSSE RANDY TURTENWALD (608) 789-7505
ELECTRIC	DAIRYLAND POWER (608) 223-2014
GAS	XCEL ENERGY (800) 895-4999
TELEPHONE	CENTURYLINK (800) 283-4237
CABLE	CHARTER COMMUNICATIONS (262) 446-9821
SEWER & WATER	CITY OF LA CROSSE, ENGINEERING DEPARTMENT ATTN: RANDY TURTENWALD (608) 789-7505
DIRECTOR OF PLANNING & DEVELOPMENT	CITY OF LA CROSSE JASON GILMAN (608) 789-7362
FIRE DEPT.	CITY OF LA CROSSE CHIEF: KEN GILLIAM (608) 789-7261

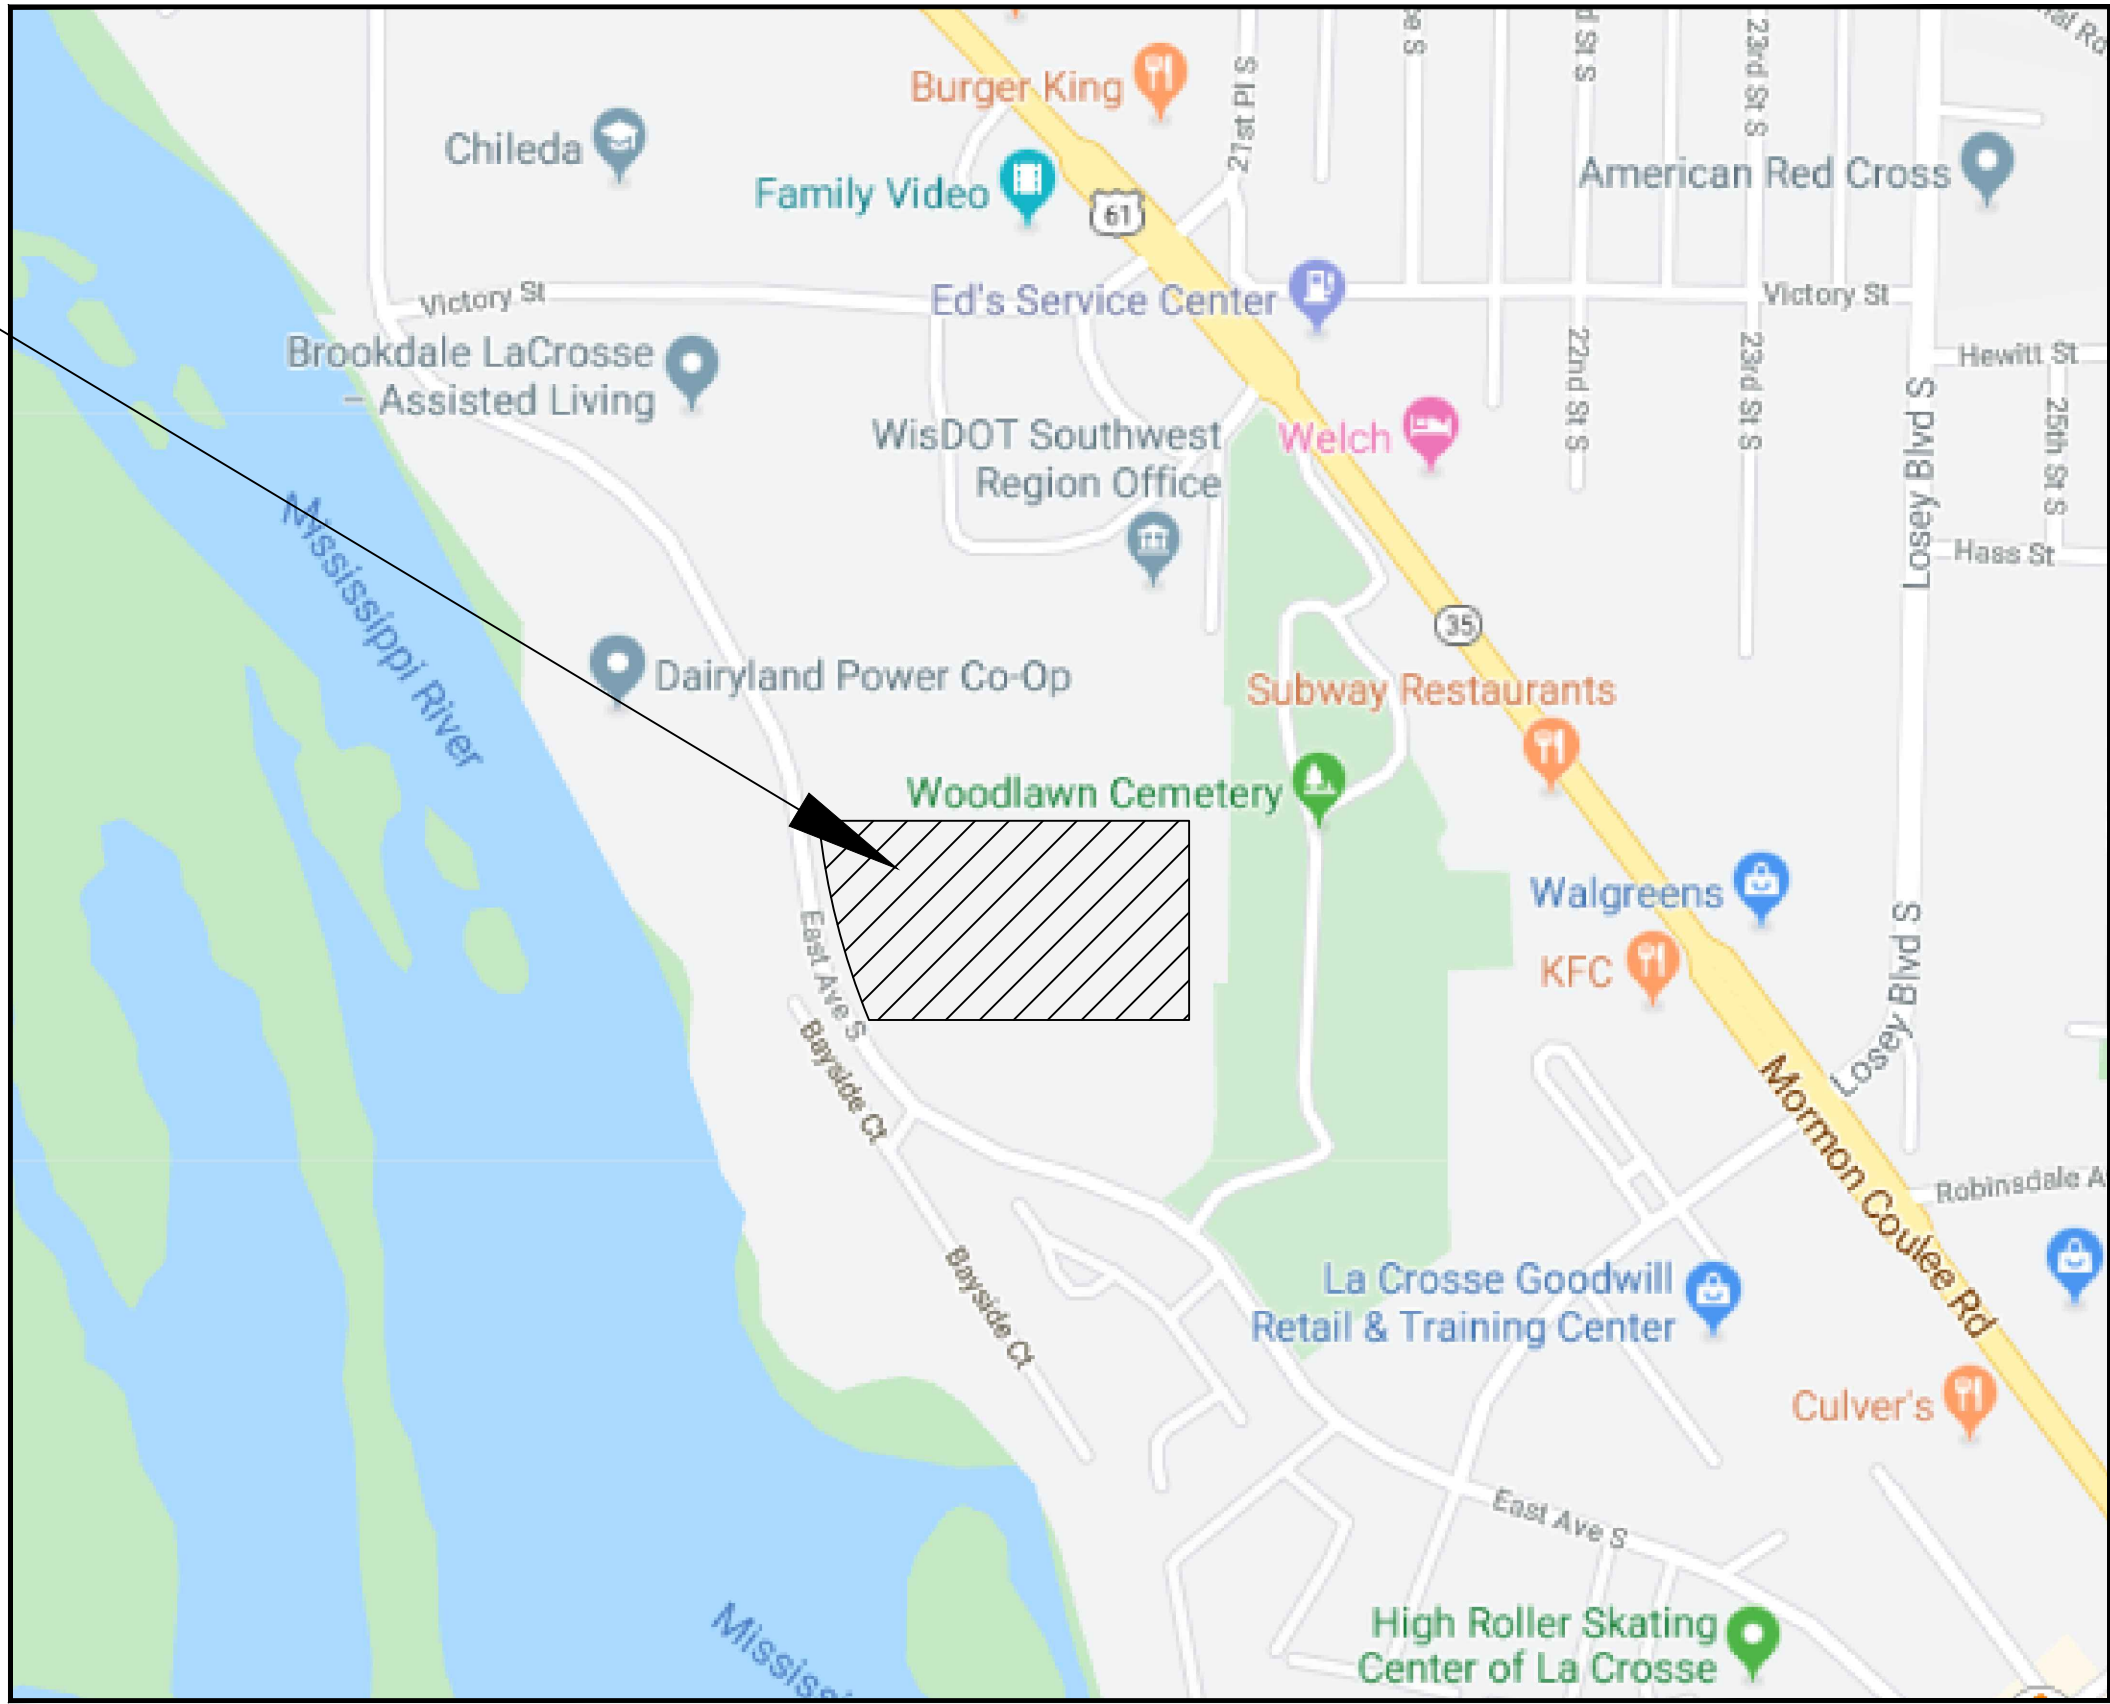

LOCATION MAP

LAND OWNER:
DAIRYLAND POWER COOPERATIVE
3200 EAST AVE S
LA CROSSE, WI 54602
PHONE: 608.788.4000

PROJECT ARCHITECT:
RIVER VALLEY ARCHITECTS
LINDA POWERS
3300 BIRCH STREET, SUITE 1A
EAU CLAIRE, WI 54703
PHONE: 715.832.0875
EMAIL: linda@rivervalleyarchitects.com

PROJECT ENGINEER:
ADVANCED ENGINEERING CONCEPTS
SEAN BOHAN, P.E.
1360 INTERNATIONAL DRIVE, SUITE #1
EAU CLAIRE, WI 54701
PHONE: 715.552.0330
EMAIL: sbohan@rls-aec.com

SCHEDULE OF REQUIRED PERMITS		
APPROVALS NEEDED	DATE SUBMITTED	APPROVAL
DSPS-EXTERIOR PLUMBING		

LEGEND	
EXISTING	PROPOSED
	----BENCHMARK
	----CONTROL POINT
	----SIGN
	----CURB STOP
	----WELL
	----HYDRANT
	----GATE VALVE
	----CURB INLET
	----AREA DRAIN
	----SAN MH
	----STORM MH
	----SAN CLEANOUT
	----GAS MANHOLE
	----LIGHT POLE
	----UTILITY POLE
	----GUY WIRE
	----GUY POLE
	----PULL BOX
	----ELEC PED
	----CABLE PED
	----MAILBOX
	----TELE PED
	----IRON PIPE
	----ROW POST
	----REBAR
	----WATER MAIN
	----SANITARY SEWER
	----STORM SEWER
	----OVERHEAD UTILITY
	----TELEPHONE LINE
	----GAS LINE
	----ELECTRIC LINE
	----CABLE TV LINE
	----TREELINE
	----EXISTING TREES
	----MARSH
	----FENCE LINE
	----WOVEN WIRE FENCE
	----SILT FENCE
	----RETAINING WALL
	----CONTOURS MAJOR
	----CONTOURS MINOR

SHEET SCHEDULE	
SHEET NO.	DESCRIPTION
C100	TITLE SHEET
C200	EXISTING CONDITIONS & DEMOLITION PLAN
C300	SITE PLAN
C400	UTILITY PLAN
C500	GRADING PLAN


AEC PROJECT #:19343 PLANS DATED: JANUARY, 2020



ADVANCED ENGINEERING CONCEPTS
1360 INTERNATIONAL DRIVE, SUITE #1
EAU CLAIRE, WI 54701
PH 715-552-0330
INFO@RLS-AEC.COM
COPYRIGHT 2020, AEC LLC.



ADVANCED ENGINEERING CONCEPTS
1360 INTERNATIONAL DR. SUITE #1
EAU CLAIRE, WI 54701
PH: 715-552-0330
info@rls-aec.com
COPYRIGHT 2019 AEC LLC.

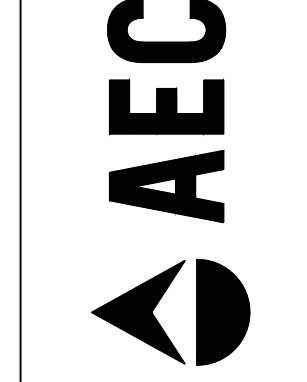

DAIRYLAND POWER COOPERATIVE
PUBLICATION SERVICES
LA CROSSE, WISCONSIN

DATE	DESCRIPTION

DRAWN BY:	TD5
PM:	SPB
JOB NO:	19-049, 19343
DATE:	01.13.2020
TITLE	
C100	

NOT FOR CONSTRUCTION - SD



Know what's below.
Call before you dig.



0 15 30 60

NOTE:
CONTRACTOR TO FIELD VERIFY
EXISTING UTILITY LOCATIONS

LEGEND

- (1105)--- EXISTING CONTOURS-MNR
- (1105)--- EXISTING CONTOURS-MJR
- [Hatched Box] CLEAR AND GRUB TREES (CLEARING LIMITS)
- [Cross-hatched Box] REMOVE PAVEMENT
- [Wavy Line] FULL-DEPTH SAWCUT
- [Vertical Lines] WTR/SAN. UTILITY REMOVAL
- [Zigzag Line] FENCE REMOVAL
- [Dashed Line] CURB & GUTTER REMOVAL
- [X] CLEAR & GRUB TREE


GENERAL NOTES:

- UNDERGROUND UTILITIES ARE SHOWN IN APPROXIMATE LOCATIONS ONLY AND ARE NOT SHOWN IN THEIR ENTIRETY. CONTRACTOR SHALL NOTIFY UTILITIES A MINIMUM OF 3 DAYS PRIOR TO ANY EXCAVATION FOR FIELD VERIFICATION OF LOCATIONS. THE CLIENT, CITY, AND THE ENGINEER ARE NOT RESPONSIBLE OR LIABLE FOR ANY DAMAGE CAUSED TO EXISTING UTILITIES.
- CLEARING AND GRUBBING SHALL ONLY BE IN THOSE LOCATIONS DIRECTED BY THE ENGINEER AND/OR OWNER. CONTRACTOR SHALL PROTECT ALL TREES, SHRUBS, AND CORRESPONDING ROOT SYSTEMS FROM DAMAGE. ALL WORK WITH POTENTIAL IMPACT ON UN-CLEARED TREES AND/OR SHRUBS SHALL BE COORDINATED WITH THE ENGINEER AND/OR OWNER.
- CONTRACTOR SHALL NOT DISTURB ANY R/W IRONS. ANY REMOVAL SHALL BE APPROVED BY THE ENGINEER, OTHERWISE THE CONTRACTOR SHALL BE BILLED FOR REPLACEMENT.
- NO TREES OR STUMPS ARE TO BE BURIED ON SITE. CONTRACTOR IS RESPONSIBLE FOR ANY PERMITS FOR BURNING OR MATERIAL DISPOSAL.
- CONTRACTOR TO REPAIR AND RESTORE ANY DAMAGED OR DISTURBED AREAS OF PAVEMENT, CONCRETE, LANDSCAPING, ELECTRICAL, AND AUTOMATIC IRRIGATION, ETC. TO ITS ORIGINAL CONDITION ON ADJACENT PROPERTIES.
- IF DURING THE COURSE OF CONSTRUCTION THE CONTRACTOR FINDS ANY DISCREPANCIES OR CONFLICTS BETWEEN THE PROPOSED SITE IMPROVEMENTS INDICATED ON THE PLANS AND THE PHYSICAL CONDITIONS OF THE SITE, OR ANY ERRORS OR OMISSIONS WITHIN THE PLANS OR IN THE SITE LAYOUT AS PROVIDED BY THE ENGINEER, IT SHALL BE THE RESPONSIBILITY OF THE CONTRACTOR TO IMMEDIATELY NOTIFY THE ENGINEER. UNTIL AUTHORIZED TO PROCEED, ANY WORK PERFORMED AFTER SUCH DISCOVERY WILL BE AT THE CONTRACTOR'S SOLE RISK AND EXPENSE.

C200 - EXISTING CONDITIONS & DEMOLITION PLAN



ADVANCED ENGINEERING CONCEPTS
1360 INTERNATIONAL DR. SUITE #1
EAU CLAIRE, WI 54701
PH: 715-552-0330
info@aes-aec.com
COPYRIGHT 2019 AEC LLC.

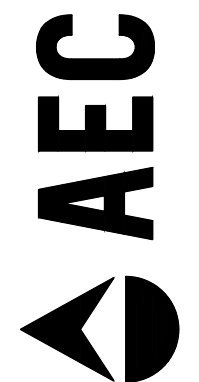


DAIRYLAND POWER COOPERATIVE
PUBLICATION SERVICES
LA CROSSE, WISCONSIN

NOT FOR CONSTRUCTION - SD


DATE	DESCRIPTION
01.13.2020	EXISTING CONDITIONS #
01.13.2020	DEMOLITION PLAN

DRAWN BY: TDS
PM: SPB
JOB NO: 19-049,
19343
DATE: 01.13.2020

C200

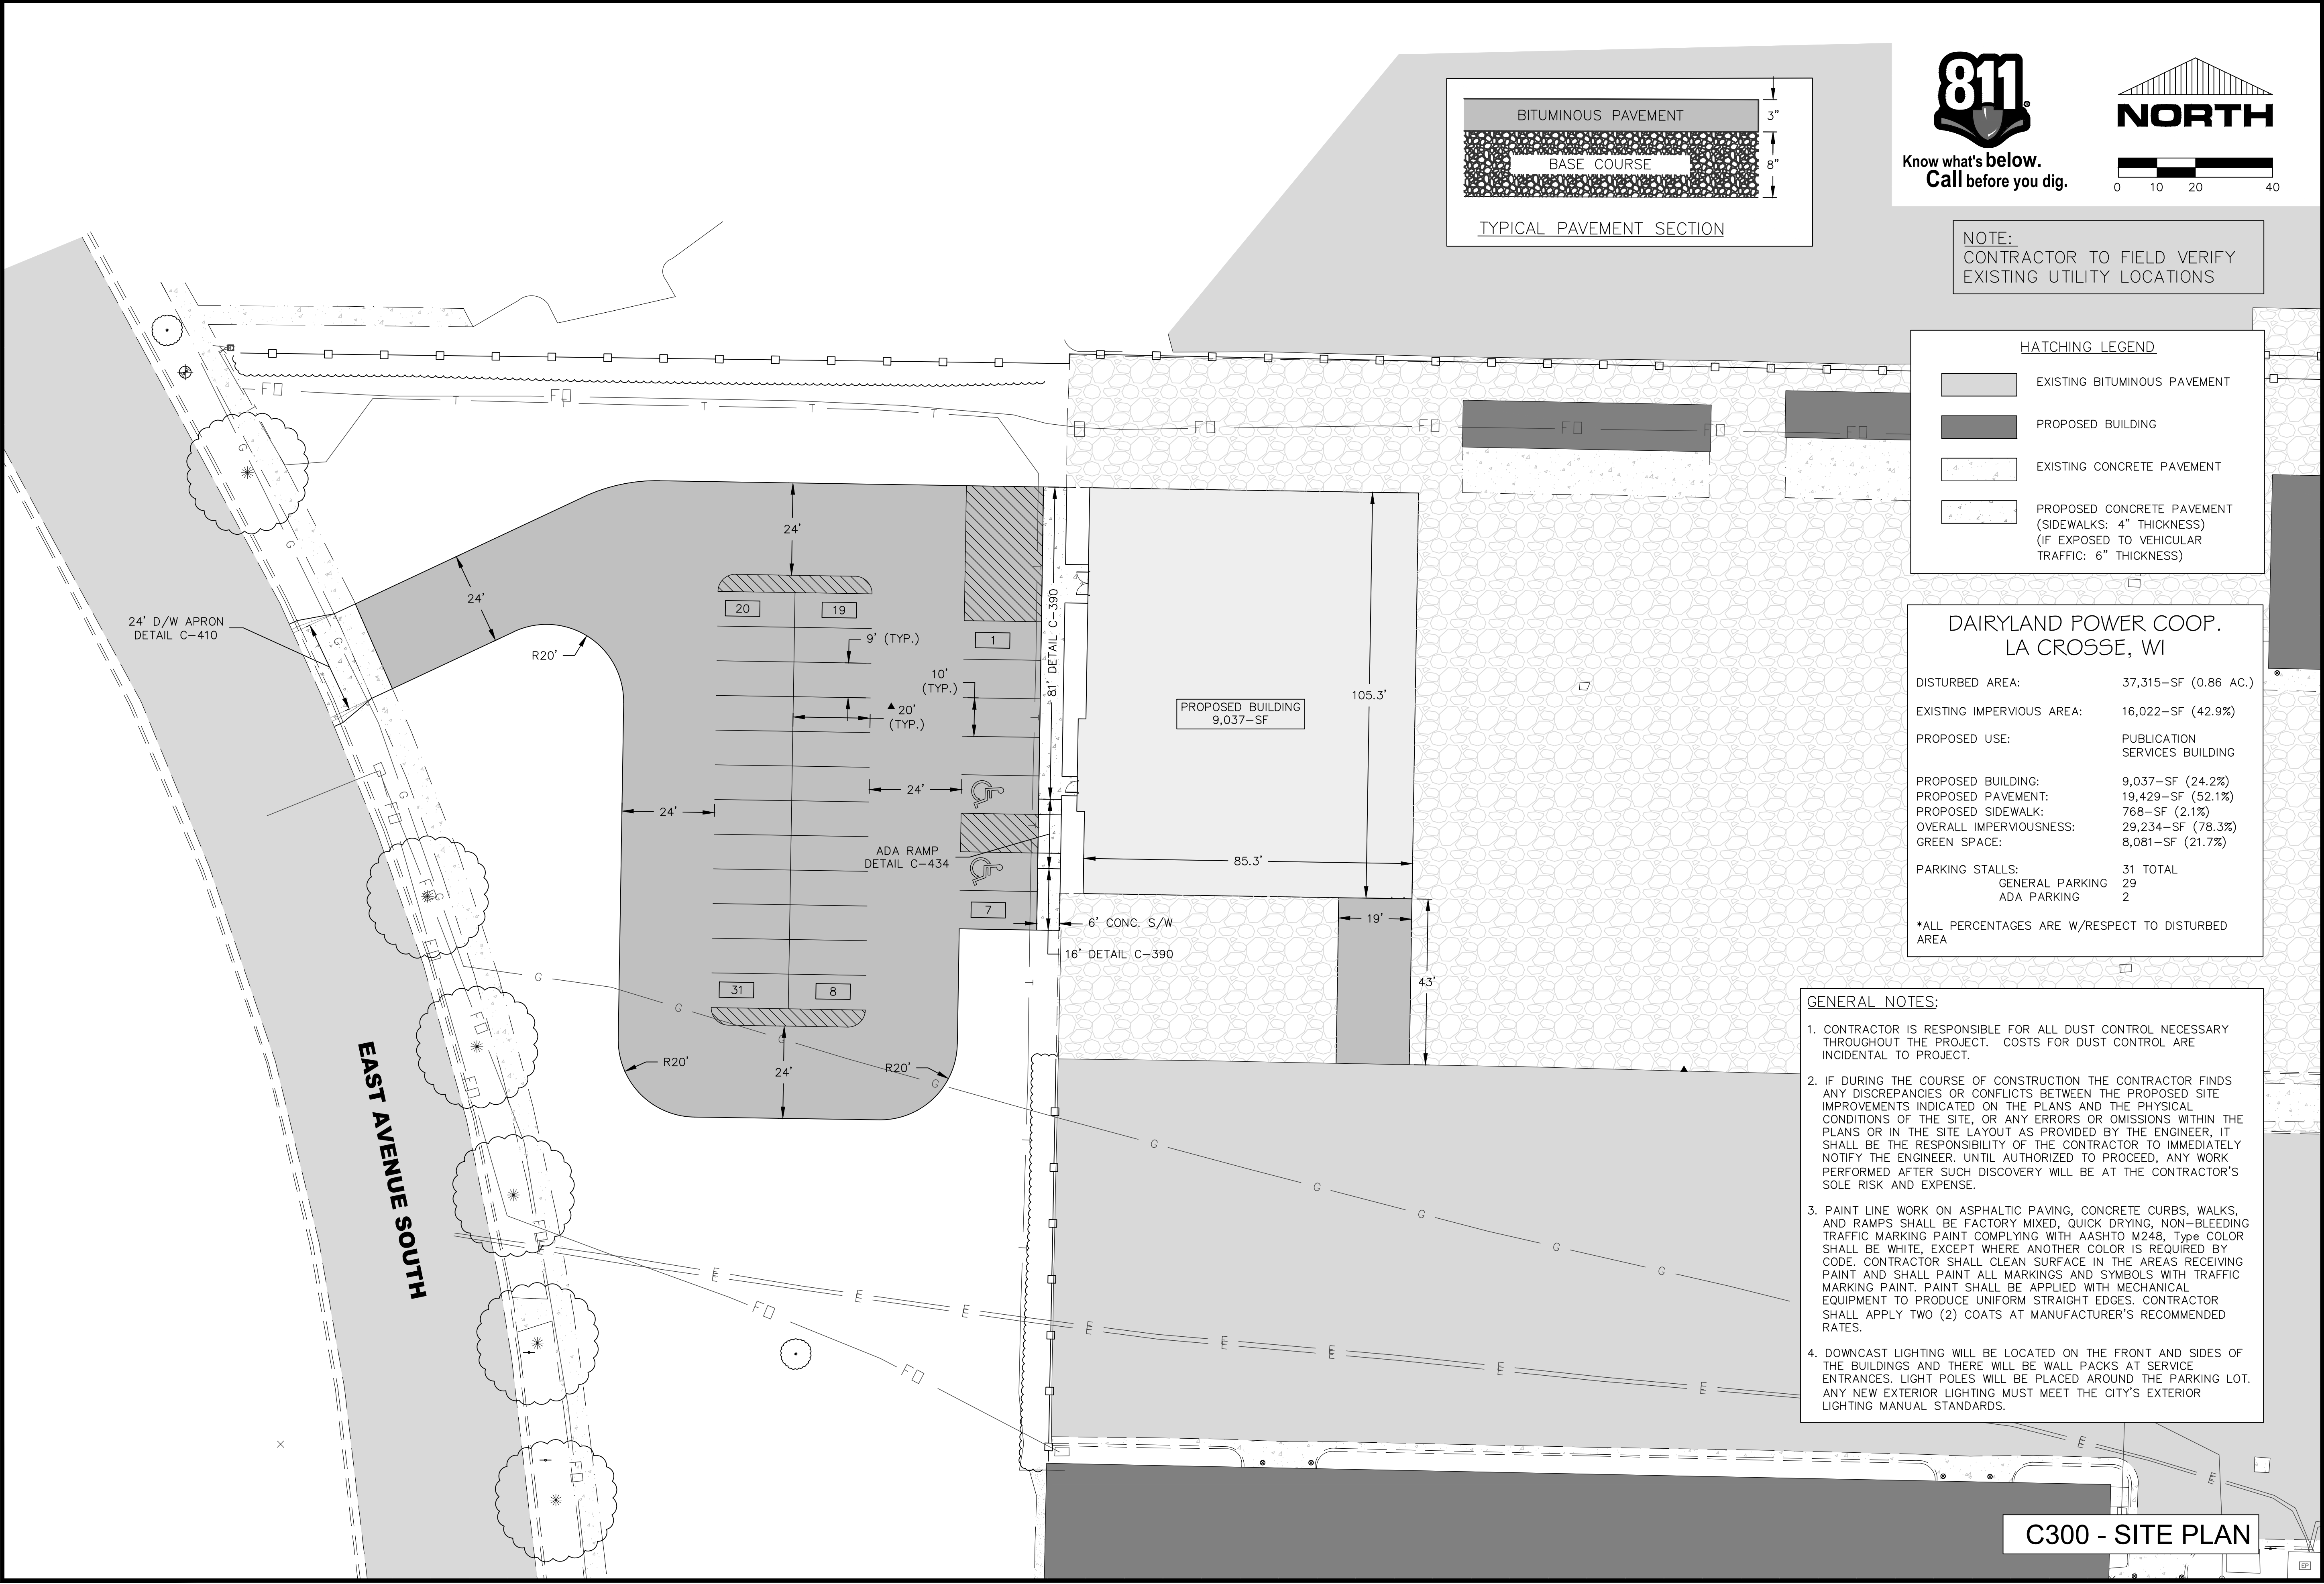

Know what's below.
Call before you dig.

 

NOTE:
CONTRACTOR TO FIELD VERIFY
EXISTING UTILITY LOCATIONS

HATCHING LEGEND

- EXISTING BITUMINOUS PAVEMENT
- PROPOSED BUILDING
- EXISTING CONCRETE PAVEMENT
- PROPOSED CONCRETE PAVEMENT (SIDEWALKS: 4" THICKNESS) (IF EXPOSED TO VEHICULAR TRAFFIC: 6" THICKNESS)

DAIRYLAND POWER COOP.
LA CROSSE, WI

DISTURBED AREA:	37,315-SF (0.86 AC.)
EXISTING IMPERVIOUS AREA:	16,022-SF (42.9%)
PROPOSED USE:	PUBLICATION SERVICES BUILDING
PROPOSED BUILDING:	9,037-SF (24.2%)
PROPOSED PAVEMENT:	19,429-SF (52.1%)
PROPOSED SIDEWALK:	768-SF (2.1%)
OVERALL IMPERVIOUSNESS:	29,234-SF (78.3%)
GREEN SPACE:	8,081-SF (21.7%)

PARKING STALLS:	31 TOTAL
GENERAL PARKING	29
ADA PARKING	2

*ALL PERCENTAGES ARE W/RESPECT TO DISTURBED AREA


GENERAL NOTES:

- CONTRACTOR IS RESPONSIBLE FOR ALL DUST CONTROL NECESSARY THROUGHOUT THE PROJECT. COSTS FOR DUST CONTROL ARE INCIDENTAL TO PROJECT.
- IF DURING THE COURSE OF CONSTRUCTION THE CONTRACTOR FINDS ANY DISCREPANCIES OR CONFLICTS BETWEEN THE PROPOSED SITE IMPROVEMENTS INDICATED ON THE PLANS AND THE PHYSICAL CONDITIONS OF THE SITE, OR ANY ERRORS OR OMISSIONS WITHIN THE PLANS OR IN THE SITE LAYOUT AS PROVIDED BY THE ENGINEER, IT SHALL BE THE RESPONSIBILITY OF THE CONTRACTOR TO IMMEDIATELY NOTIFY THE ENGINEER. UNTIL AUTHORIZED TO PROCEED, ANY WORK PERFORMED AFTER SUCH DISCOVERY WILL BE AT THE CONTRACTOR'S SOLE RISK AND EXPENSE.
- PAINT LINE WORK ON ASPHALTIC PAVING, CONCRETE CURBS, WALKS, AND RAMP SHALL BE FACTORY MIXED, QUICK DRYING, NON-BLEEDING TRAFFIC MARKING PAINT COMPLYING WITH AASHTO M248. Type COLOR SHALL BE WHITE, EXCEPT WHERE ANOTHER COLOR IS REQUIRED BY CODE. CONTRACTOR SHALL CLEAN SURFACE IN THE AREAS RECEIVING PAINT AND SHALL PAINT ALL MARKINGS AND SYMBOLS WITH TRAFFIC MARKING PAINT. PAINT SHALL BE APPLIED WITH MECHANICAL EQUIPMENT TO PRODUCE UNIFORM STRAIGHT EDGES. CONTRACTOR SHALL APPLY TWO (2) COATS AT MANUFACTURER'S RECOMMENDED RATES.
- DOWNCAST LIGHTING WILL BE LOCATED ON THE FRONT AND SIDES OF THE BUILDINGS AND THERE WILL BE WALL PACKS AT SERVICE ENTRANCES. LIGHT POLES WILL BE PLACED AROUND THE PARKING LOT. ANY NEW EXTERIOR LIGHTING MUST MEET THE CITY'S EXTERIOR LIGHTING MANUAL STANDARDS.

C300 - SITE PLAN



ADVANCED ENGINEERING CONCEPTS
1360 INTERNATIONAL DR. SUITE #1
EAU CLAIRE, WI 54701
PH: 715-552-0330
info@aes-aec.com
COPYRIGHT 2019 AEC LLC.

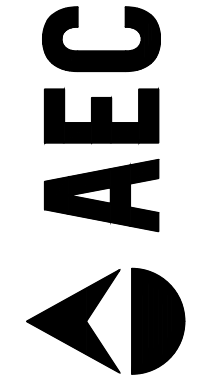

DAIRYLAND POWER COOPERATIVE
PUBLICATION SERVICES
LA CROSSE, WISCONSIN


DATE	DESCRIPTION

DRAWN BY: TDS
PM: SPB
JOB NO: 19-049,
19343
DATE: 01.13.2020

SITE PLAN

C300

 NOT FOR CONSTRUCTION - SD



NOTE:
CONTRACTOR TO FIELD VERIFY
EXISTING UTILITY LOCATIONS

EX. STM MH
RIM=657.90
INV.=648.15 (10", NW)
INV.=648.05 (10", S)

EX. STM MH
RIM=659.34
INV.=648.99 (21", E)
INV.=648.84 (36", S)
INV.=648.84 (36", N)

 
 
EX. AREA DRAIN
RIM=659.19
INV.=650.59 (21", W)
INV.=650.74 (18", SE)

EX. STM MH
RIM=657.83-
(NO INVERT INFO)

EX. STM MH
RIM=657.32
INV.=651.82 (12", NE)

EX. STM MH
RIM=657.23
INV.=652.03 (12", NE)

GRADING LEGEND:

- | | |
|---|--------------------------|
|  | EXISTING CONTOURS-MNR |
|  | EXISTING CONTOUR-MJR |
|  | FINAL CONTOUR-MJR |
|  | FINAL CONTOUR-MNR |
|  | DRAINAGE PATTERN LINES |
|  | GRADE BREAK LINES |
|  | DRAINAGE ARROW |
|  | PROPOSED SPOT ELEVATION |
|  | EXISTING SPOT ELEVATION |
|  | FINISHED FLOOR ELEVATION |
|  | TOP OF CURB |

GRADING NOTES:


1. ALL CONTOURS ARE COMPUTER GENERATED AND REPRESENT APPROXIMATE LOCATIONS. PROPOSED CONTOURS REPRESENT FINISHED GROUND GRADES AFTER RESTORATION. CONTOURS IN STREET REPRESENT TOP OF PAVEMENT.
2. CONTRACTOR SHALL BE RESPONSIBLE FOR INSURING POSITIVE DRAINAGE AWAY FROM STRUCTURES.
3. ALL SPOT ELEVATIONS ARE TOP OF ASPHALT/GRAVEL UNLESS OTHERWISE NOTED.
4. IF DURING THE COURSE OF CONSTRUCTION THE CONTRACTOR FINDS ANY DISCREPANCIES OR CONFLICTS BETWEEN THE PROPOSED SITE IMPROVEMENTS INDICATED ON THE PLANS AND THE ACTUAL PHYSICAL CONDITIONS OF THE SITE, OR ANY ERRORS OR OMISSIONS WITHIN THE PLANS OR IN THE SITE LAYOUT AS PROVIDED BY THE ENGINEER, IT SHALL BE THE RESPONSIBILITY OF THE CONTRACTOR TO IMMEDIATELY NOTIFY THE ENGINEER. UNTIL AUTHORIZED TO PROCEED, ANY WORK PERFORMED AFTER SUCH DISCOVERY WILL BE AT THE CONTRACTOR'S SOLE RISK AND EXPENSE.

C500 - GRADING PLAN



RVA
RIVER VALLEY ARCHITECTS
3330 Birch Street, Suite 1A | Eau Claire, WI 54703

ADVANCED ENGINEERING CONCEPTS
1360 INTERNATIONAL DR, SUITE #1
EAU CLAIRE, WI 54701
PH: 715-552-0330
info@ae-aec.com
COPYRIGHT 2019 AEC LLC.

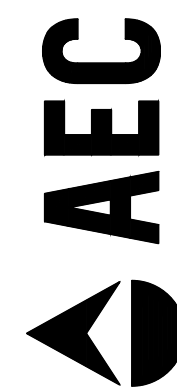

DAIRYLAND POWER COOPERATIVE
PUBLICATION SERVICES
LA CROSSE, WISCONSIN


NOT FOR CONSTRUCTION - SD

[illegible]

DRAWN BY:	TDS
PM:	SPB
JOB NO:	19-049, 19343
DATE:	01.13.2020
GRADING PLAN	


C500

1/27/2020 3:38:18 PM C:\Revit\Locals19-049 DAIRYLAND POWER - PRINT SERVICES_adamX2DX2.rvt

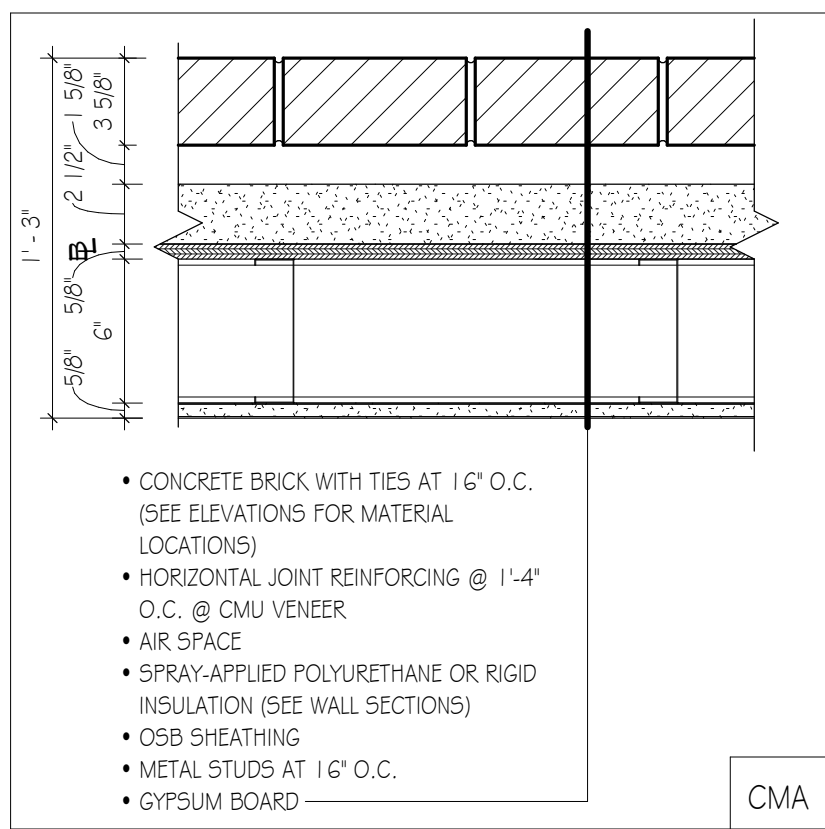

EXTERIOR WALL TYPES

1 1/2" = 1'-0"

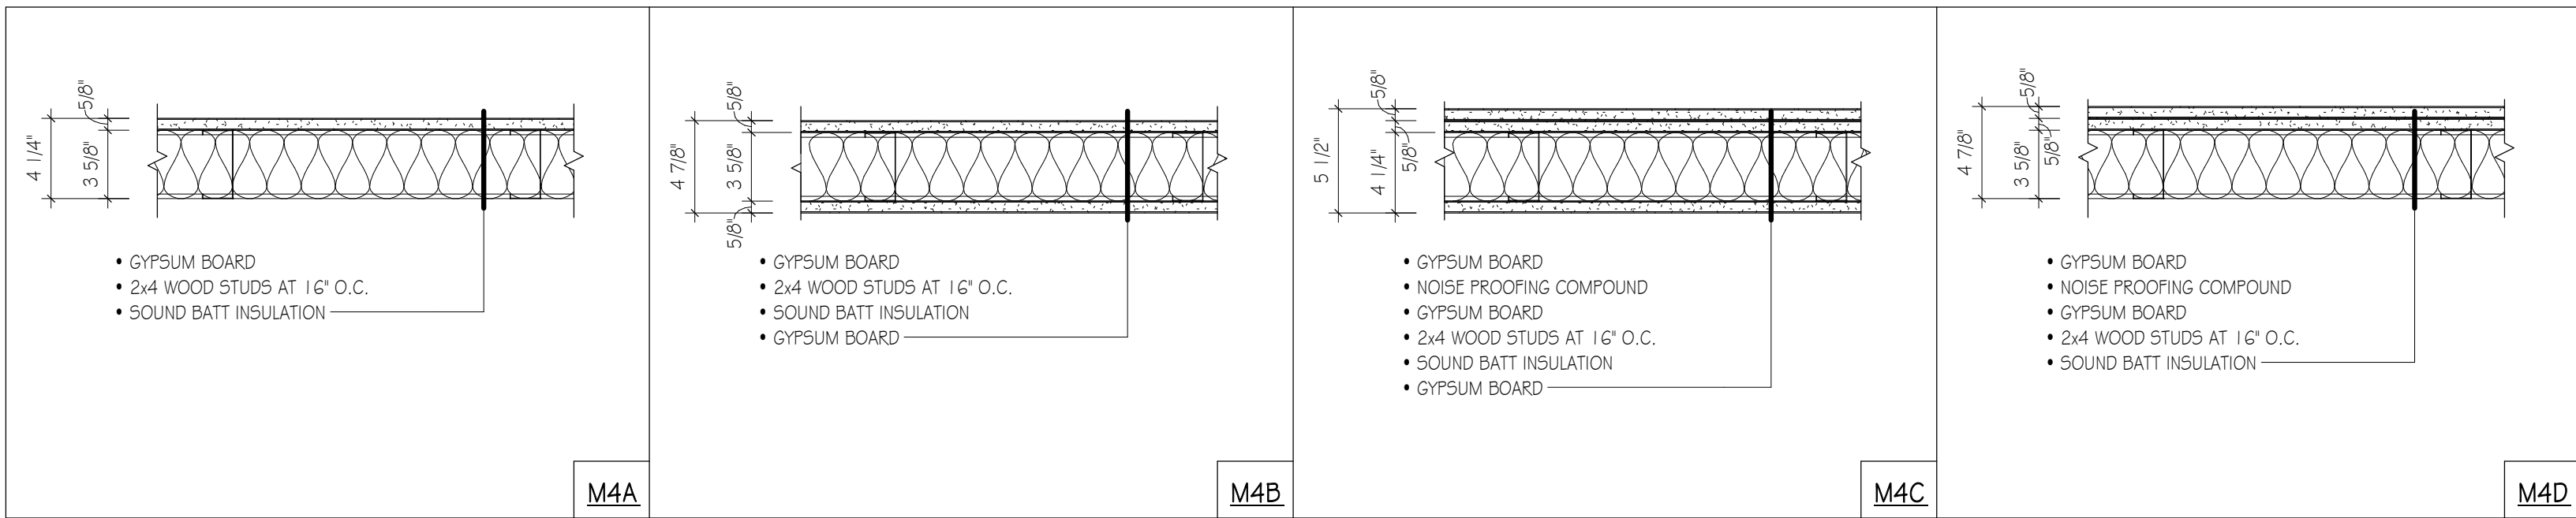


INTERIOR WALL TYPES

1 1/2" = 1'-0"


KEY NOTES

GENERAL NOTES

- ALL INTERIOR DIMENSIONS ARE FROM FACE OF STUD/ MASONRY CONSTRUCTION TO FACE OF STUD/MASONRY CONSTRUCTION, UNLESS NOTED OTHERWISE.
- "CLEAR DIMENSIONS" ARE DIMENSIONED FROM FACE OF FINISH MATERIAL TO FACE OF FINISH MATERIAL.
- FOR WALL TYPES SEE SHEET A3.1
- GENERAL CONTRACTOR SHALL COORDINATE WITH OWNER, BEFORE INSTALLATION OF GYPSUM BOARD, ANY WOOD BLOCKING, BACKING AND MOUNTING BOARDS REQUIRED FOR OWNER PROVIDED ITEMS.
- ALL WALLS TO GO TIGHT TO STRUCTURE ABOVE, UNLESS NOTED OTHERWISE.

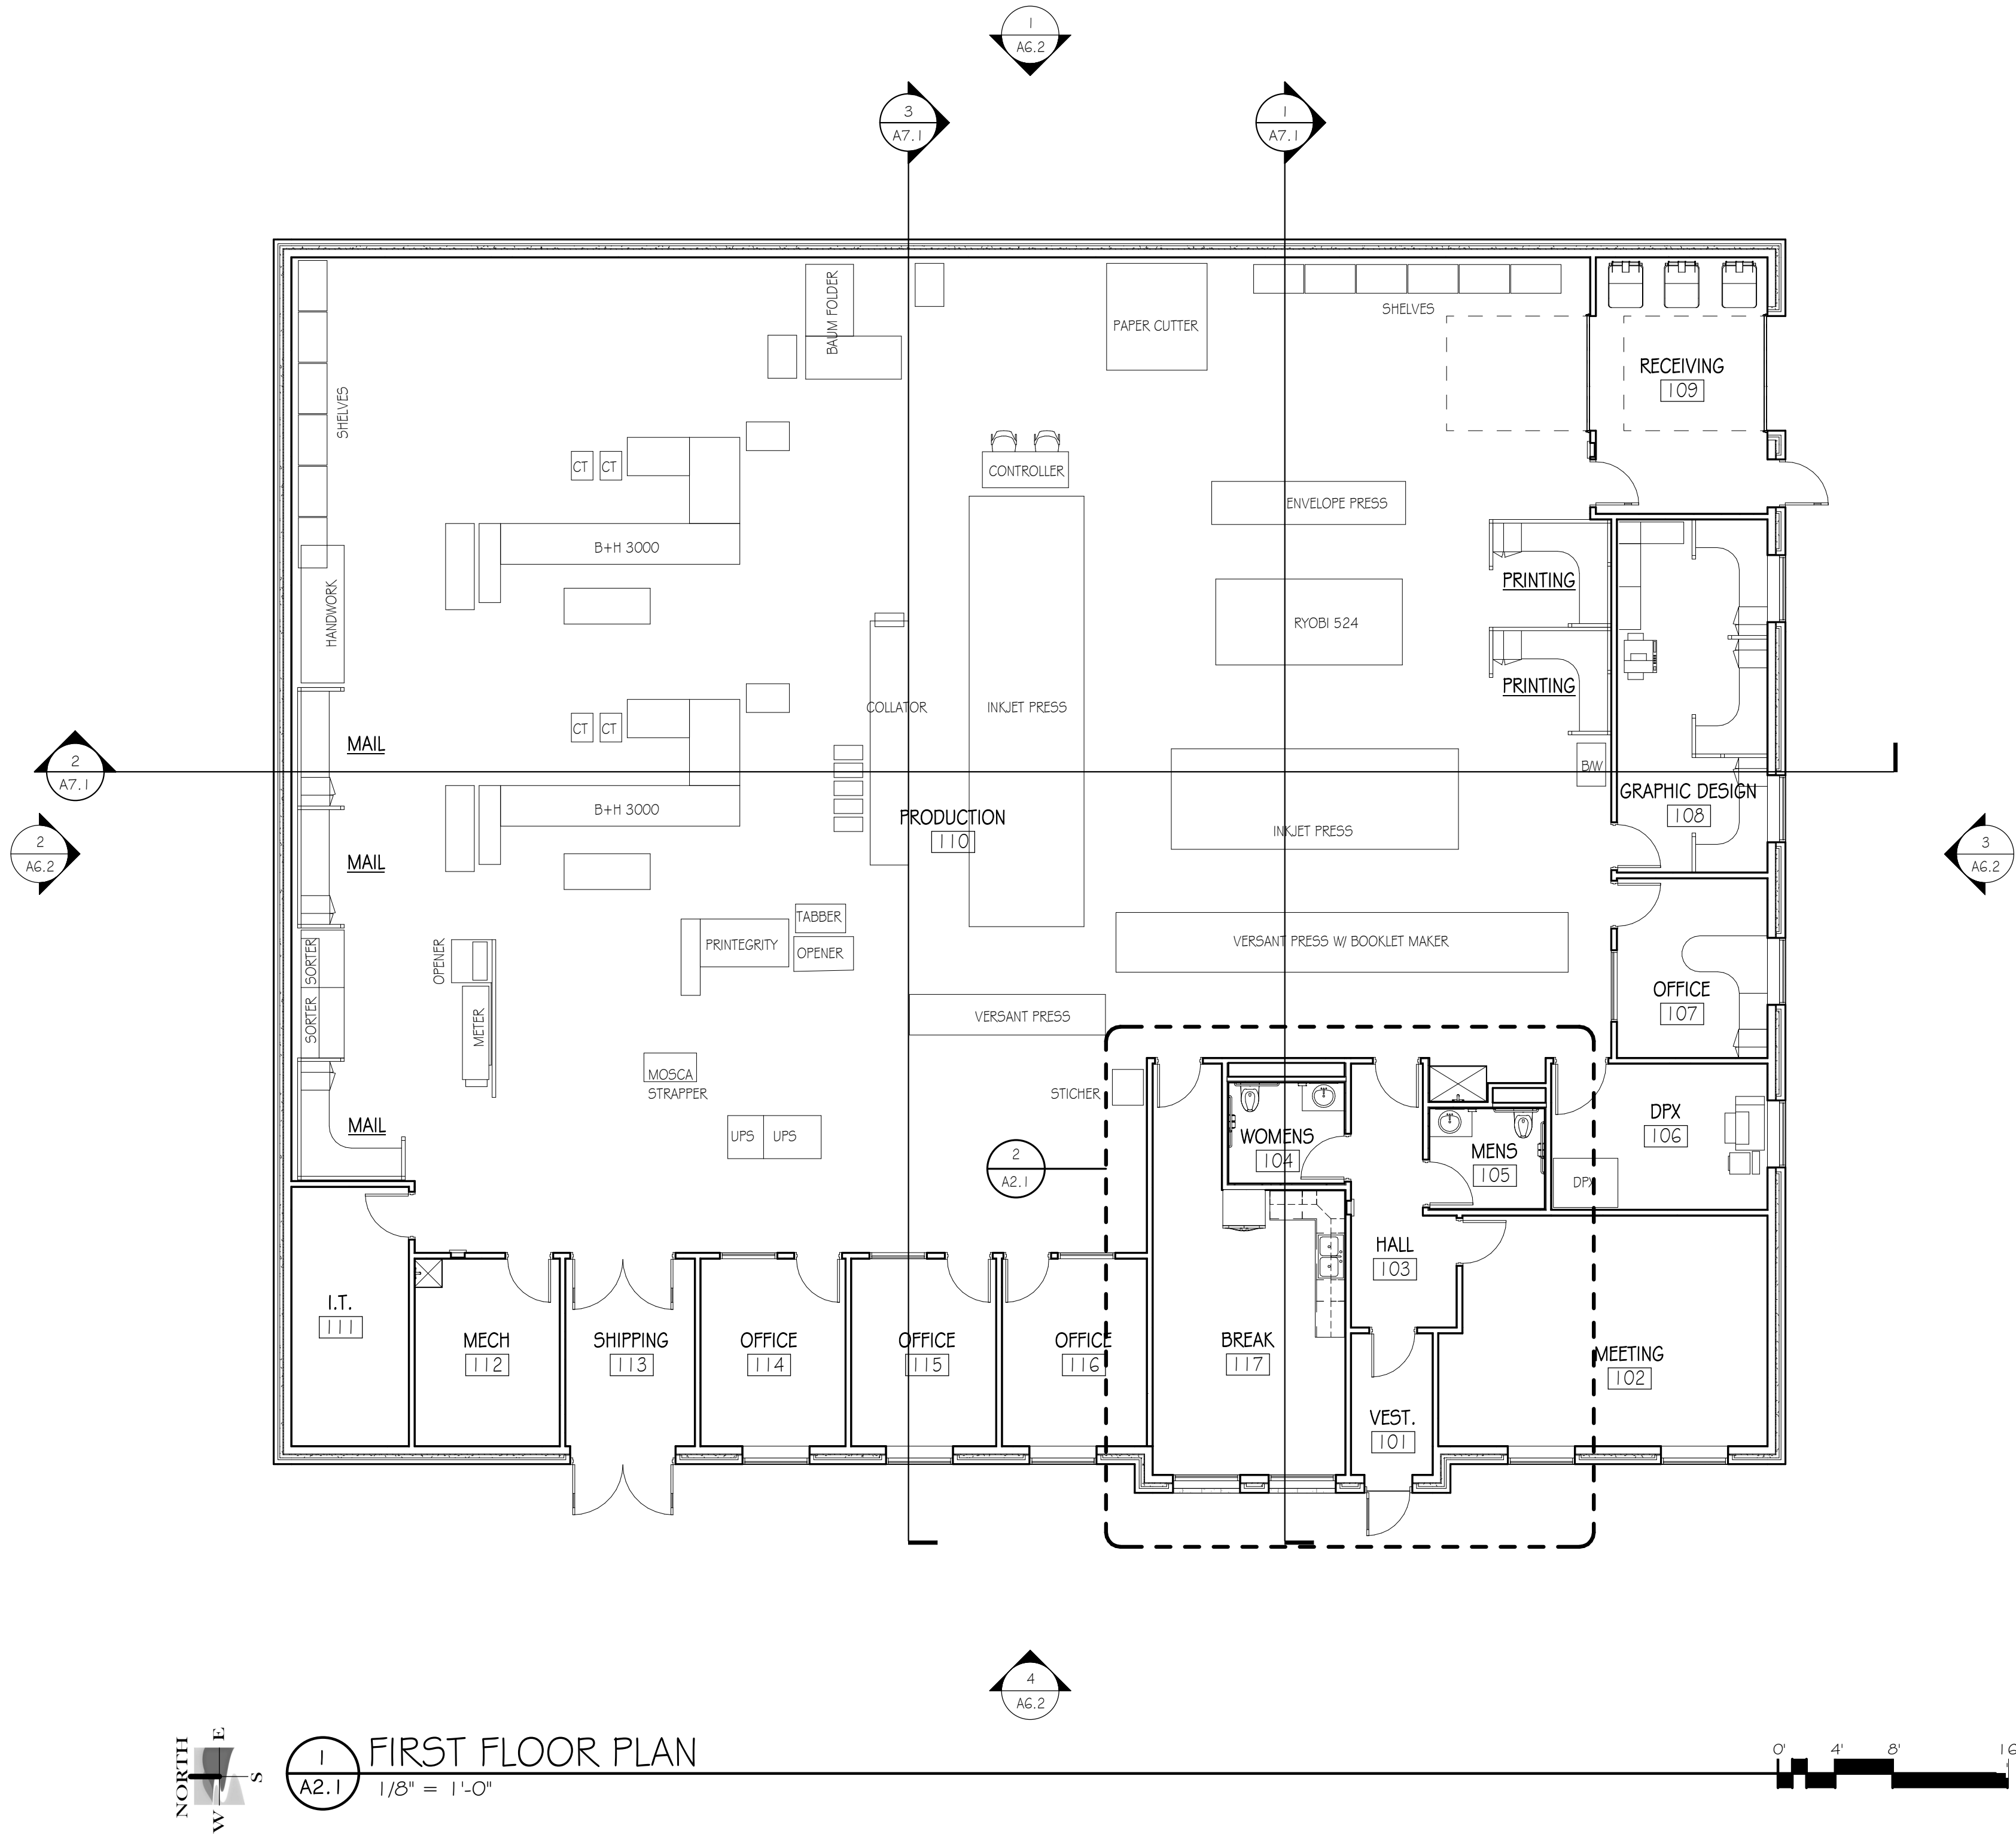

1 FIRST FLOOR PLAN
A2.1 1/8" = 1'-0"

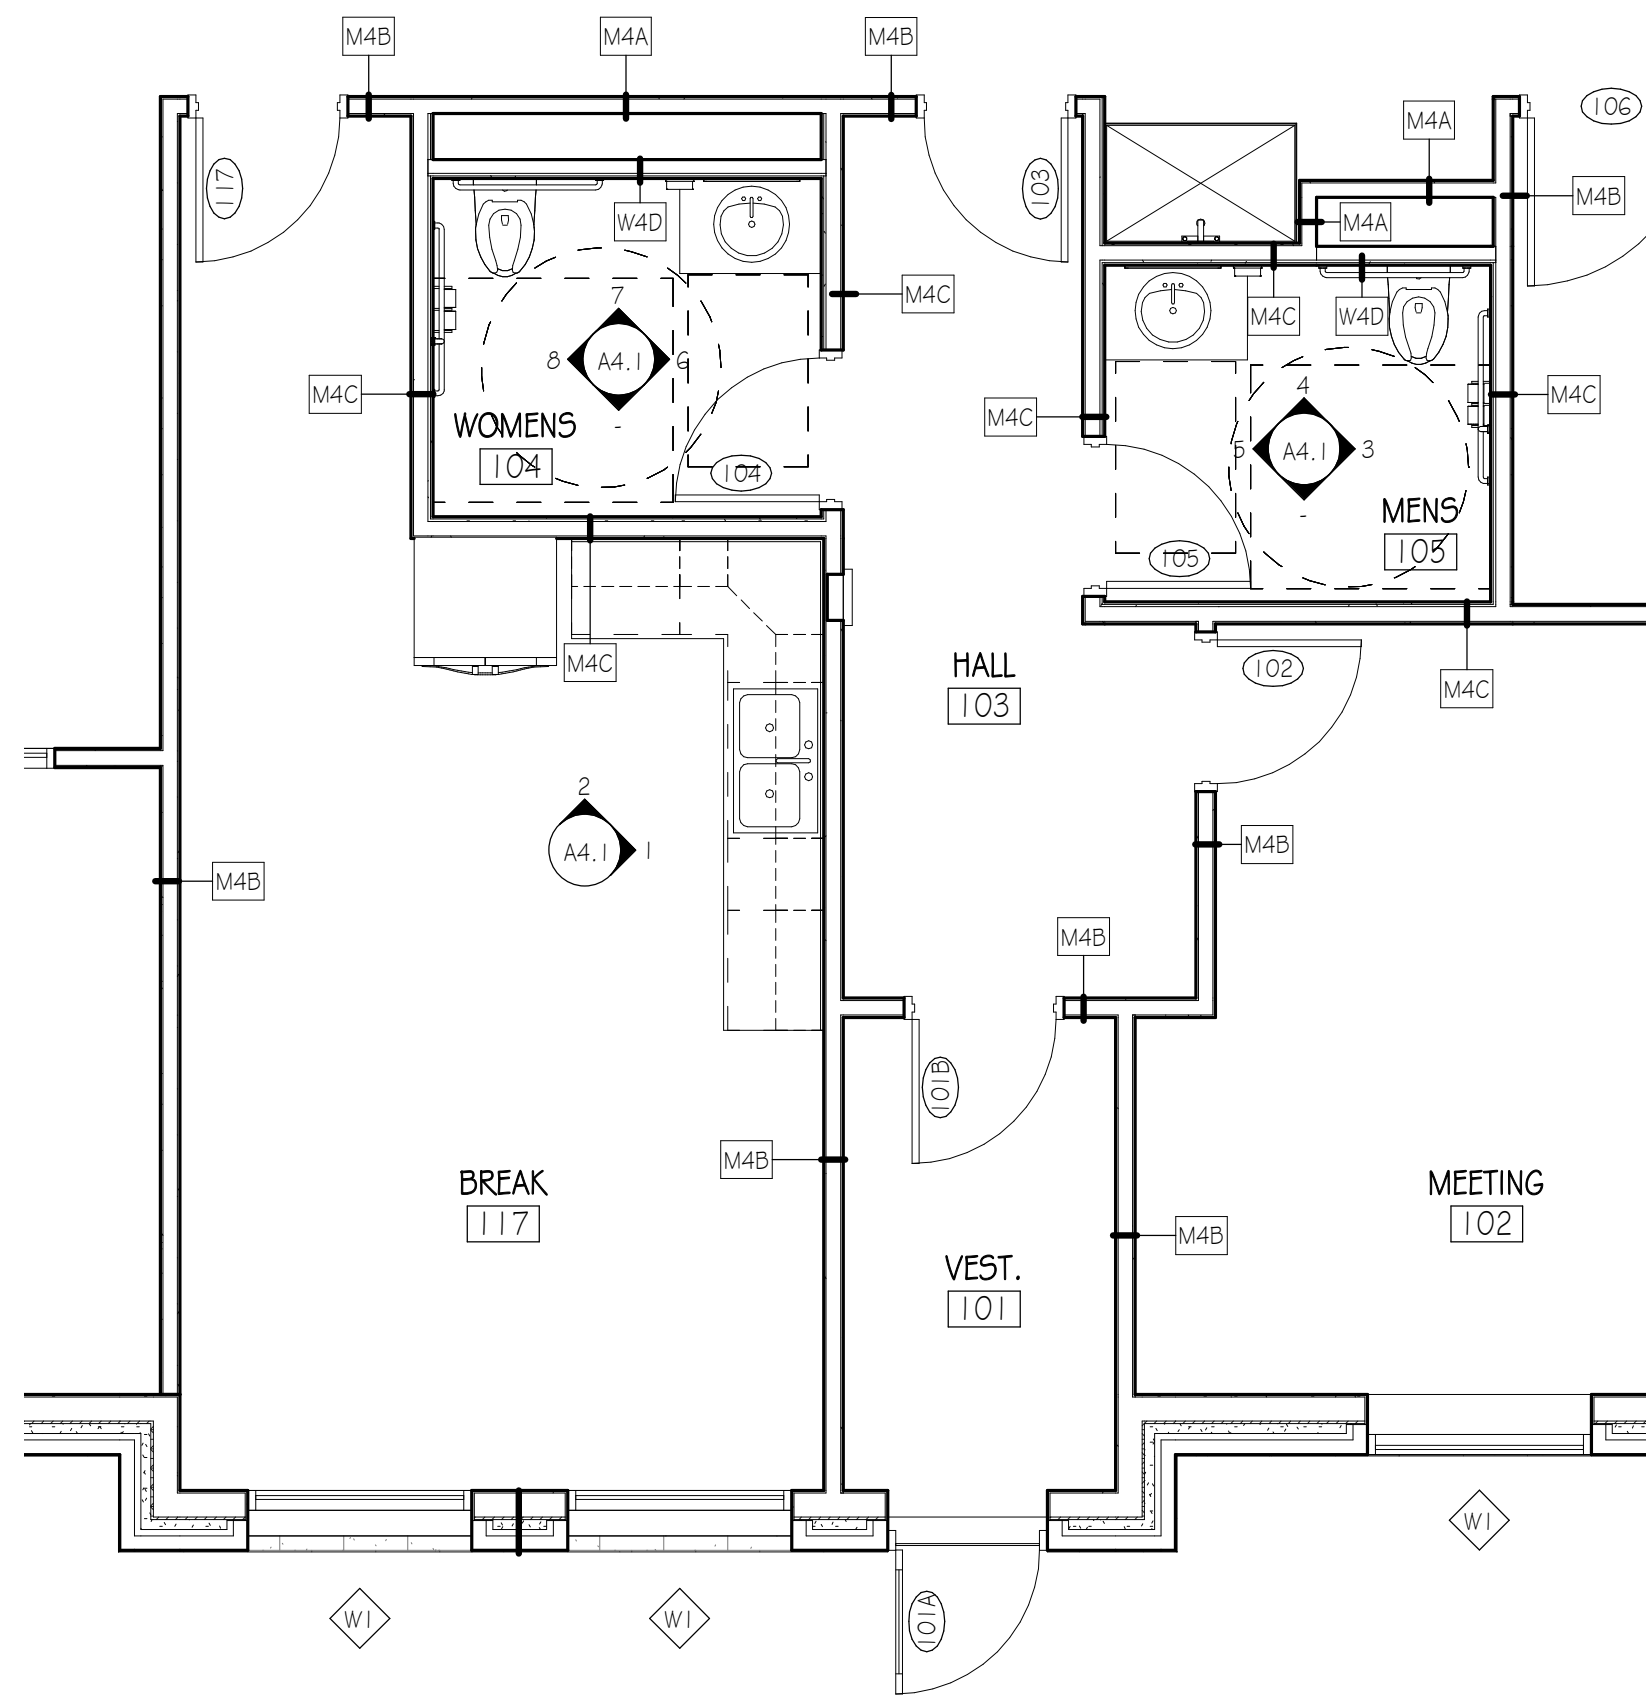

2 ENLARGED PLAN
A2.1 1/4" = 1'-0"

DAIRYLAND POWER COOPERATIVE
PUBLICATION SERVICES
LA CROSSE, WISCONSIN

MARK	DATE	DESCRIPTION


DRAWN BY: ATB
PM: LP
JOB NO: 19-049
DATE: 01.29.2020
FLOOR PLAN

A2.1

NOT FOR CONSTRUCTION - SD


[illegible]

1/27/2020 3:38:19 PM C:\Revit\Locals\19-049 DAIRYLAND POWER - PRINT SERVICES_adamX2DX2.rvt

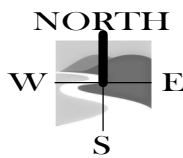

REFLECTED CEILING PLAN - FIRST FLOOR

1/8" = 1'-0"

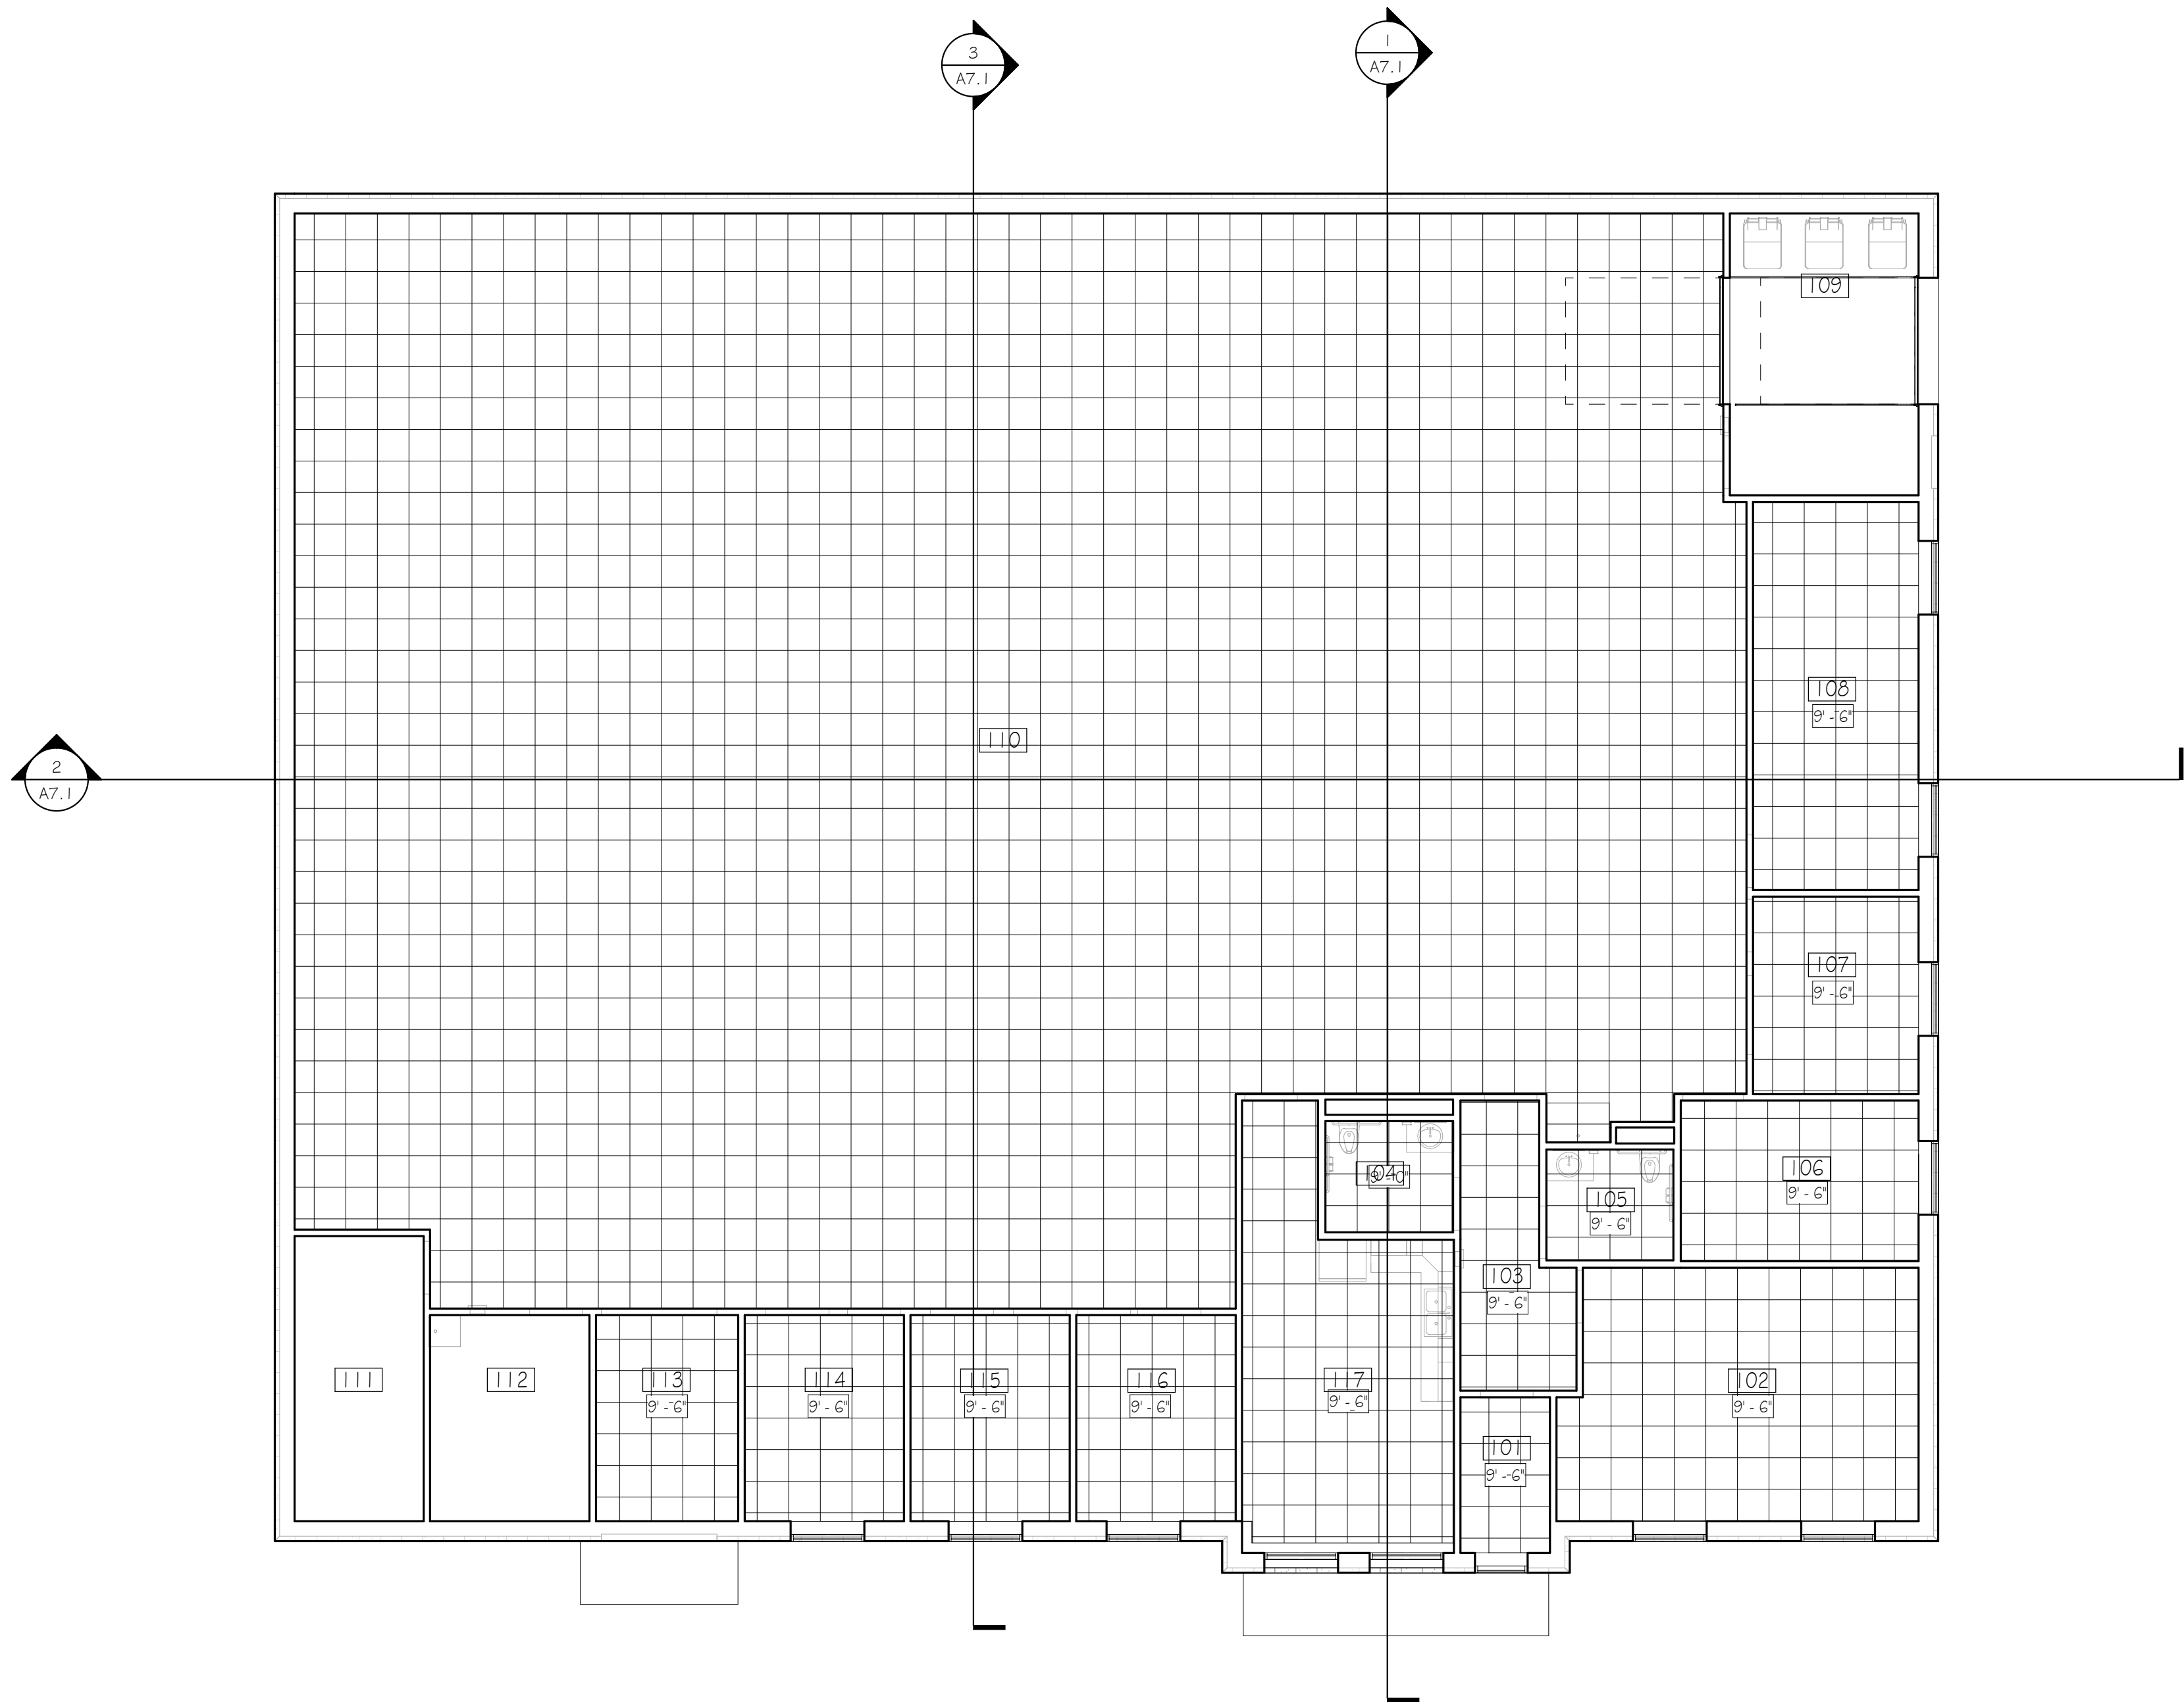

NOTES

GENERAL NOTES

- A. CONTRACTOR SHALL FOLLOW CEILING GRID PATTERN ESTABLISHED ON THE REFLECTED CEILING PLAN. ANY VARIATIONS SHALL BE APPROVED BY THE ARCHITECT.
- B. CONTRACTORS SHALL MOUNT SPRINKLER HEADS, SPEAKERS AND AIR DIFFUSERS IN THE CENTER OF WHOLE CEILING PANELS.

MARK	DATE	DESCRIPTION

DRAWN BY: ATB
PM: LP
JOB NO: 19-049
DATE: 01.29.2020

REFLECTED CEILING
PLAN

A2.4


DAIRYLAND POWER COOPERATIVE
PUBLICATION SERVICES
LA CROSSE, WISCONSIN




3300 Birch Street, Suite 1A | Eau Claire, WI 54703

NOT FOR CONSTRUCTION - SD


1/27/2020 3:38:20 PM C:\Revit Local\19-049 DAIRYLAND POWER - PRINT SERVICES_adamXDX2.rvt

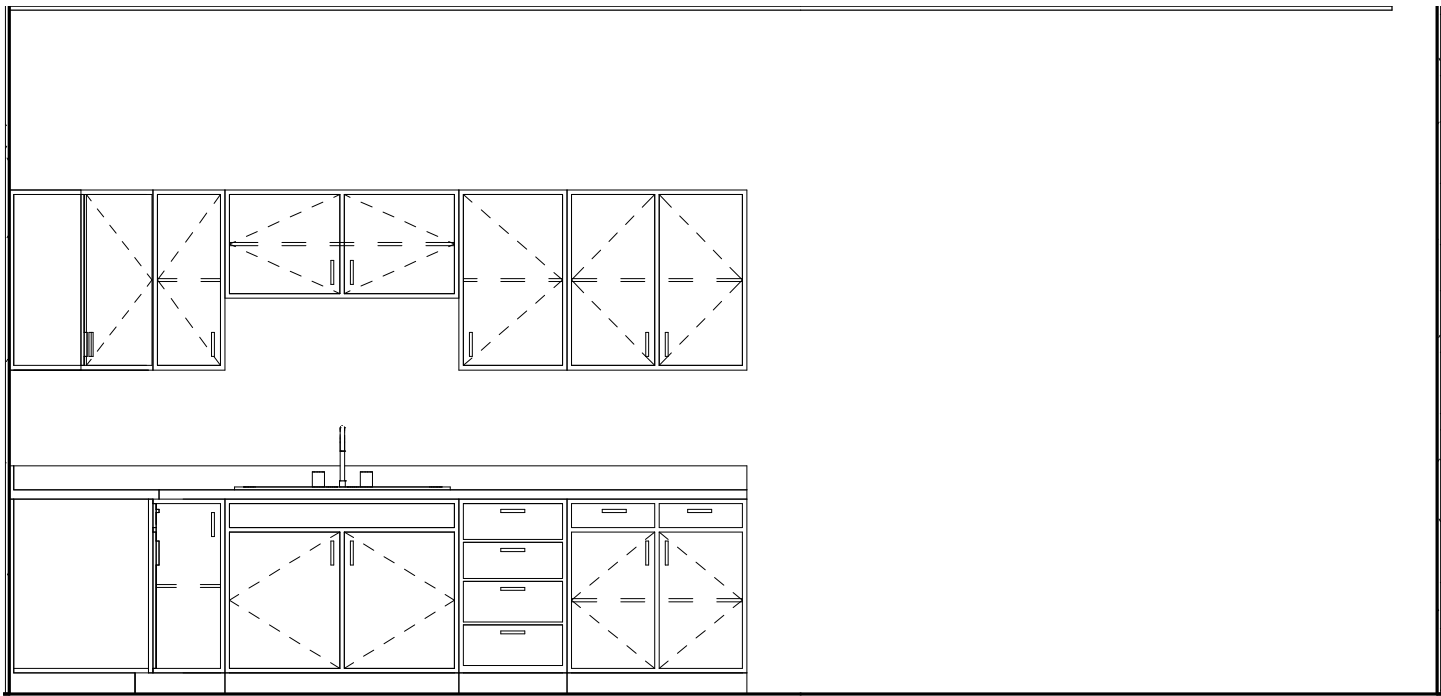


1 INTERIOR ELEVATION - BREAK
A4.1 3/8" = 1'-0"

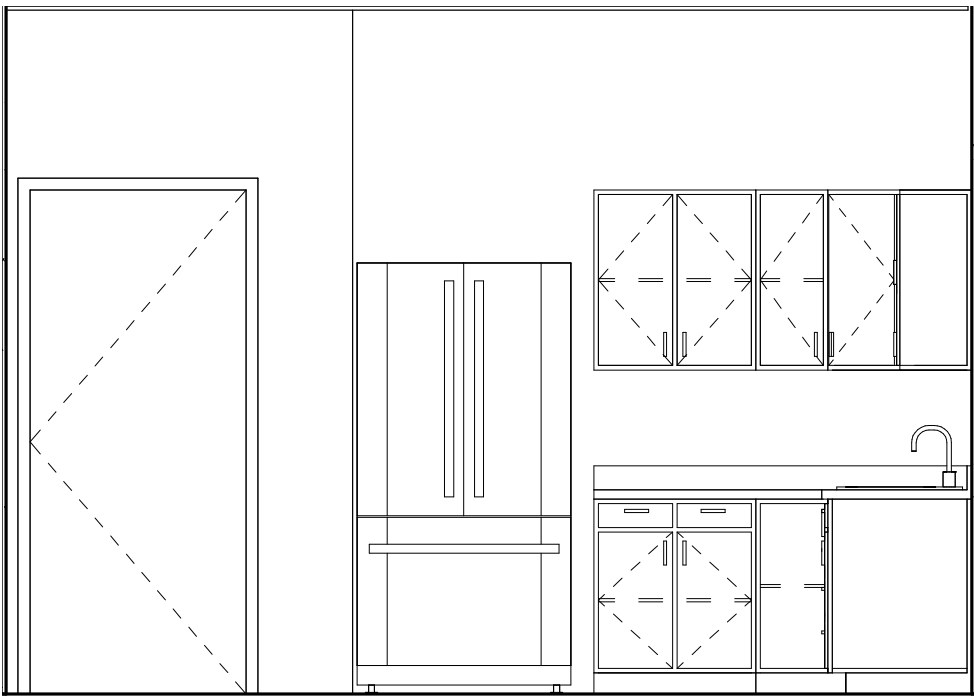


2 INTERIOR ELEVATION - BREAK
A4.1 3/8" = 1'-0"

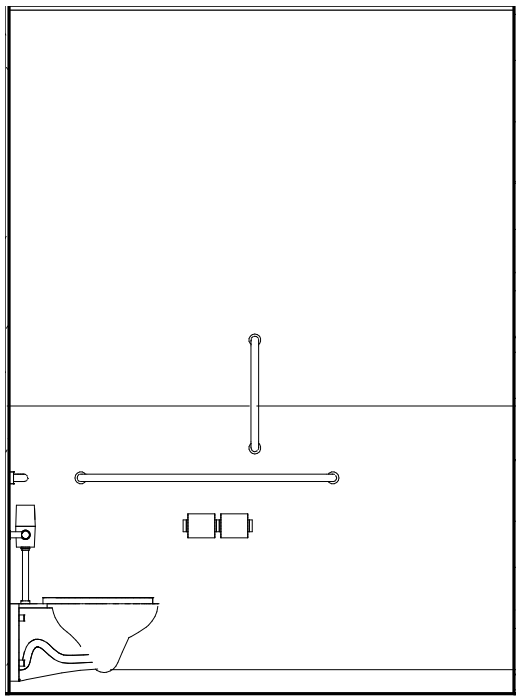


3 INTERIOR ELEVATION - MENS
A4.1 3/8" = 1'-0"

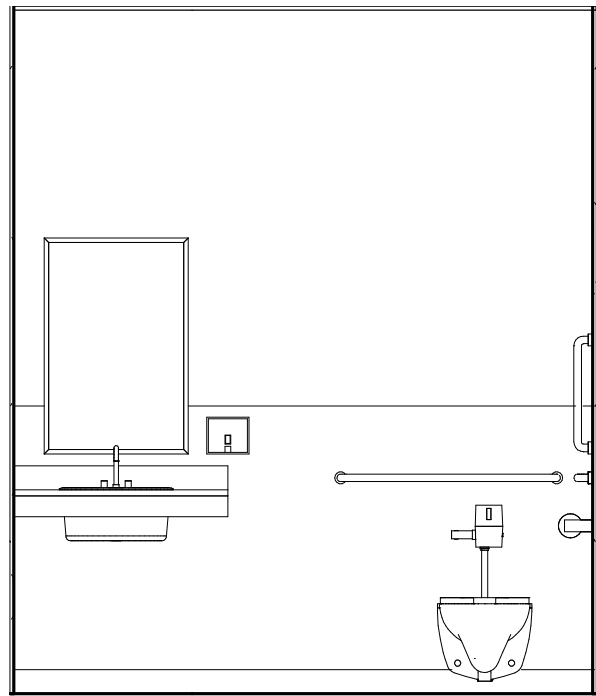


4 INTERIOR ELEVATION - MENS
A4.1 3/8" = 1'-0"

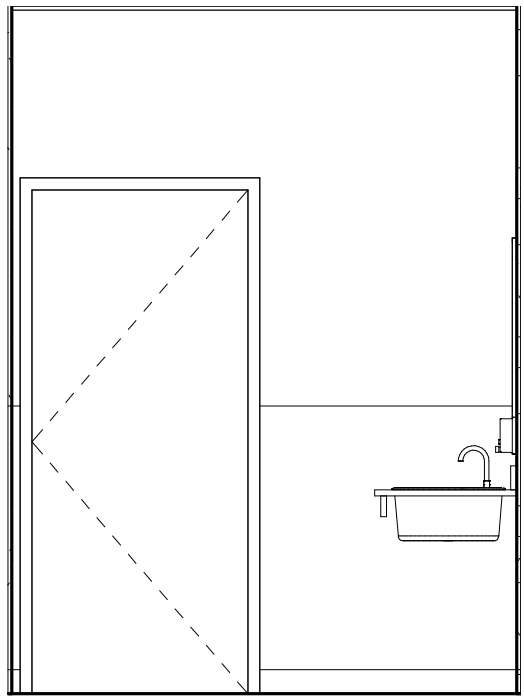


5 INTERIOR ELEVATION - MENS
A4.1 3/8" = 1'-0"

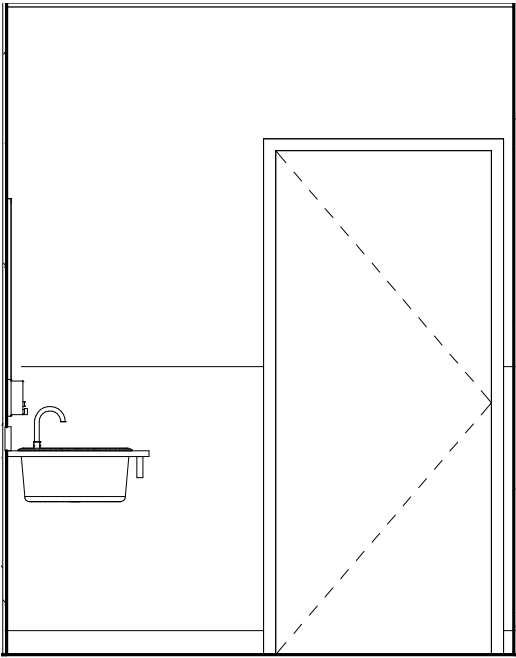

6 INTERIOR ELEVATION - WOMENS
A4.1 3/8" = 1'-0"

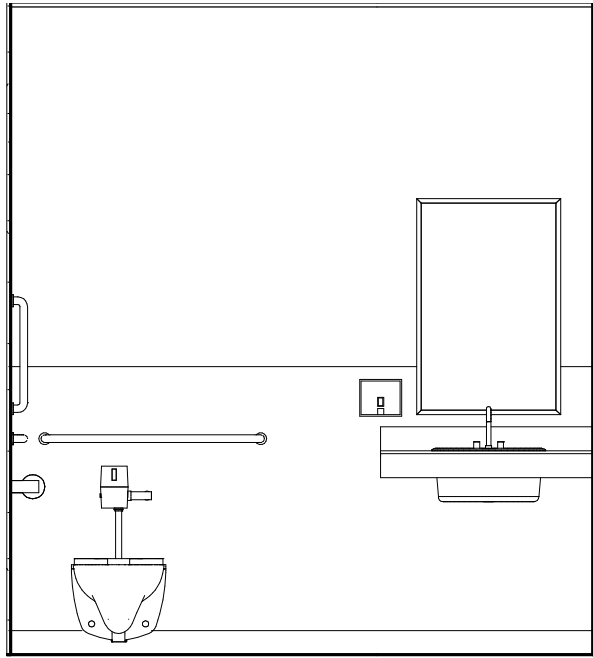

7 INTERIOR ELEVATION - WOMENS
A4.1 3/8" = 1'-0"

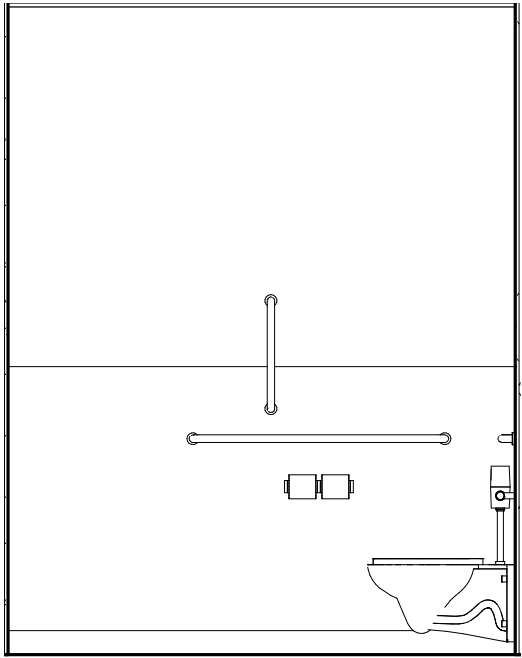

8 INTERIOR ELEVATION - WOMENS
A4.1 3/8" = 1'-0"

NOTES

GENERAL NOTES

A. SEE SHEET AO.2 FOR STANDARD MOUNTING HEIGHTS



DAIRYLAND POWER COOPERATIVE
PUBLICATION SERVICES
LA CROSSE, WISCONSIN

MARK	DATE	DESCRIPTION

DRAWN BY: ATB
PM: LP
JOB NO: 19-049
DATE: 01.29.2020
INTERIOR ELEVATIONS

A4.1


NOT FOR CONSTRUCTION - SD

1/27/2020 3:38:20 PM C:\Revit Local\19-049 DAIRYLAND POWER - PRINT SERVICES_adam\XD2.rvt

DOOR SCHEDULE													
DOOR NUMBER	HARDWARE GROUP	DOOR				LOUVER	FIRE RATING	FRAME					NOTES
		TYPE	MATERIAL	WIDTH	HEIGHT			TYPE	MATERIAL	HEAD	JAMB	SILL	
101A		A	ALUMINUM	3' - 0"	7' - 0"			AL-2	ALUMINUM				
101B		A	WOOD	3' - 0"	7' - 0"			HM-1	HOLLOW METAL				
102		A	WOOD	3' - 0"	7' - 0"			HM-1	HOLLOW METAL				
103		A	WOOD	3' - 0"	7' - 0"			HM-1	HOLLOW METAL				
104		A	WOOD	3' - 0"	7' - 0"			HM-1	HOLLOW METAL				
105		A	WOOD	3' - 0"	7' - 0"			HM-1	HOLLOW METAL				
106		A	WOOD	3' - 6"	7' - 0"			HM-1	HOLLOW METAL				
107		A	WOOD	3' - 0"	7' - 0"			HM-1	HOLLOW METAL				
108		A	WOOD	3' - 0"	7' - 0"			HM-1	HOLLOW METAL				
109A		C	ALUMINUM	3' - 0"	7' - 0"			AL-5	ALUMINUM				
109B		C	ALUMINUM	3' - 0"	7' - 0"			AL-1	ALUMINUM				
109C		D	INSUL. STEEL	8' - 0"	10' - 0"			--	--				
109D		D	INSUL. STEEL	8' - 0"	10' - 0"			--	--				
111		A	WOOD	3' - 0"	7' - 0"			HM-1	HOLLOW METAL				
112		A	WOOD	3' - 0"	7' - 0"			HM-1	HOLLOW METAL				
113A			HOLLOW METAL	7' - 0"	7' - 0"				HOLLOW METAL				
113B			HOLLOW METAL	7' - 0"	7' - 0"				HOLLOW METAL				
114		A	WOOD	3' - 0"	7' - 0"			HM-1	HOLLOW METAL				
115		A	WOOD	3' - 0"	7' - 0"			HM-1	HOLLOW METAL				
116		A	WOOD	3' - 0"	7' - 0"			HM-1	HOLLOW METAL				
117		A	WOOD	3' - 0"	7' - 0"			HM-1	HOLLOW METAL				


DOOR HARDWARE GROUPS

GROUP H-1
CONTINUOUS HINGES

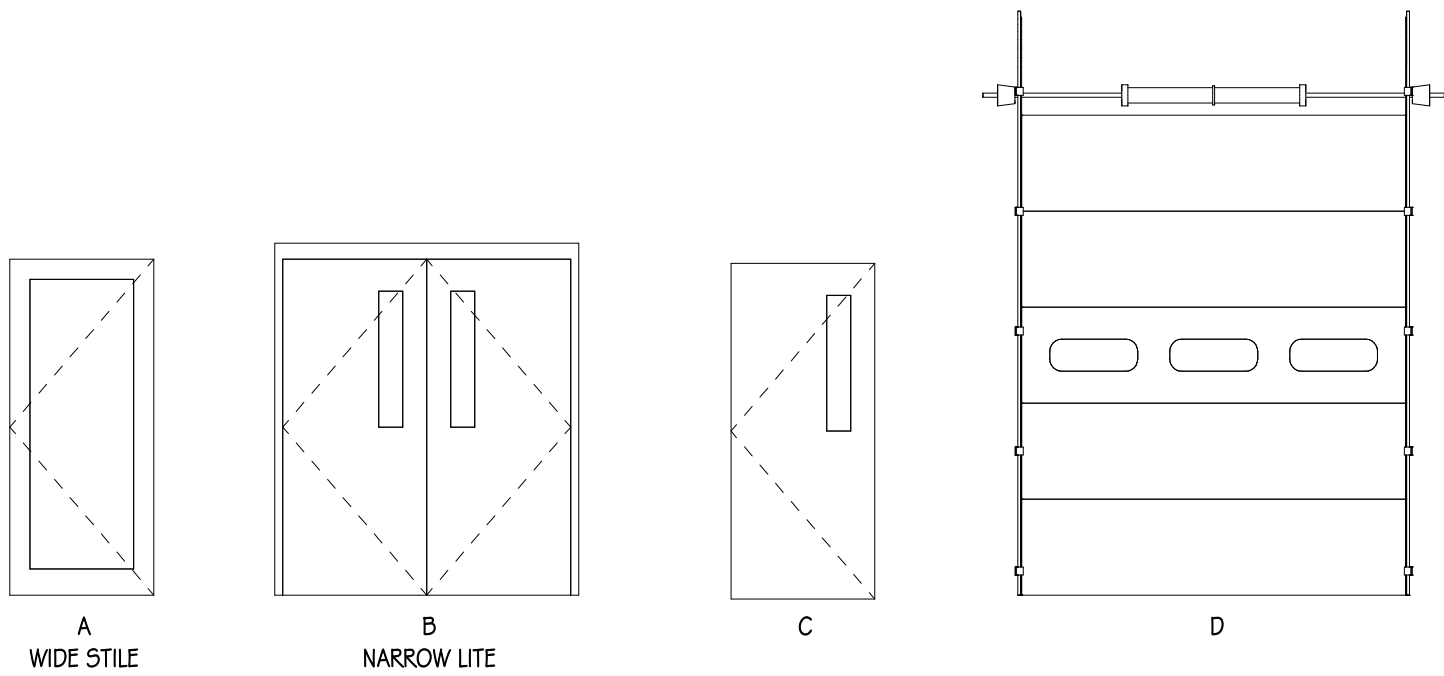

DOOR ELEVATIONS

1/4" = 1'-0"

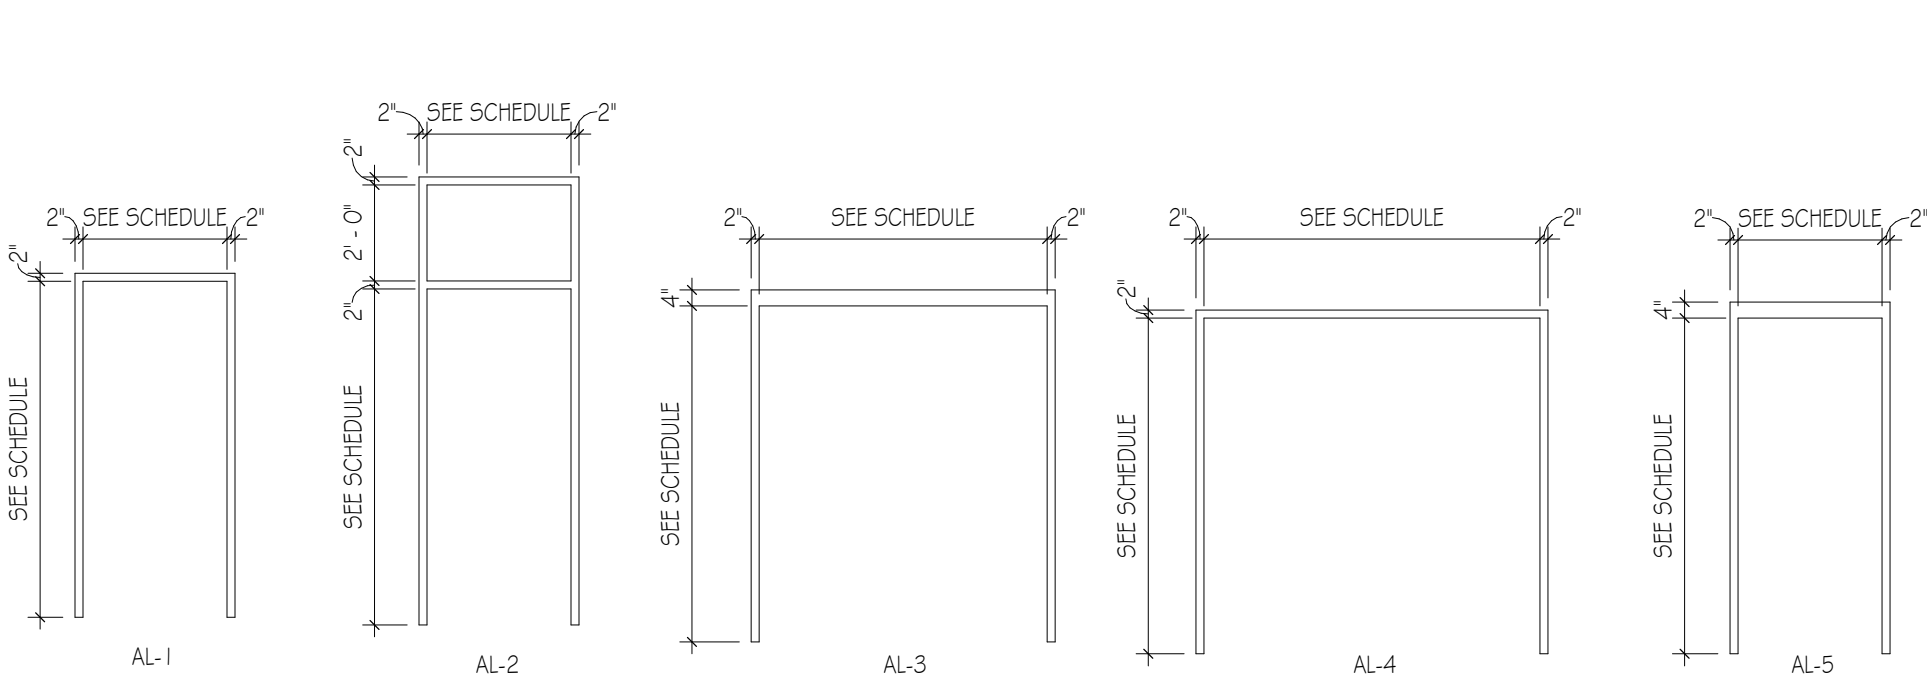


FRAME ELEVATIONS

1/4" = 1'-0"

WINDOW SCHEDULE							
NO.	WIDTH	HEIGHT	MATERIAL	HEAD	JAMB	SILL	NOTES
W1	4' - 8"	4' - 8"					

BORROWED LIGHT SCHEDULE							
NO.	WIDTH	HEIGHT	MATERIAL	HEAD	JAMB	SILL	NOTES
BL1	4' - 0"	4' - 0"					
BL2	5' - 0"	4' - 0"					

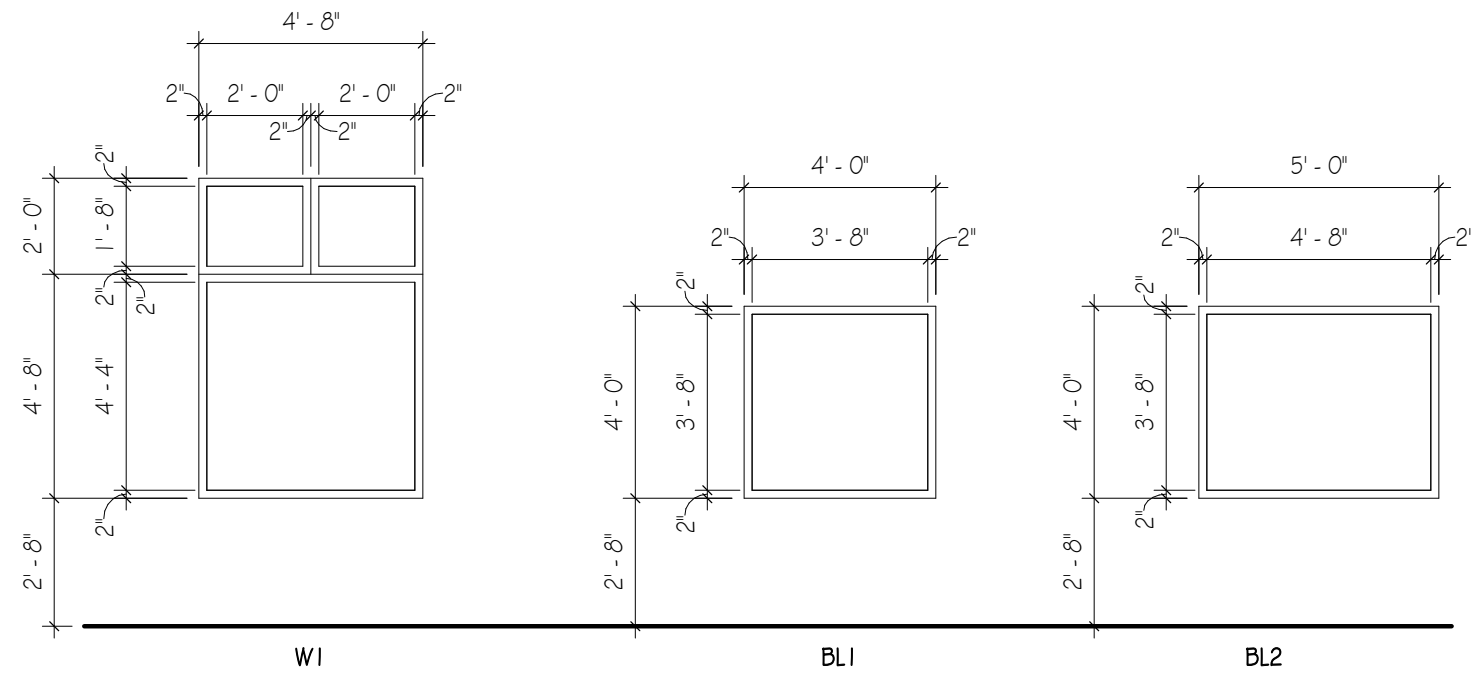

WINDOW ELEVATIONS

1/4" = 1'-0"

MARK	DATE	DESCRIPTION

DRAWN BY: ATB
PM: LP
JOB NO: 19-049
DATE: 01.29.2020





OPENING SCHEDULES
AND DOOR & WINDOW
TYPES




A5.1

NOT FOR CONSTRUCTION - SD

DAIRYLAND POWER COOPERATIVE
PUBLICATION SERVICES
LA CROSSE, WISCONSIN



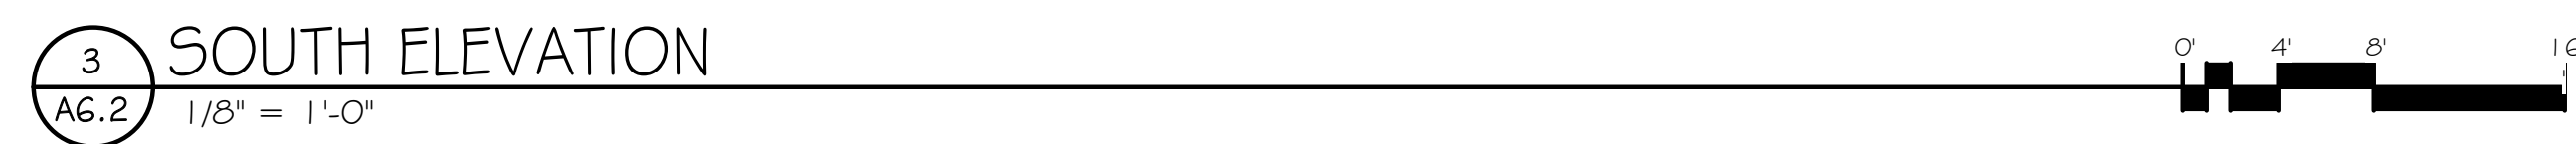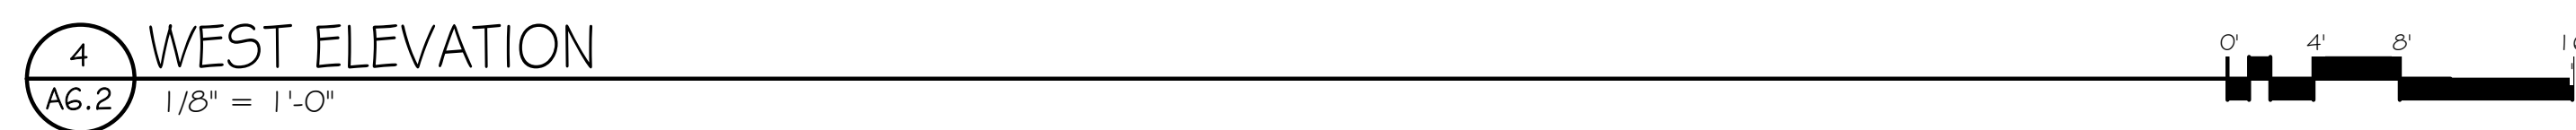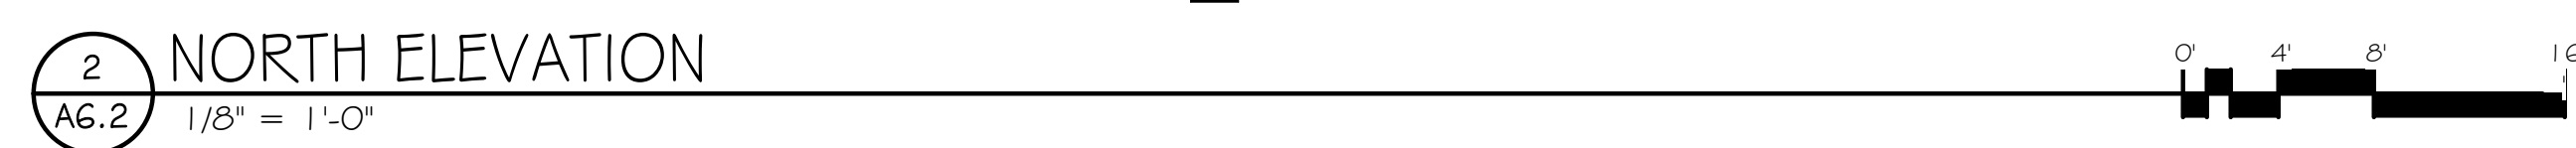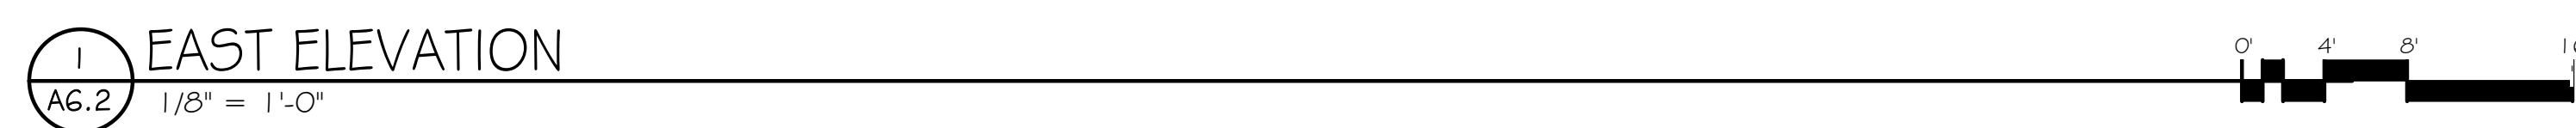


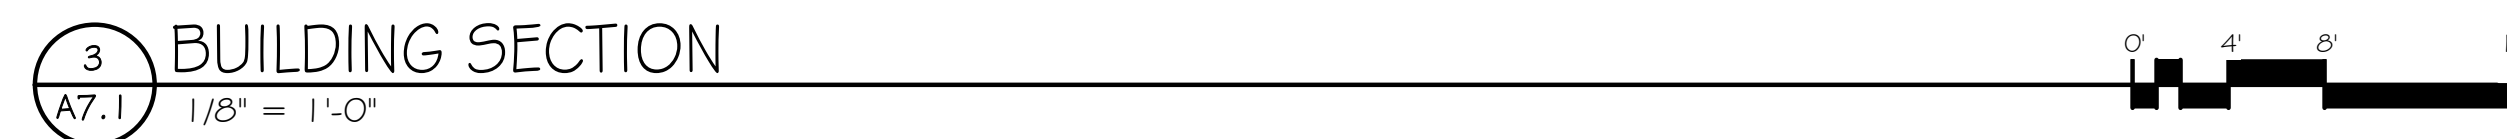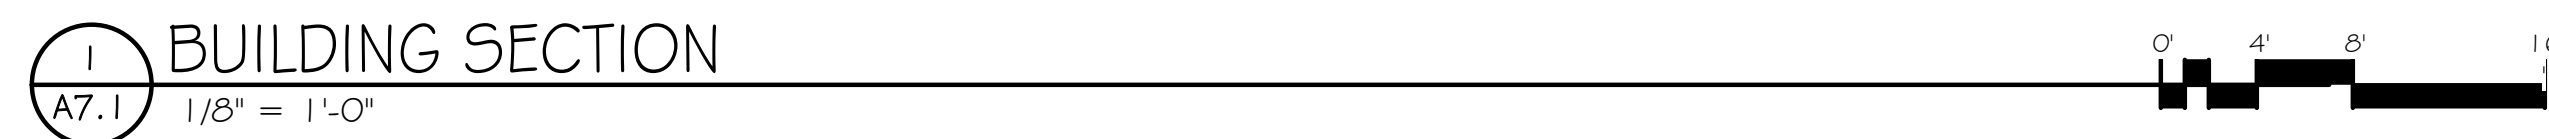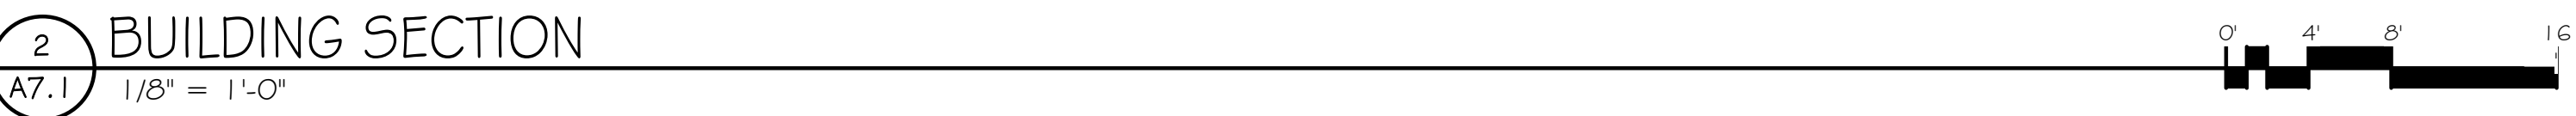[illegible]

A7.1

DAIRYLAND POWER COOPERATIVE
PUBLICATION SERVICES
LA CROSSE, WISCONSIN

PRELIMINARY

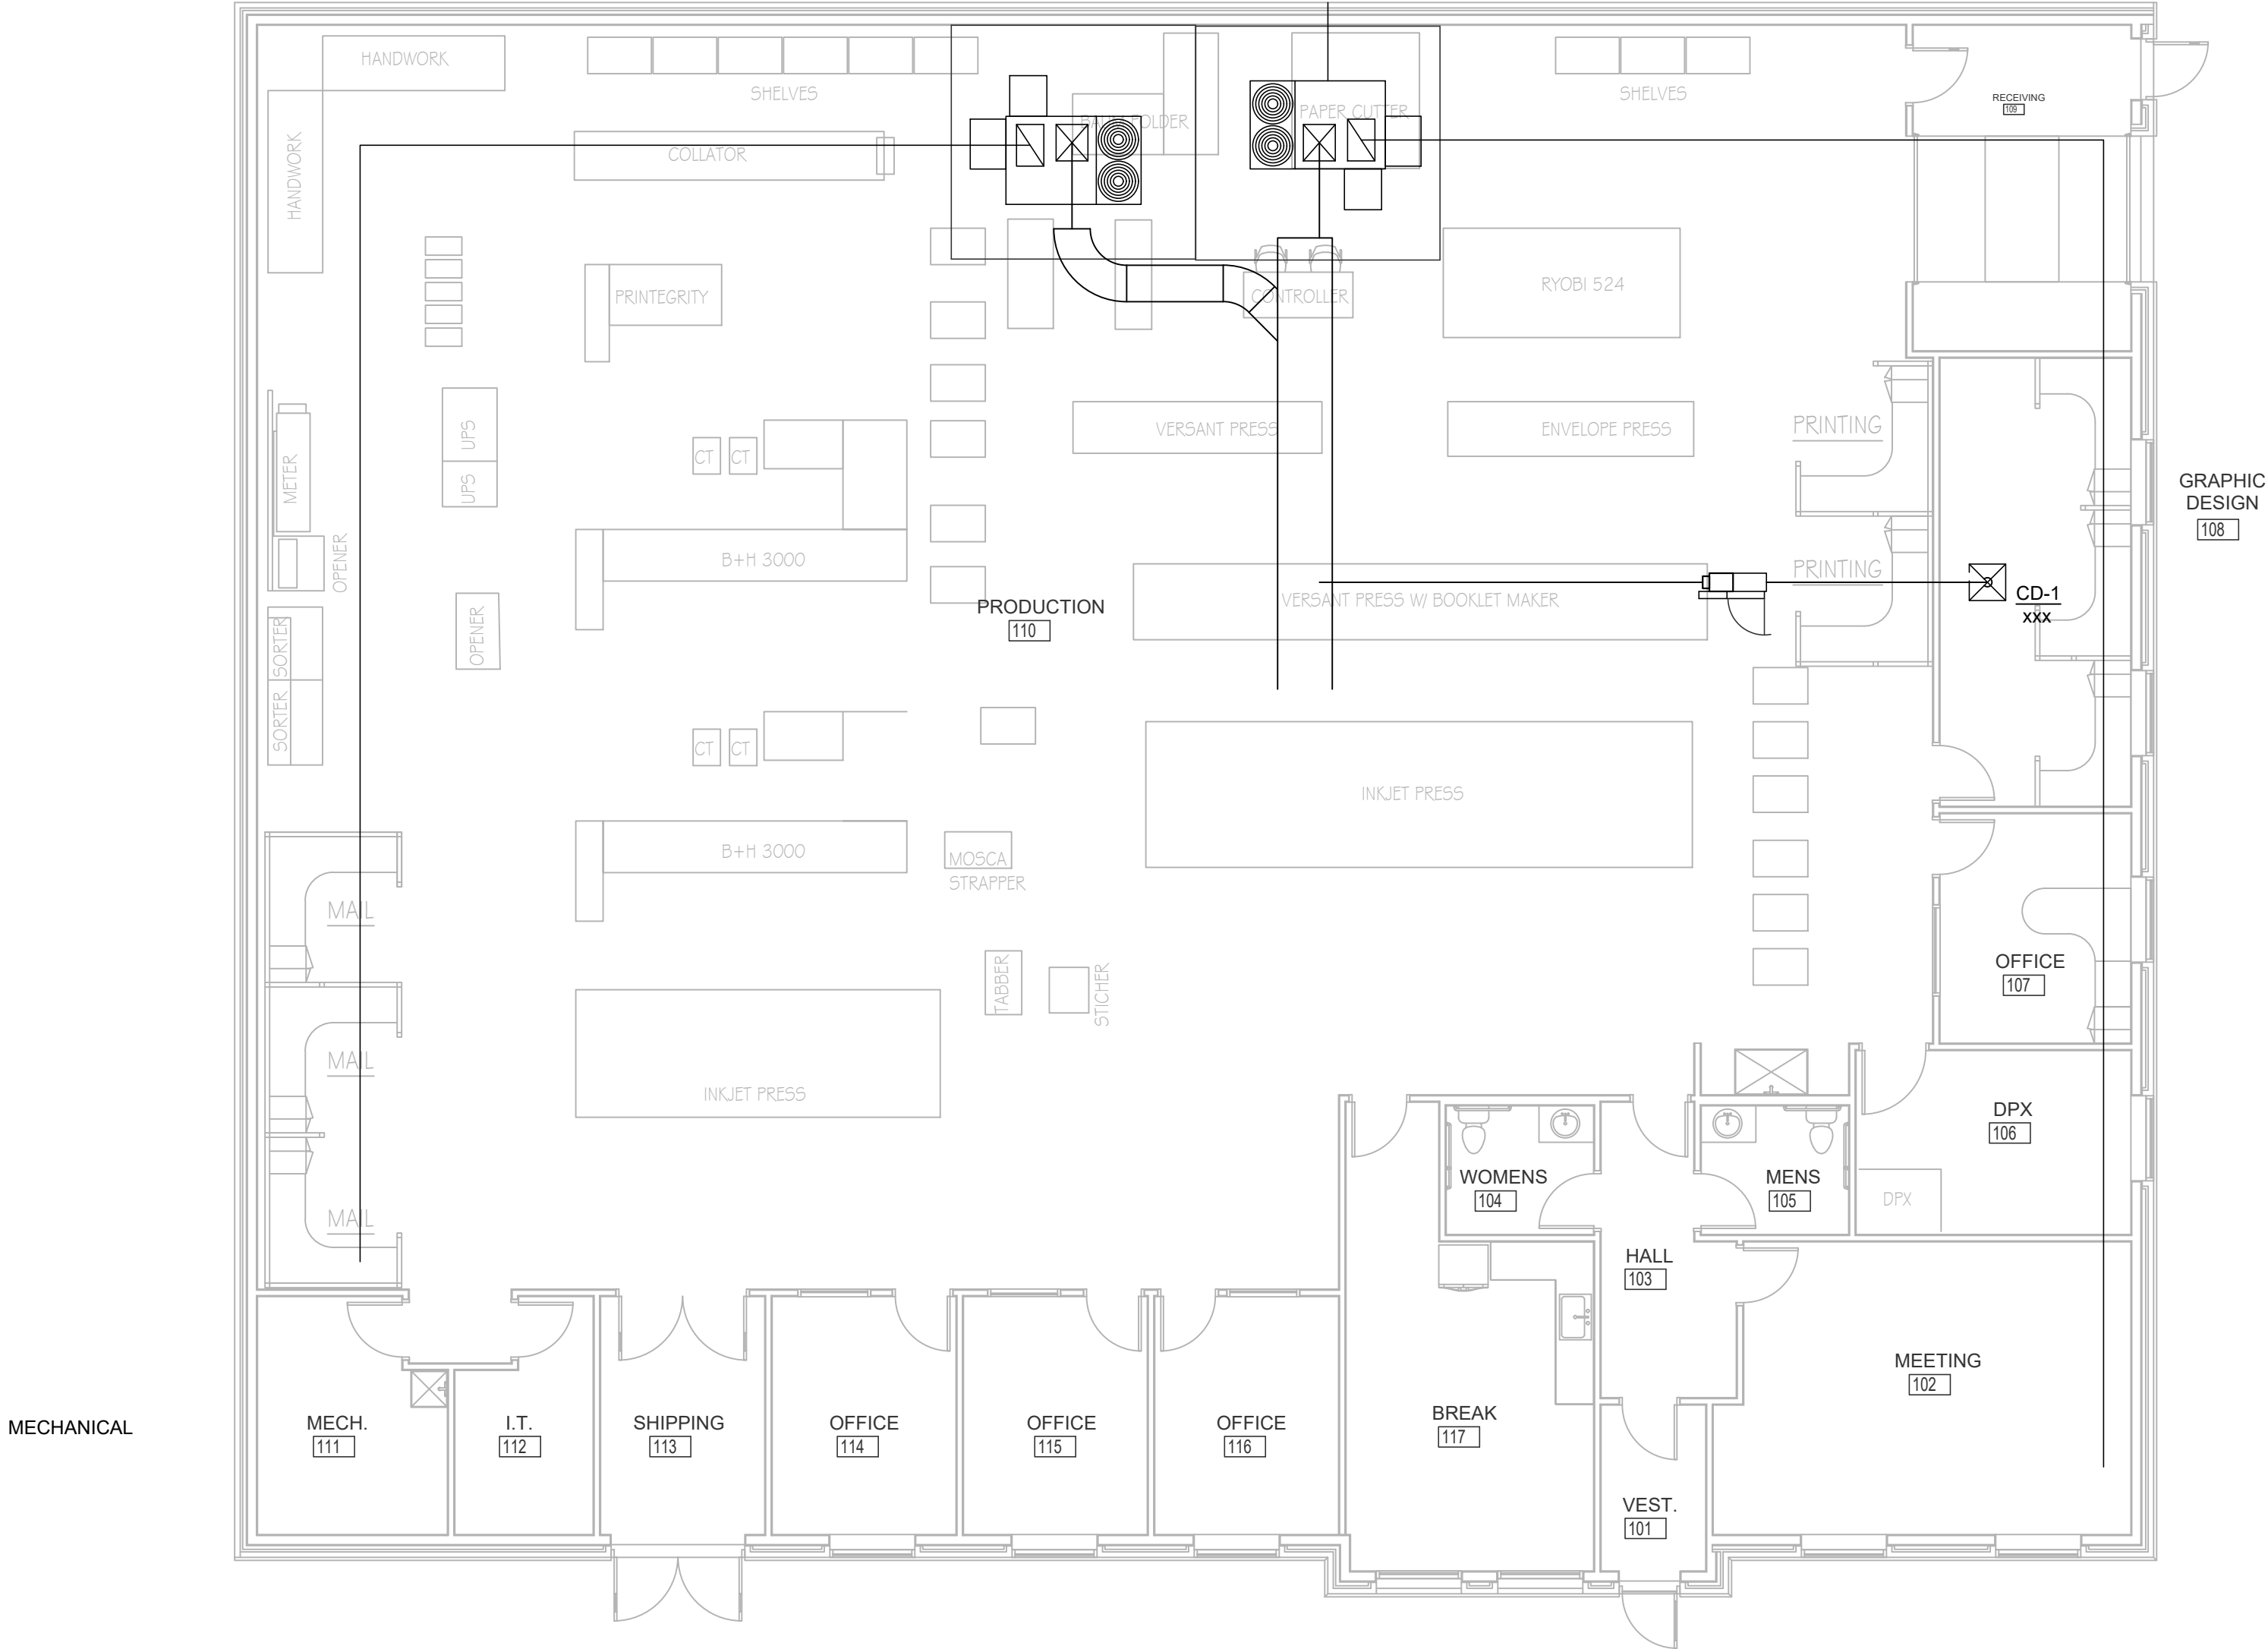

1 FIRST FLOOR PLAN - MECHANICAL
SCALE: 1/8"=1'-0"



1303 Weston Street
La Crosse, WI 54601
Office: 608.788.7500
Fax: 608.788.5355
Email: mbuchner@mmclax.com



EIRSCHELE OFFICES

Mechanical & Environmental Engineering
903 Superior Avenue, Suite 611 Tonawanda, WI 54690
608.372.9292 eirschele@gmail.com

general notes

1. FIELD COORDINATE EXACT LOCATION OF NEW EQUIPMENT WITH OWNER'S REPRESENTATIVE.
2. THE MECHANICAL CONTRACTOR'S WORK SHALL CONFORM TO THE OWNER'S POLICIES ON CONSTRUCTION PROCEDURES.

sheet notes

1. UNLESS NOTED OTHERWISE, DUCTWORK DOWNSTREAM OF AIR TERMINAL SAME SIZE AS OUTLET.

DATE	No.	REVISION



3200 EAST AVE S
LA CROSSE, WI 54602

DAIRYLAND POWER
PUBLICATION
SERVICES

sheet title

FIRST FLOOR PLAN -
MECHANICAL

scale

1/4"=1'-0"

date

JANUARY 24, 2020

drawn by


BEE

project no.


20-001.00

sheet no.

M101

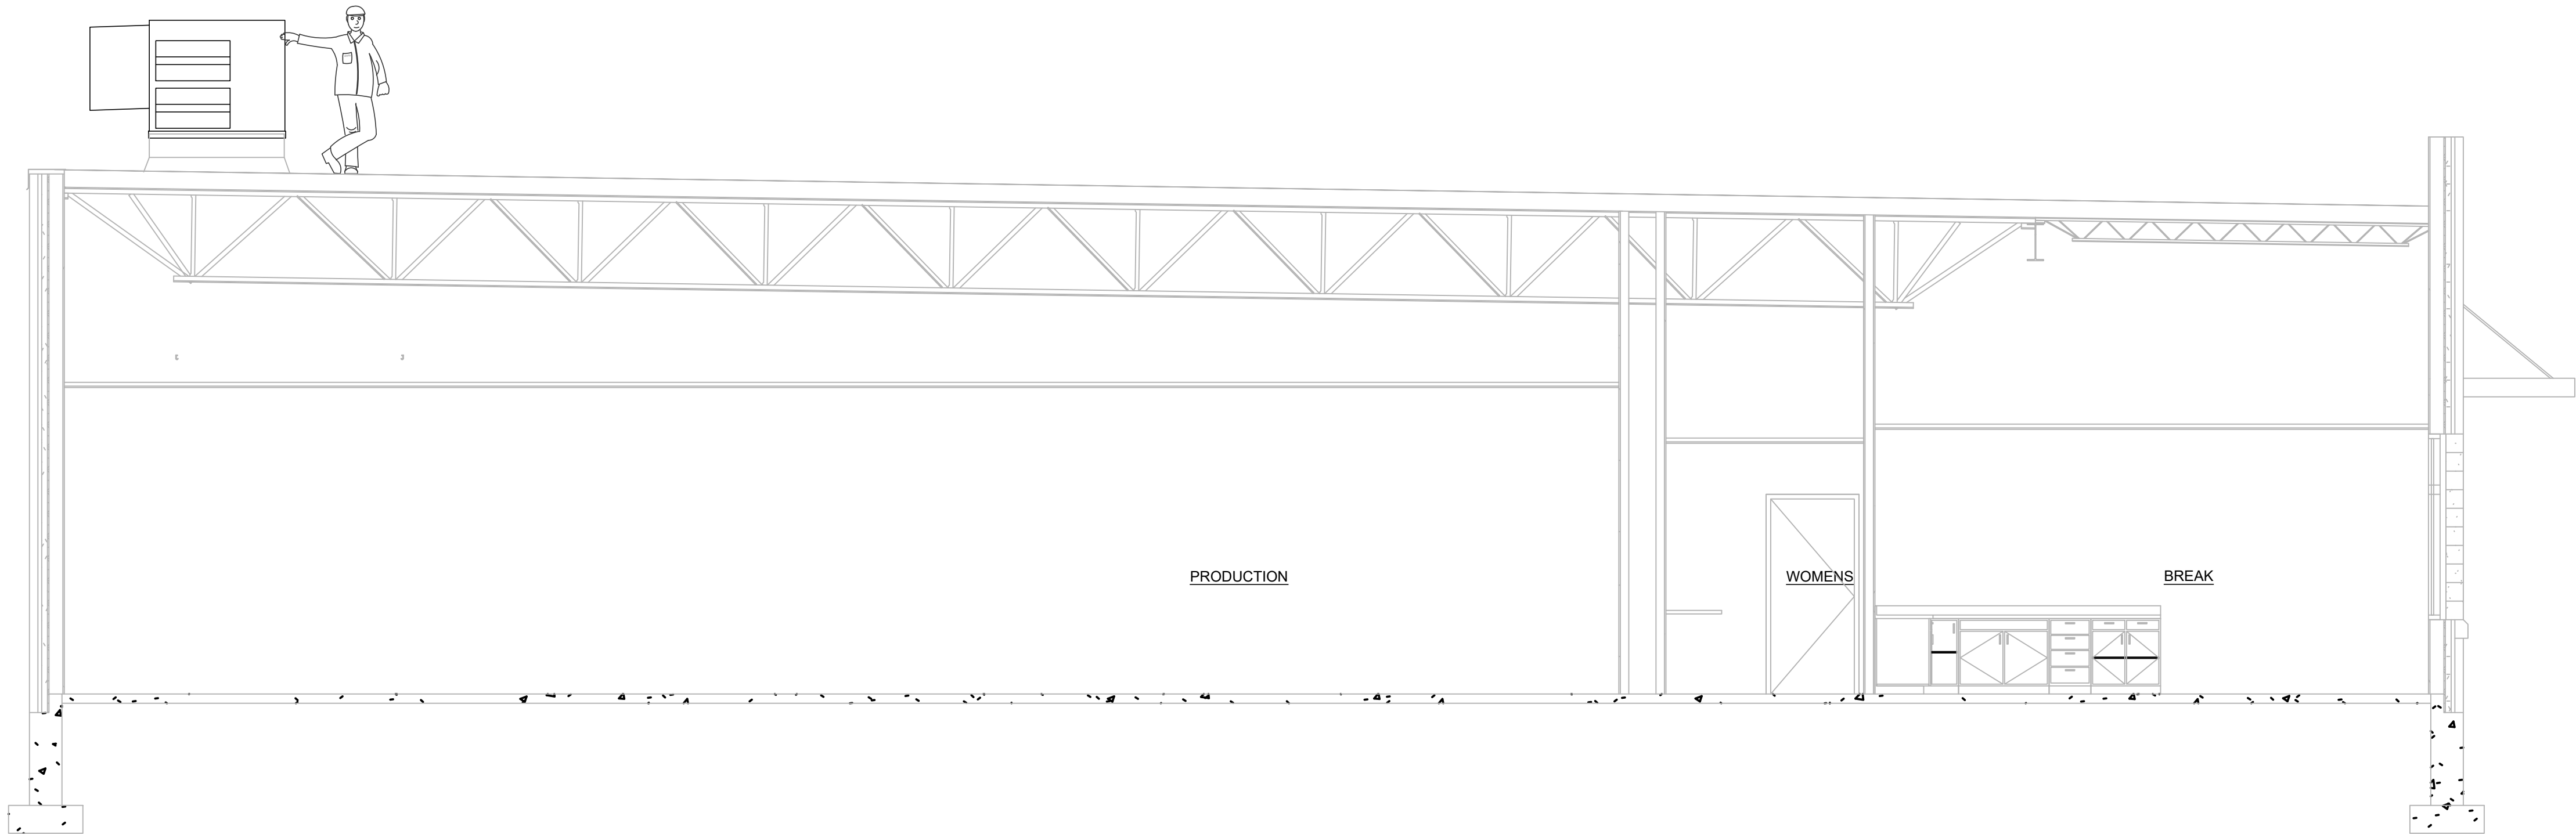

1 SECTION
SCALE: 1/4"=1'-0"

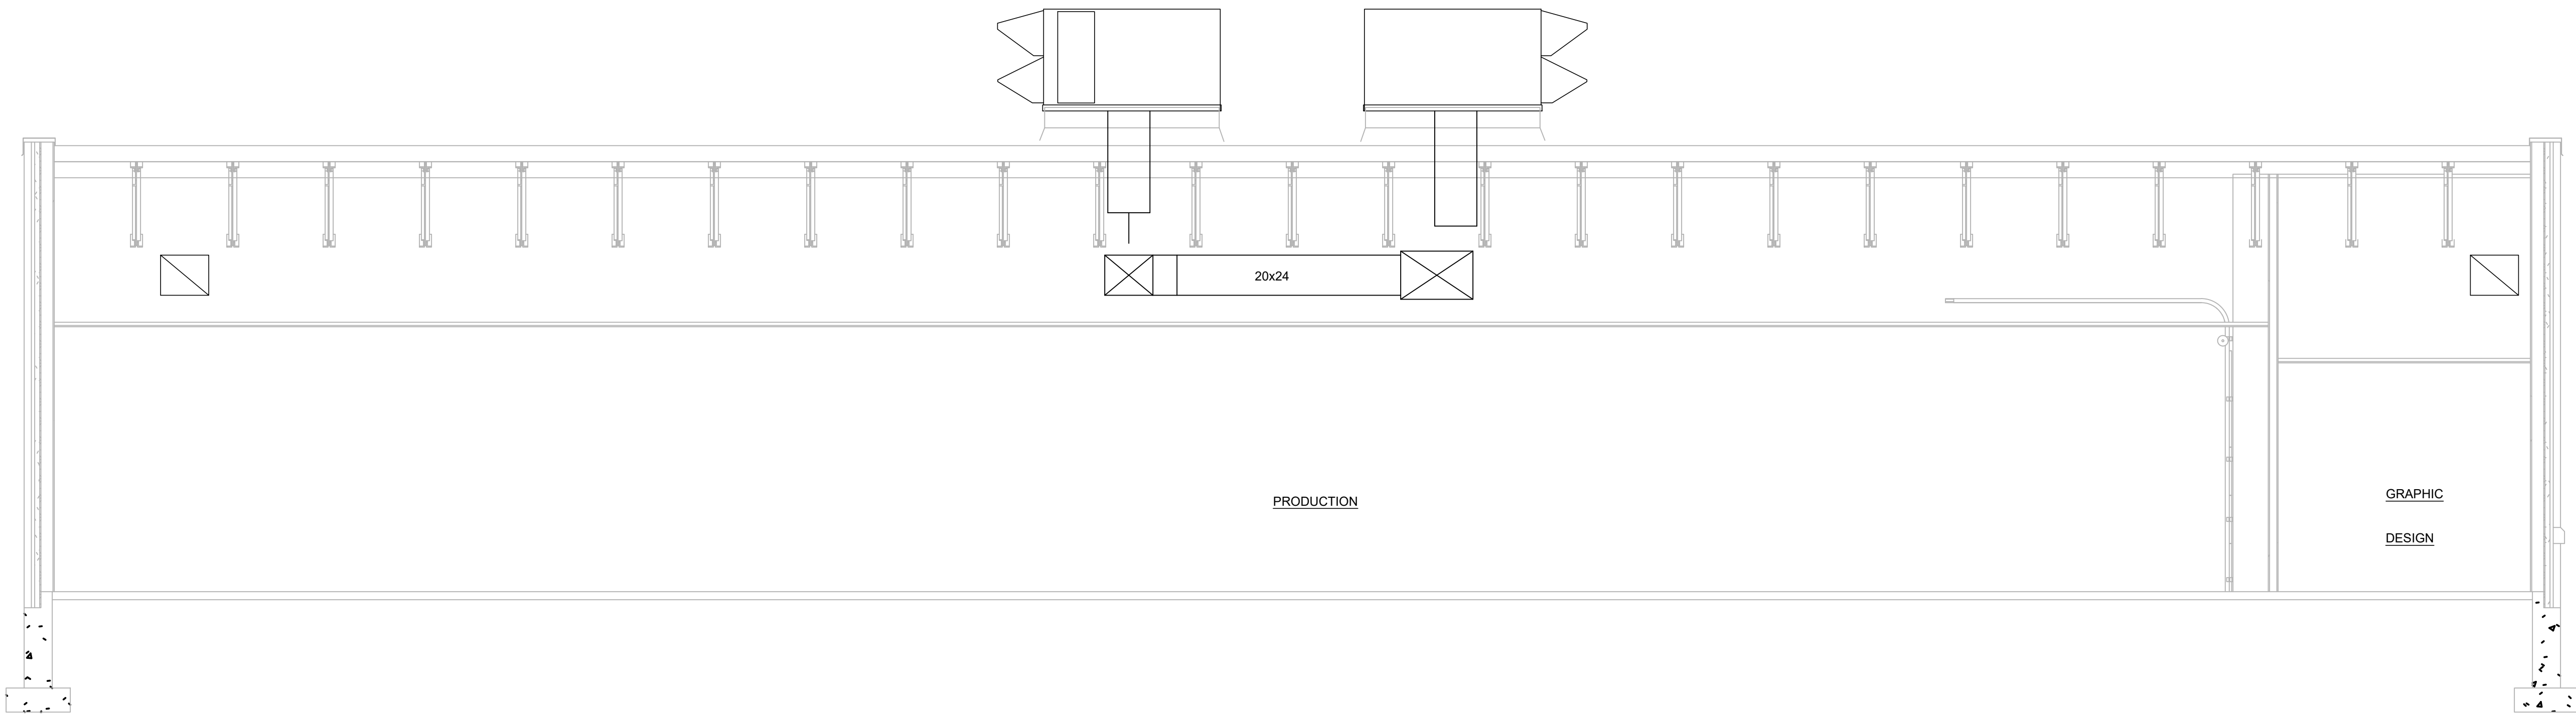

2 SECTION
SCALE: 1/4"=1'-0"

PRELIMINARY



1305 Weston Street
La Crosse, WI 54601
Office: 608.786.7500
Fax: 608.788.5355
Email: mbuchner@mmdax.com



EIRSCHLE OFFICES
Mechanical & Environmental Engineering
903 Superior Avenue, Suite 6 | Tomah, WI 54660
608.372.9292 eirschle@gmail.com

general notes

sheet notes

DATE	No.	REVISION



3200 EAST AVE S
LA CROSSE, WI 54602

DAIRYLAND POWER
PUBLICATION
SERVICES

Sheet Title
SECTIONS

Scale
1/4"=1'-0"

Date
JANUARY 24, 2020 BEE

Project No.
20-001.00

Sheet No.
M501

LIGHTING RECESSED FLUORESCENT FIXTURE. SEE LIGHTING FIXTURE SCHEDULE. 'A' INDICATES FIXTURE TYPE. 'b' INDICATES SWITCH CONTROL. SURFACE FLUORESCENT FIXTURE. SEE LIGHTING FIXTURE SCHEDULE. 'A' INDICATES FIXTURE TYPE. 'b' INDICATES SWITCH CONTROL. WALL BRACKET LIGHTING FIXTURE. SEE LIGHTING FIXTURE SCHEDULE. 'A' INDICATES FIXTURE TYPE. SURFACE-MOUNTED LIGHTING FIXTURE. SEE LIGHTING FIXTURE SCHEDULE FOR DESCRIPTION AND MANUFACTURER. 'A' INDICATES FIXTURE TYPE. PENDANT-MOUNTED LIGHTING FIXTURE. 'A' INDICATES FIXTURE TYPE. RECESS-MOUNTED DOWNLIGHT-SEE LIGHTING FIXTURE SCHEDULE FOR DESCRIPTION AND MANUFACTURER. 'A' INDICATES FIXTURE TYPE. RECESSED WALL-WASH OR SPOTLIGHTING FIXTURE, DIRECTION AS INDICATED BY ARROW. 'A' INDICATES FIXTURE TYPE. WALL-MOUNTED FIXTURE-SEE FIXTURE SCHEDULE. 'A' INDICATES FIXTURE TYPE. POLE MOUNTED LIGHT FIXTURE. FLUORESCENT STRIP FIXTURE. 'A' INDICATES FIXTURE TYPE. TRACK LIGHTING FIXTURE WITH NUMBER OF FIXTURES INDICATED. LIGHTING FIXTURES ON EMERGENCY POWER SOURCE. 'A' INDICATES FIXTURE TYPE. 'NL' INDICATES IF FIXTURE IS TO BE ON AT ALL TIMES. EMERGENCY LIGHTING UNIT WITH SELF-CONTAINED BATTERY AND HEADS AS INDICATED. WG = WIRE GUARD PROTECTED. CEILING MOUNTED EMERGENCY LIGHTING UNIT WITH SELF-CONTAINED BATTERY AND HEADS AS INDICATED. WG = WIRE GUARD PROTECTED. EMERGENCY LIGHTING UNIT REMOTE HEAD. EXIT LIGHT FIXTURE, NUMBER OF FACES AND DIRECTIONAL ARROWS AS INDICATED. WG = WIRE GUARD PROTECTED. COMBINATION EXIT LIGHT AND EMERGENCY LIGHTING UNIT. CEILING FAN.	RACEWAY NEUTRAL CONDUCTOR (TYP.) POWER CONDUCTOR (TYP.) BRANCH CIRCUIT CARRYING SWITCHED CONDUCTORS BRANCH CIRCUIT WITHOUT SWITCHED CONDUCTORS LOW VOLTAGE CIRCUIT GROUND OR NEUTRAL CONNECTION AS INDICATED JUNCTION BOX UNDERFLOOR DUCT AND JUNCTION BOX EMPTY OUTLET BOX WITH BLANK COVER PLATE, SIZE AND TYPE AS INDICATED HOME RUN TO PANEL 'L1' CIRCUIT #2 VIA RELAY #1 IN LIGHTING CONTROL PANEL LCP=1. SEE PANELBOARD & LIGHTING CONTROL RELAY SCHEDULES HOME RUN DIRECTLY TO PANEL 'L1' CIRCUIT #2 CONDUIT ROUTED ABOVE GROUND. SIZE AND TYPE AS INDICATED. CONDUIT ROUTED BELOW GROUND OR FLOOR SLAB. SIZE AND TYPE AS INDICATED. CONDUIT TURNED UP. CONDUIT TURNED DOWN. CABLE TRAY. BUS DUCT. ### INDICATES AMPACITY. CONDUIT SEAL-OFF. NOTE: ALL BRANCH CIRCUITS TO CARRY SEPARATE GROUNDING CONDUCTOR REGARDLESS OF CONDUIT MATERIAL.	CONTROL DEVICES CONTROL PANEL. TEMPERATURE CONTROL PANEL. TIME CLOCK. PHOTOCELL. THERMOSTAT. RELAY. DOOR BELL. BUZZER. PUSH BUTTON REMOTE CONTROL STATION.	MOTORS AND EQUIPMENT MAGNETIC MOTOR STARTER. COMBINATION DISCONNECT SWITCH AND STARTER. MANUAL MOTOR SWITCH, 3-PHASE WITH OVERLOADS AND PILOT LIGHT. MOTOR. SEE POWER AND EQUIPMENT SCHEDULE. EQUIPMENT CONNECTION POINT. SEE POWER AND EQUIPMENT SCHEDULE.
RECEPTACLES DUPLEX RECEPTACLE WITH 3 WIRE GROUNDING. SPECIAL PURPOSE DUPLEX RECEPTACLE. LETTERS INDICATE FUNCTION - CIRCUIT RECEPT, AS INDICATED. AC = ABOVE COUNTER MOUNTING HEIGHT D = DEDICATED USE RECEPTACLE GFCI = RECEPTACLE WITH GROUND FAULT INTERRUPTION (GFI) PROTECTION IG = ISOLATED GROUND TVSS = TRANSIENT VOLTAGE SURGE SUPPRESSING X = EXISTING OUTLET BOX W/ NEW RECEPT. WP = WEATHERPROOF FOUR-PLEX (DOUBLE DUPLEX) RECEPTACLE. SINGLE RECEPTACLE. THREE-WIRE RECEPTACLE. HALF-SWITCHED RECEPTACLE. FLOOR MOUNTED RECEPTACLE. FLOOR MOUNTED DUPLEX RECEPTACLE W/ SPACE FOR DATA RECEPTACLES. SPECIAL PURPOSE OUTLET, TYPE AS INDICATED. SURFACE-MOUNTED "PLUG MOLD"; TYPE, MOUNTING HEIGHT & RECEPT. LOCATIONS AS INDICATED. POWER POLE. CORD AND PLUG POWER CONNECTION.	SWITCHES WALL SWITCH, SINGLE POLE SINGLE THROW (SPST) LETTER INDICATES SPECIAL FEATURE. 3 = 3-WAY SWITCH 4 = 4-WAY SWITCH D = DIMMER DPST = DOUBLE POLE SINGLE THROW F = FUSED H/C = HEAT/COOL M = KEY MC = MOMENTARY CONTACT SWITCH OS = OCCUPANCY SENSING P = PILOT LIGHT SM = SURFACE-MOUNTED T = TIMER SWITCH, MFG. & MODEL # AS INDICATED TP = MANUAL MOTOR SWITCH, SINGLE PHASE WITH OVERLOADS AND PILOT LIGHT V = VOLUME CONTROLS VS = 120 VOLT, 20 AMP MOTOR RATED VARIABLE SPEED SWITCH WP = WEATHER PROOF X = EXISTING OUTLET BOX WITH NEW SWITCH NOTE: LOWER CASE LETTERS INDICATE MULTIPLE LEVELS OF LIGHT CONTROL OF FIXTURES WITH CORRESPONDING LETTERS INDICATED ON FIXTURES. WALL SWITCH FOR LIGHTING CONTROL SYSTEM. # INDICATES UNIQUE SWITCH DESIGNATION AS SCHEDULED. CEILING MOUNTED OCCUPANCY SENSOR. OCCUPANCY SENSOR POWER PACK.	FIRE ALARM SYSTEM NOTES: MOUNTING HEIGHTS FOR FIRE ALARM DEVICES: MANUAL PULL STATION = 48" HORN/STROBE = 80" STROBE LIGHTS = 80" MAGNETIC DOOR HOLDERS = AS SPECIFIED FIRE ALARM CONTROL PANEL(FACP) FIRE ALARM ANNUNCIATOR. MANUAL PULL STATION. DUCT SMOKE DETECTOR. SMOKE DETECTOR. SMOKE DETECTOR WITH AUXILIARY CONTACTS. HEAT DETECTOR. HEAT DETECTOR WITH AUXILIARY CONTACTS. CARBON MONOXIDE DETECTOR. WEATHER PROOF FIRE HORN/STROBE. X = EXTERIOR. F.A. HORN. F.A. AUDIO / VISUAL (HORN/STROBE). WG = WIRE GUARD PROTECTED. END OF LINE RESISTOR. STROBE LIGHT. GAS DETECTOR. MAGNETIC DOOR HOLDER. SPRINKLER SYSTEM WATER FLOW SWITCH. SPRINKLER SYSTEM TAMPER SWITCH. RESCUE ASSISTANCE CALL STATION. RESCUE ASSISTANCE ANNUNCIATOR.	SOUND SYSTEM SPEAKER ONLY (WALL-MOUNTED). SPEAKER ONLY (CEILING-MOUNTED). LOUD SPEAKER. MICROPHONE JACK. FLOOR-MOUNTED MICROPHONE JACK. VOLUME CONTROLS. SOUND SYSTEM CONSOLE. SOUND SYSTEM CONTROL PANEL WITH AMPLIFIER.
RECEPTACLES DUPLEX RECEPTACLE WITH 3 WIRE GROUNDING. SPECIAL PURPOSE DUPLEX RECEPTACLE. LETTERS INDICATE FUNCTION - CIRCUIT RECEPT, AS INDICATED. AC = ABOVE COUNTER MOUNTING HEIGHT D = DEDICATED USE RECEPTACLE GFCI = RECEPTACLE WITH GROUND FAULT INTERRUPTION (GFI) PROTECTION IG = ISOLATED GROUND TVSS = TRANSIENT VOLTAGE SURGE SUPPRESSING X = EXISTING OUTLET BOX W/ NEW RECEPT. WP = WEATHERPROOF FOUR-PLEX (DOUBLE DUPLEX) RECEPTACLE. SINGLE RECEPTACLE. THREE-WIRE RECEPTACLE. HALF-SWITCHED RECEPTACLE. FLOOR MOUNTED RECEPTACLE. FLOOR MOUNTED DUPLEX RECEPTACLE W/ SPACE FOR DATA RECEPTACLES. SPECIAL PURPOSE OUTLET, TYPE AS INDICATED. SURFACE-MOUNTED "PLUG MOLD"; TYPE, MOUNTING HEIGHT & RECEPT. LOCATIONS AS INDICATED. POWER POLE. CORD AND PLUG POWER CONNECTION.	DISTRIBUTION EQUIPMENT POWER DISTRIBUTION PANEL. BRANCH CIRCUIT PANELBOARD. ELECTRICAL METER SOCKET. TRANSFORMER. SIZE AS INDICATED. DISCONNECT SWITCH, NON-FUSED. DISCONNECT SWITCH, FUSED. MOTOR CONTROL CENTER. POWER/LIGHTING CONTACTOR.	DATA AND COMMUNICATION EQUIPMENT DATA/COMMUNICATION BOARD (TTB) 3/4" THICK, GRADE AC PLYWOOD. HEIGHT AND WIDTH AS INDICATED. TELECOMMUNICATIONS OUTLET. NUMBER INDICATES 1-DATA JACK, 1-PHONE JACK.	



galileo
CONSULTING GROUP

290 EAST AVENUE, SUITE 400, 102
LA CROSSE, WISCONSIN 54601
PHONE: (608) 787-9196 FAX: (608) 787-9975
E-MAIL: galileo@comcast.net


Electrical Contractor:
T.D. Padesky Electric, Inc.
Cunningham Street
La Crosse, Wisconsin 54603

DAIRYLAND POWER
PRINT SERVICES
La Crosse, Wisconsin 54601

[illegible]

LIGHTING CIRCUITRY


Room No.	Home Run to Panel	Panel Circuit
(All Exit Lights)	Panel A	1
101	Panel A	2
102	Panel A	2
103	Panel A	3
104	Panel A	3
105	Panel A	3
106	Panel A	3
107	Panel A	3
108	Panel A	3
109	Panel A	3
110	Panel A	3
111	Panel A	1
112	Panel A	4
113	Panel A	4
114	Panel A	4
115	Panel A	4
116	Panel A	5
117	Panel A	4
118	Panel A	4
119		
120	Panel A	6
121	Panel A	4
122	Panel A	4
123	Panel A	4
124	Panel A	2
125	Panel X	1
126		
127	Panel A	Re-use existing Home Run
128	Panel A	Re-use existing Home Run
201	Existing Panel	Existing Lighting Circuit
202	Existing Panel	Existing Lighting Circuit
203	Existing Panel	Existing Lighting Circuit
203A	Existing Panel	Existing Lighting Circuit
204	Existing Panel	Existing Lighting Circuit
205	Existing Panel	Existing Lighting Circuit
206	Existing Panel	Existing Lighting Circuit
207	Existing Panel	Existing Lighting Circuit

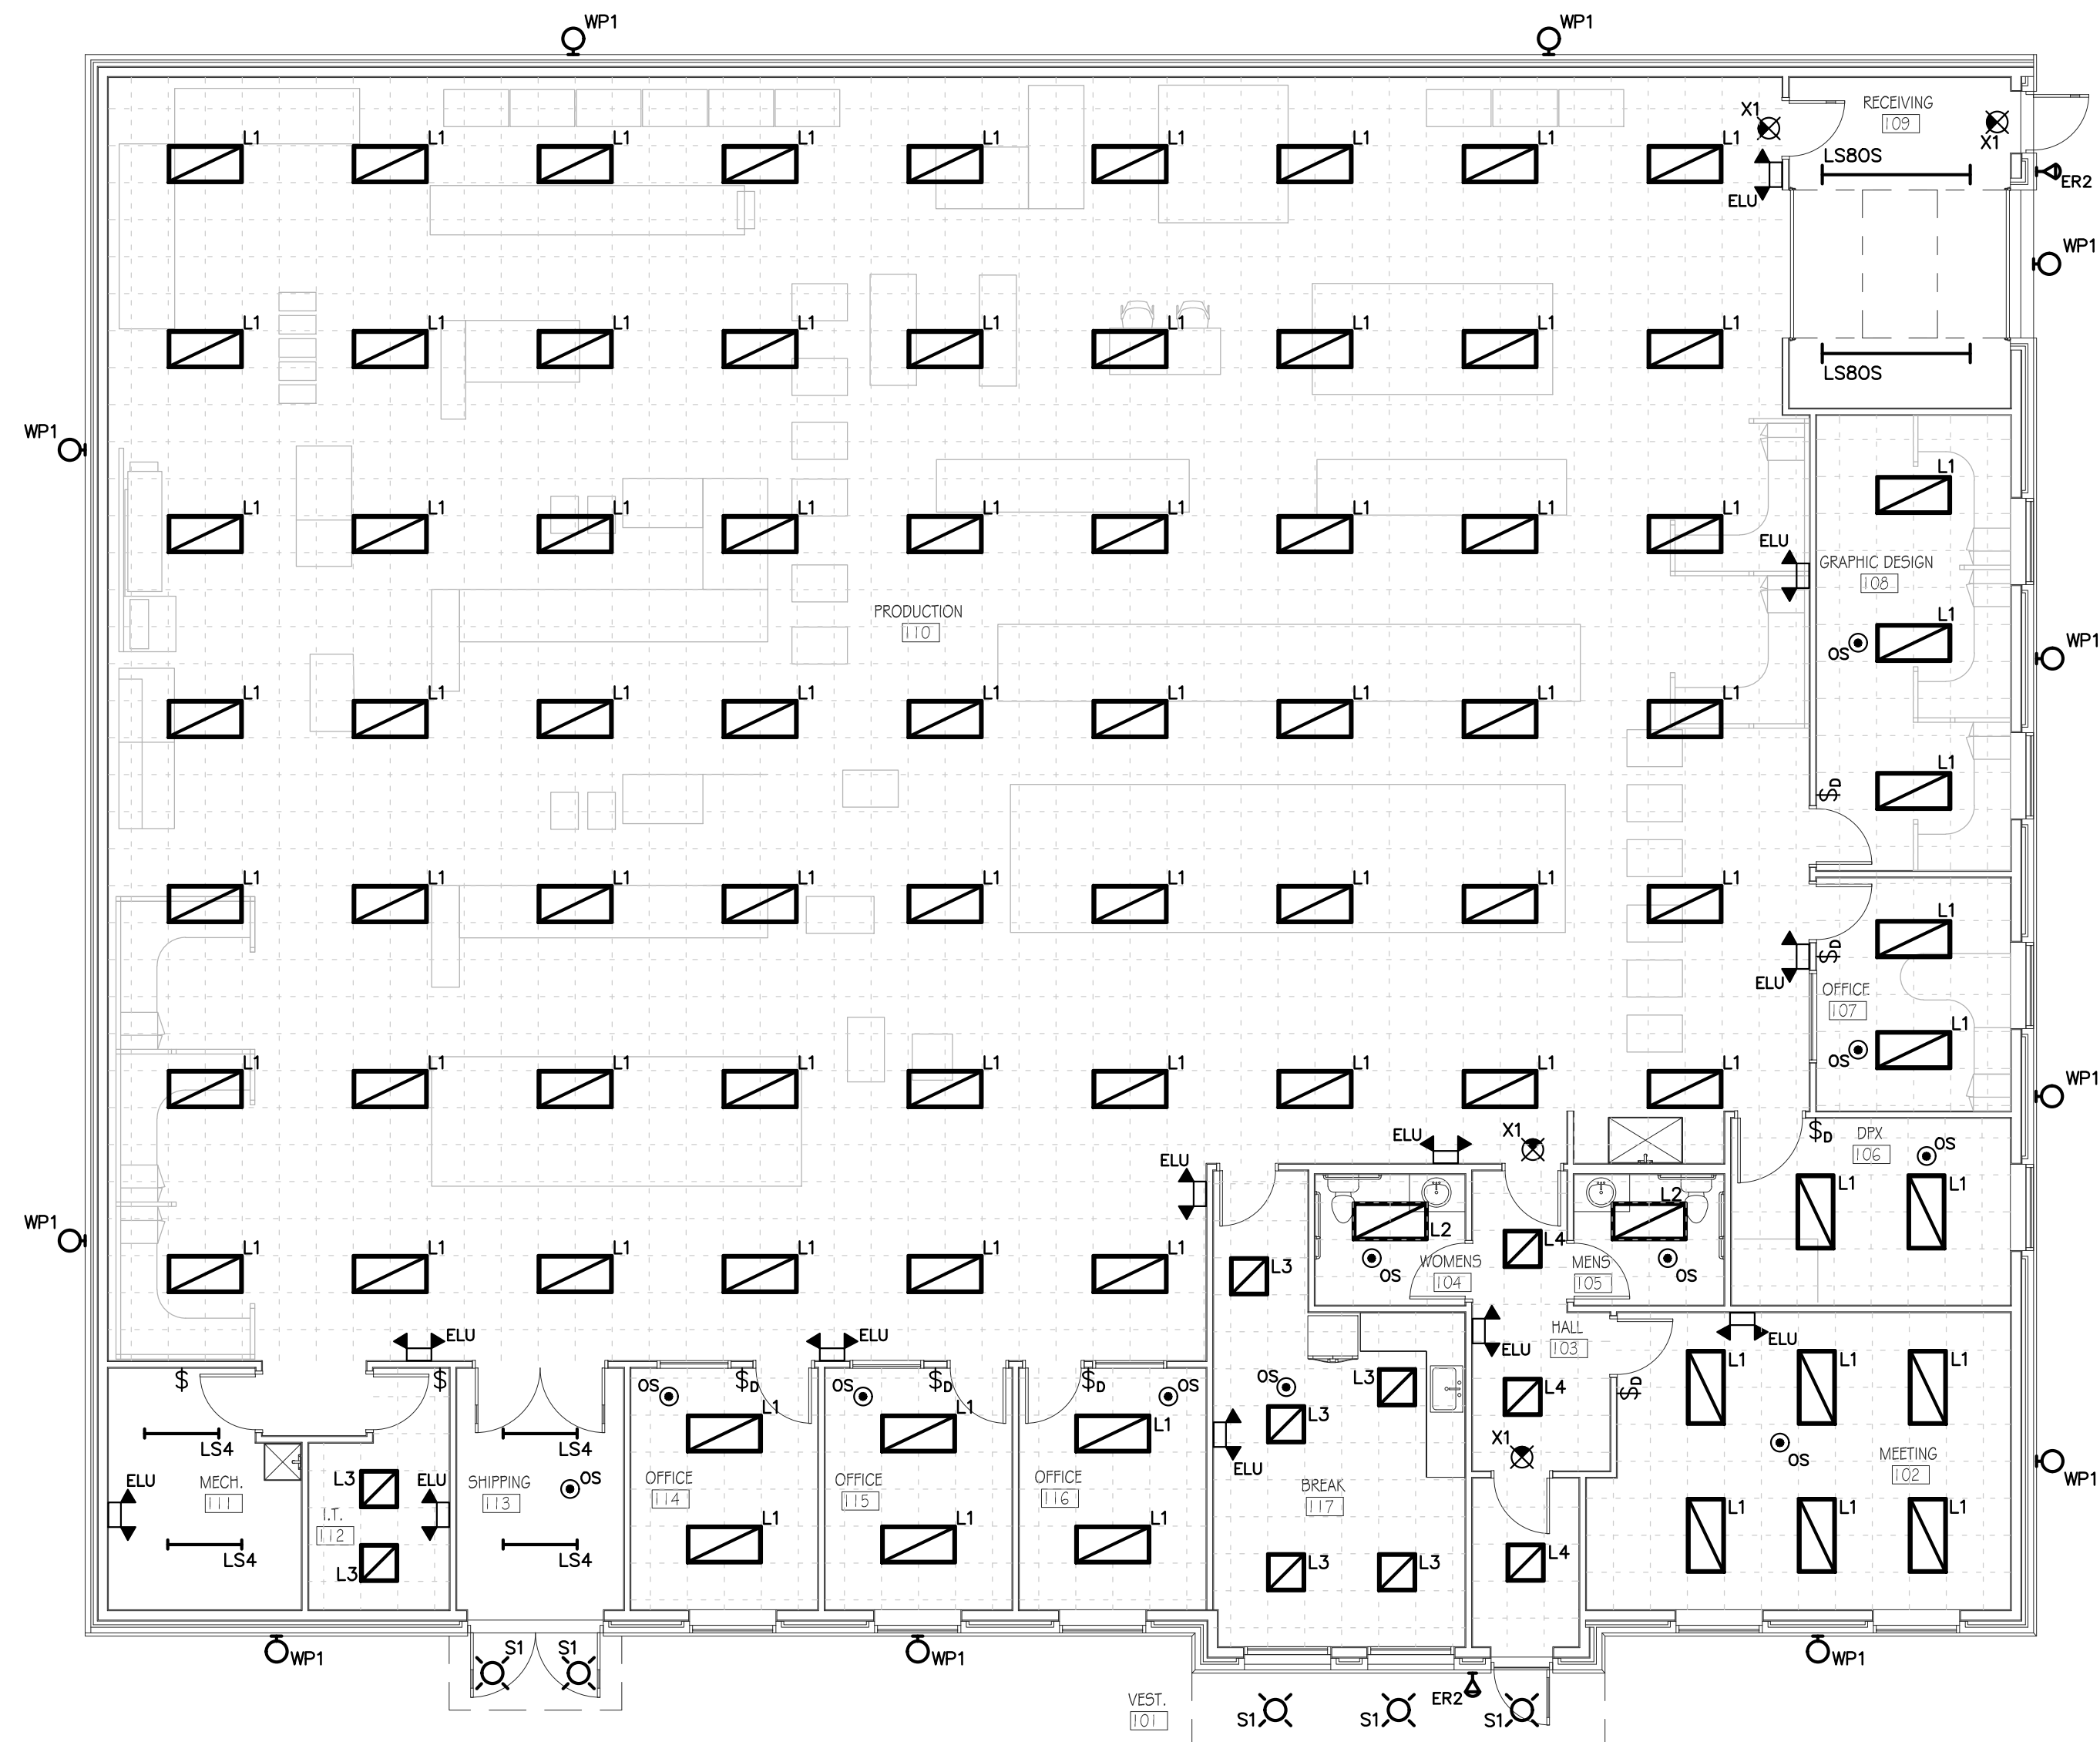

ELECTRICAL LIGHTING NOTES

A

1 FIRST FLOOR NEW LIGHTING PLAN
SCALE: $\frac{1}{8}" = 1'-0"$

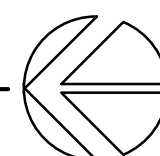


25% DESIGN


[illegible]

E2

DAIRYLAND POWER
PRINT SERVICES
La Crosse, Wisconsin 54601


Electrical Contractor:
T.D. Padesky Electric, Inc.
Cunningham Street
La Crosse, Wisconsin 54603

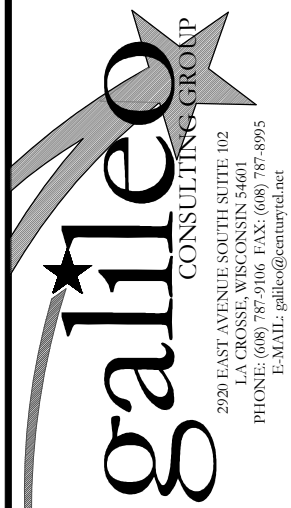

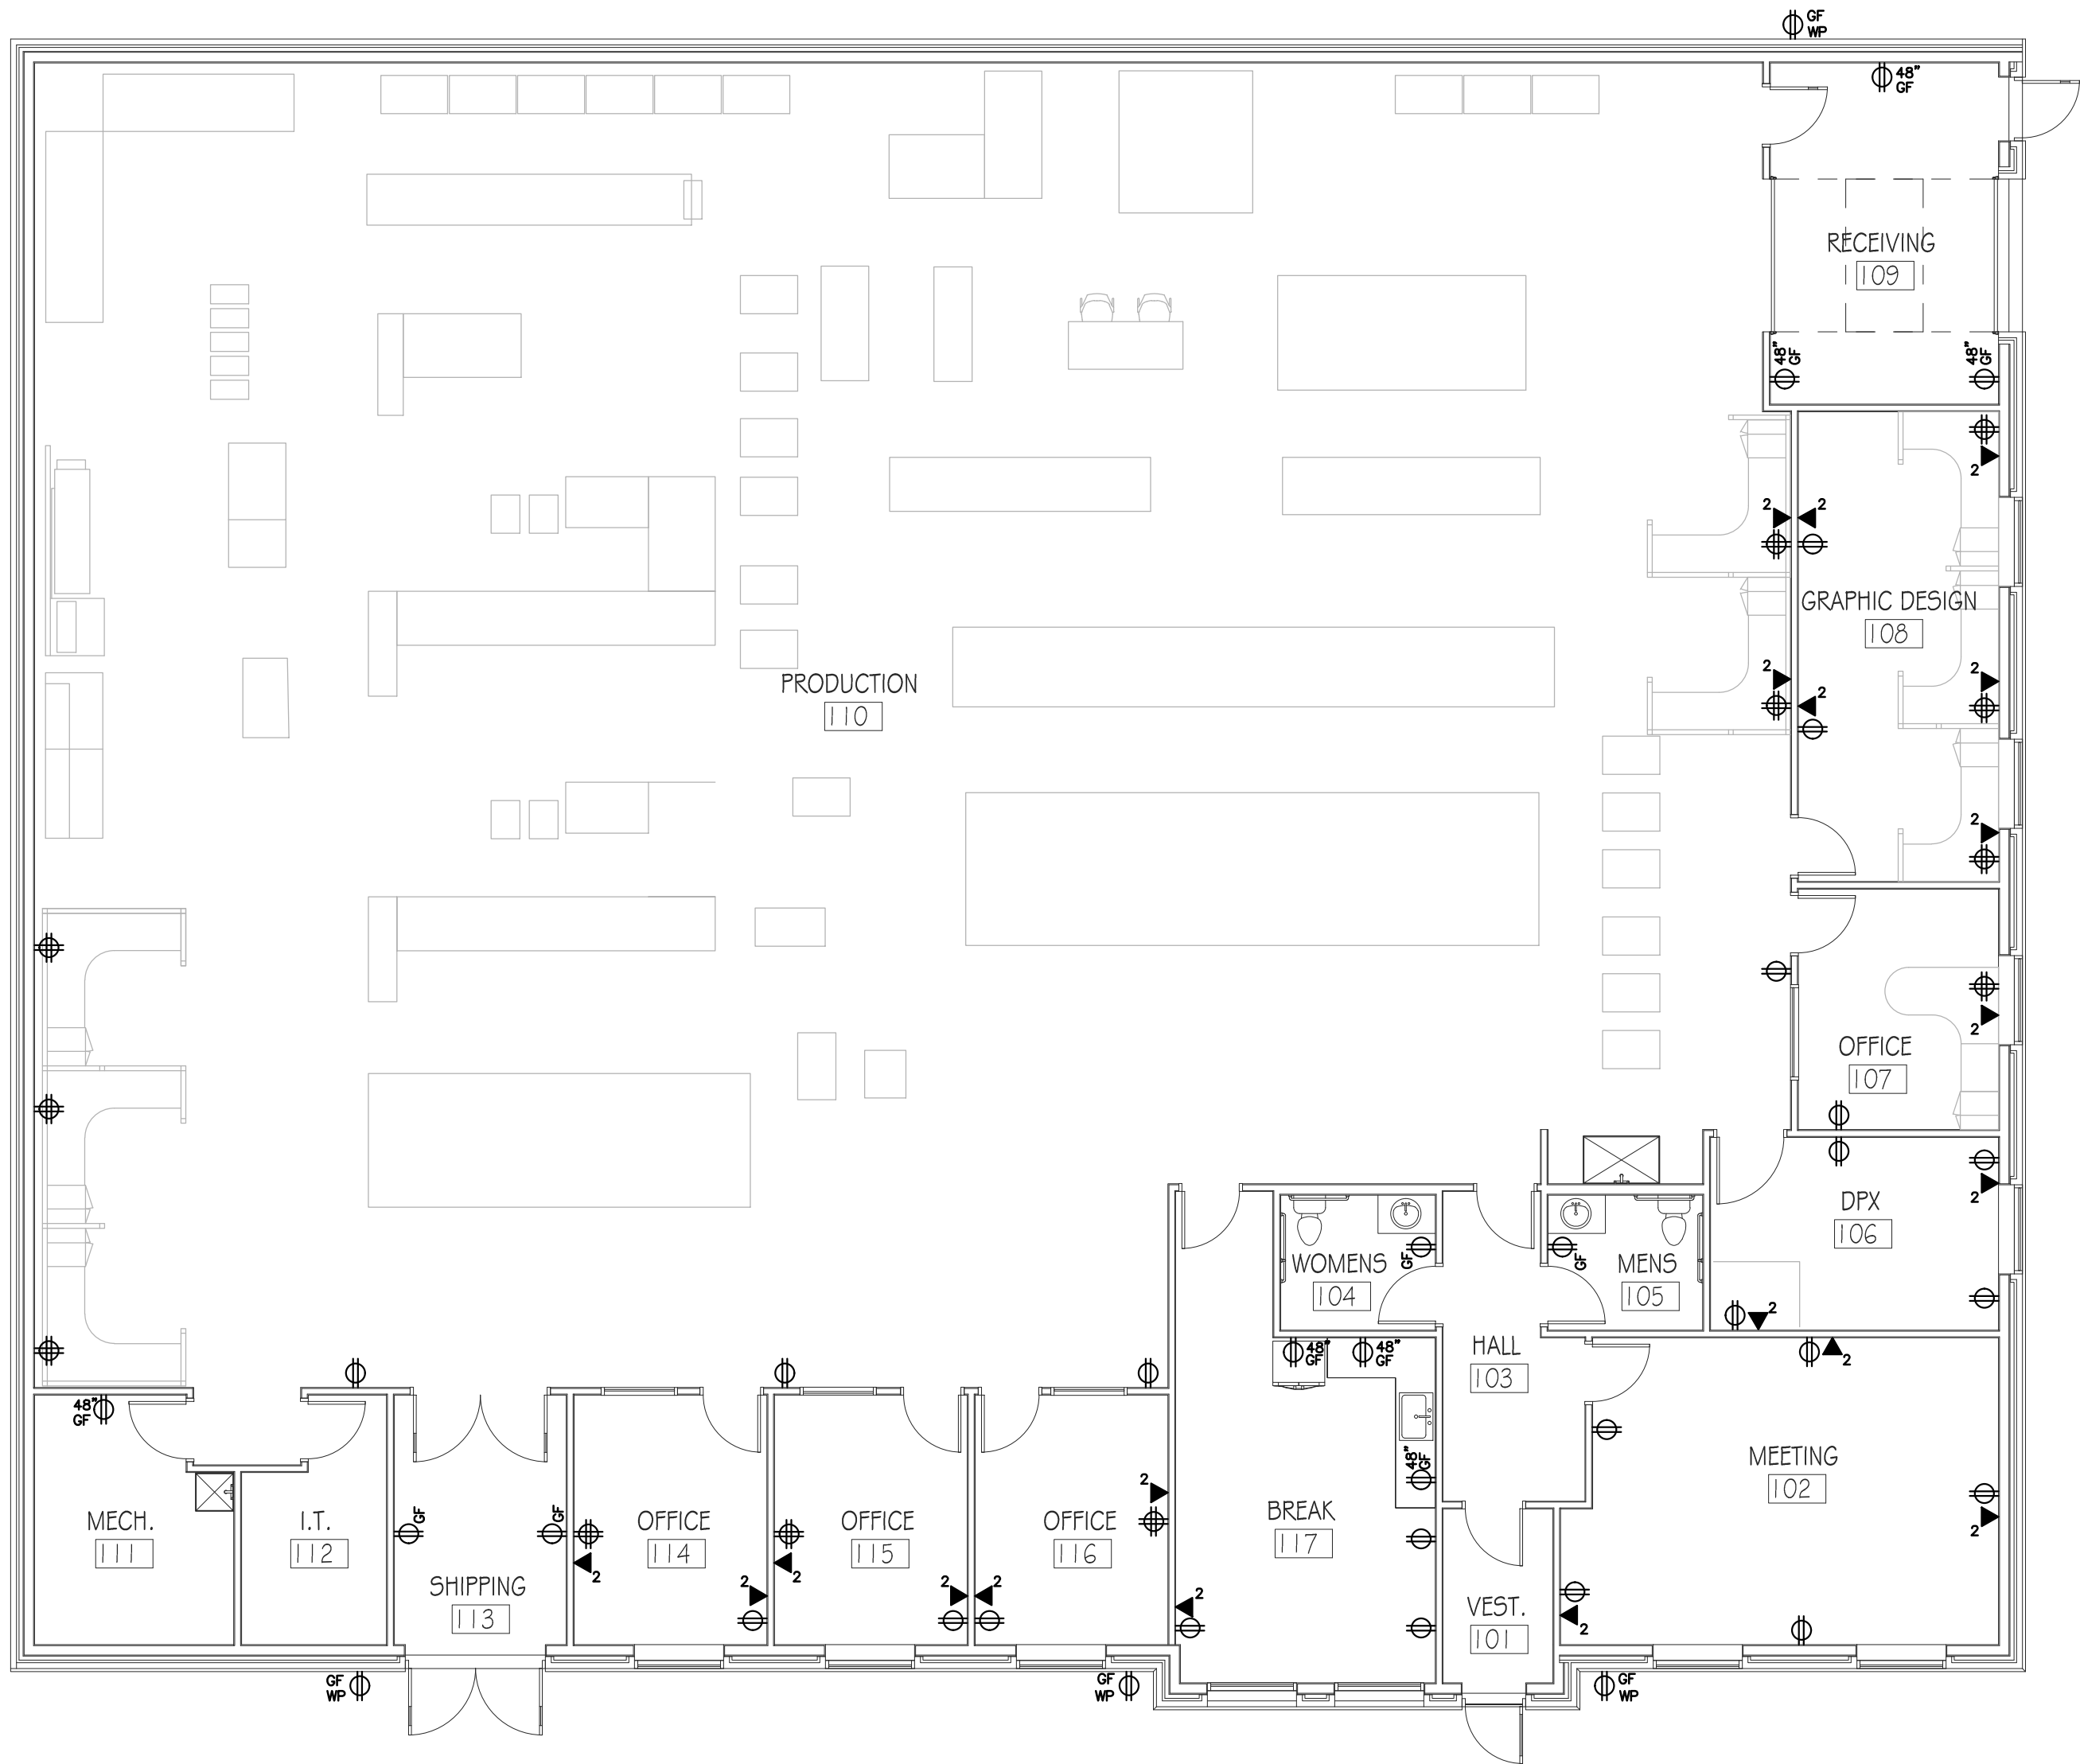

- GENERAL POWER PLAN "KEYED" NOTES:
1. .
 2. THIS RECEPTACLE IS DEDICATED TO THE ELECTRIC WATER COOLER. VERIFY EXACT LOCATION AND MOUNTING HEIGHT WITH THE PLUMBING CONTRACTOR.
 3. INSTALL THIS RECEPTACLE IN A 2-GANG OUTLET BOX WITH THE LIGHT SWITCH.
 4. .
 5. .
 6. THIS RECEPTACLE AND CIRCUIT DEDICATED TO THE MICROWAVE OVEN. MOUNT RECEPTACLE IN MICROWAVE CABINET. VERIFY EXACT LOCATION.
 7. .
 8. .
 9. .
 10. .
 11. .
 12. .

1 FIRST FLOOR GENERAL POWER PLAN
SCALE: 1/8" = 1'-0"

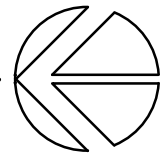

25% DESIGN

MARK	DATE	DESCRIPTION

DRAWN BY:
PM:
JOB NO:
DATE:

GENERAL
POWER PLAN

E3

DAIRYLAND POWER
PRINT SERVICES
La Crosse, Wisconsin 54601

Electrical Contractor:
T.D. Padesky Electric, Inc.
Cunningham Street
La Crosse, Wisconsin 54603



TELECOMMUNICATIONS OUTLET SCHEDULE

Outlet I.D.	Wall - Floor - Ceiling	VOICE							DATA							IP PHONE							Cover Plate Openings	No. of Blanks	Rough-in Box	Wall Conduit Size	Remarks
		Number of Cables	Jack Type	TIA/EIA Wiring Scheme	Icon Tab Color	Plenum-rated Cable?	Actual Cable Length (*)	Terminal Board No.	Number of Cables	Jack Type	TIA/EIA Wiring Scheme	Icon Tab Color	Plenum-rated Cable?	Actual Cable Length (*)	Patch Panel No.	Number of Cables	Jack Type	TIA/EIA Wiring Scheme	Icon Tab Color	Plenum-rated Cable?	Actual Cable Length (*)	Patch Panel No.					
1	Wall								1	RJ-45	5688	TBD	No	See Detail									2	1	1-Gang	3/4"	
2	Wall								2	RJ-45	5688	TBD	No	See Detail									4	2	2-Gang	3/4"	
3	Wall								2	RJ-45	5688	TBD	No	See Detail									2	0	1-Gang	3/4"	C
4	Ceiling								1	RJ-45	5688	TBD	No	D1									1	2	1-Gang		B
5																											
x	(Existing)																									D	


*Cable length to be inserted by the contractor after final installation and testing.

Remarks:

- A. This is an existing data outlet box. Leave box empty for possible future use. Provide and install a blank cover plate.
 B. This is a ceiling-mounted outlet box. Install a single gang outlet box with tile bridge. These locations are reserved for wireless access points.
 C. These data outlets will be installed in the Owner-provided furniture. Data cable shall be dropped from the ladder rack above to these data outlets. Verify the installation with the Owner and the Owner-provided furniture. All data cable to be supported and enclosed in a raceway system.
 D. This is an existing telecommunications outlet. No work. Ensure outlet and cable are protected during construction activities.



① FIRST FLOOR TELCOM AND DATA PLAN
 SCALE: 1/8" = 1'-0"

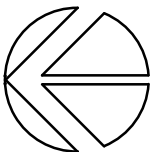

25% DESIGN

MARK

DATE

DESCRIPTION

DRAWN BY:

PM:

JOB NO:

DATE:

TELCOM AND DATA WORK

E4

DAIRYLAND POWER
 PRINT SERVICES
 La Crosse, Wisconsin 54601

Electrical Contractor:
 T.D. Padesky Electric, Inc.
 Cunningham Street
 La Crosse, Wisconsin 54603

