


Luminaire Schedule				
QTY	TYPE	MFR	PART NUMBER	LLF
2	T5M	Acuity	DSX1 LED P5 40K T5M MVOLT SPA DDBXD + 20' SSS POLE + 3' BASE	0.950

Calculation Summary					
AREA	AVG	MAX	MIN	AVG/MIN	MAX/MIN
Parking Lot	1.39	2.5	0.4	3.48	6.25

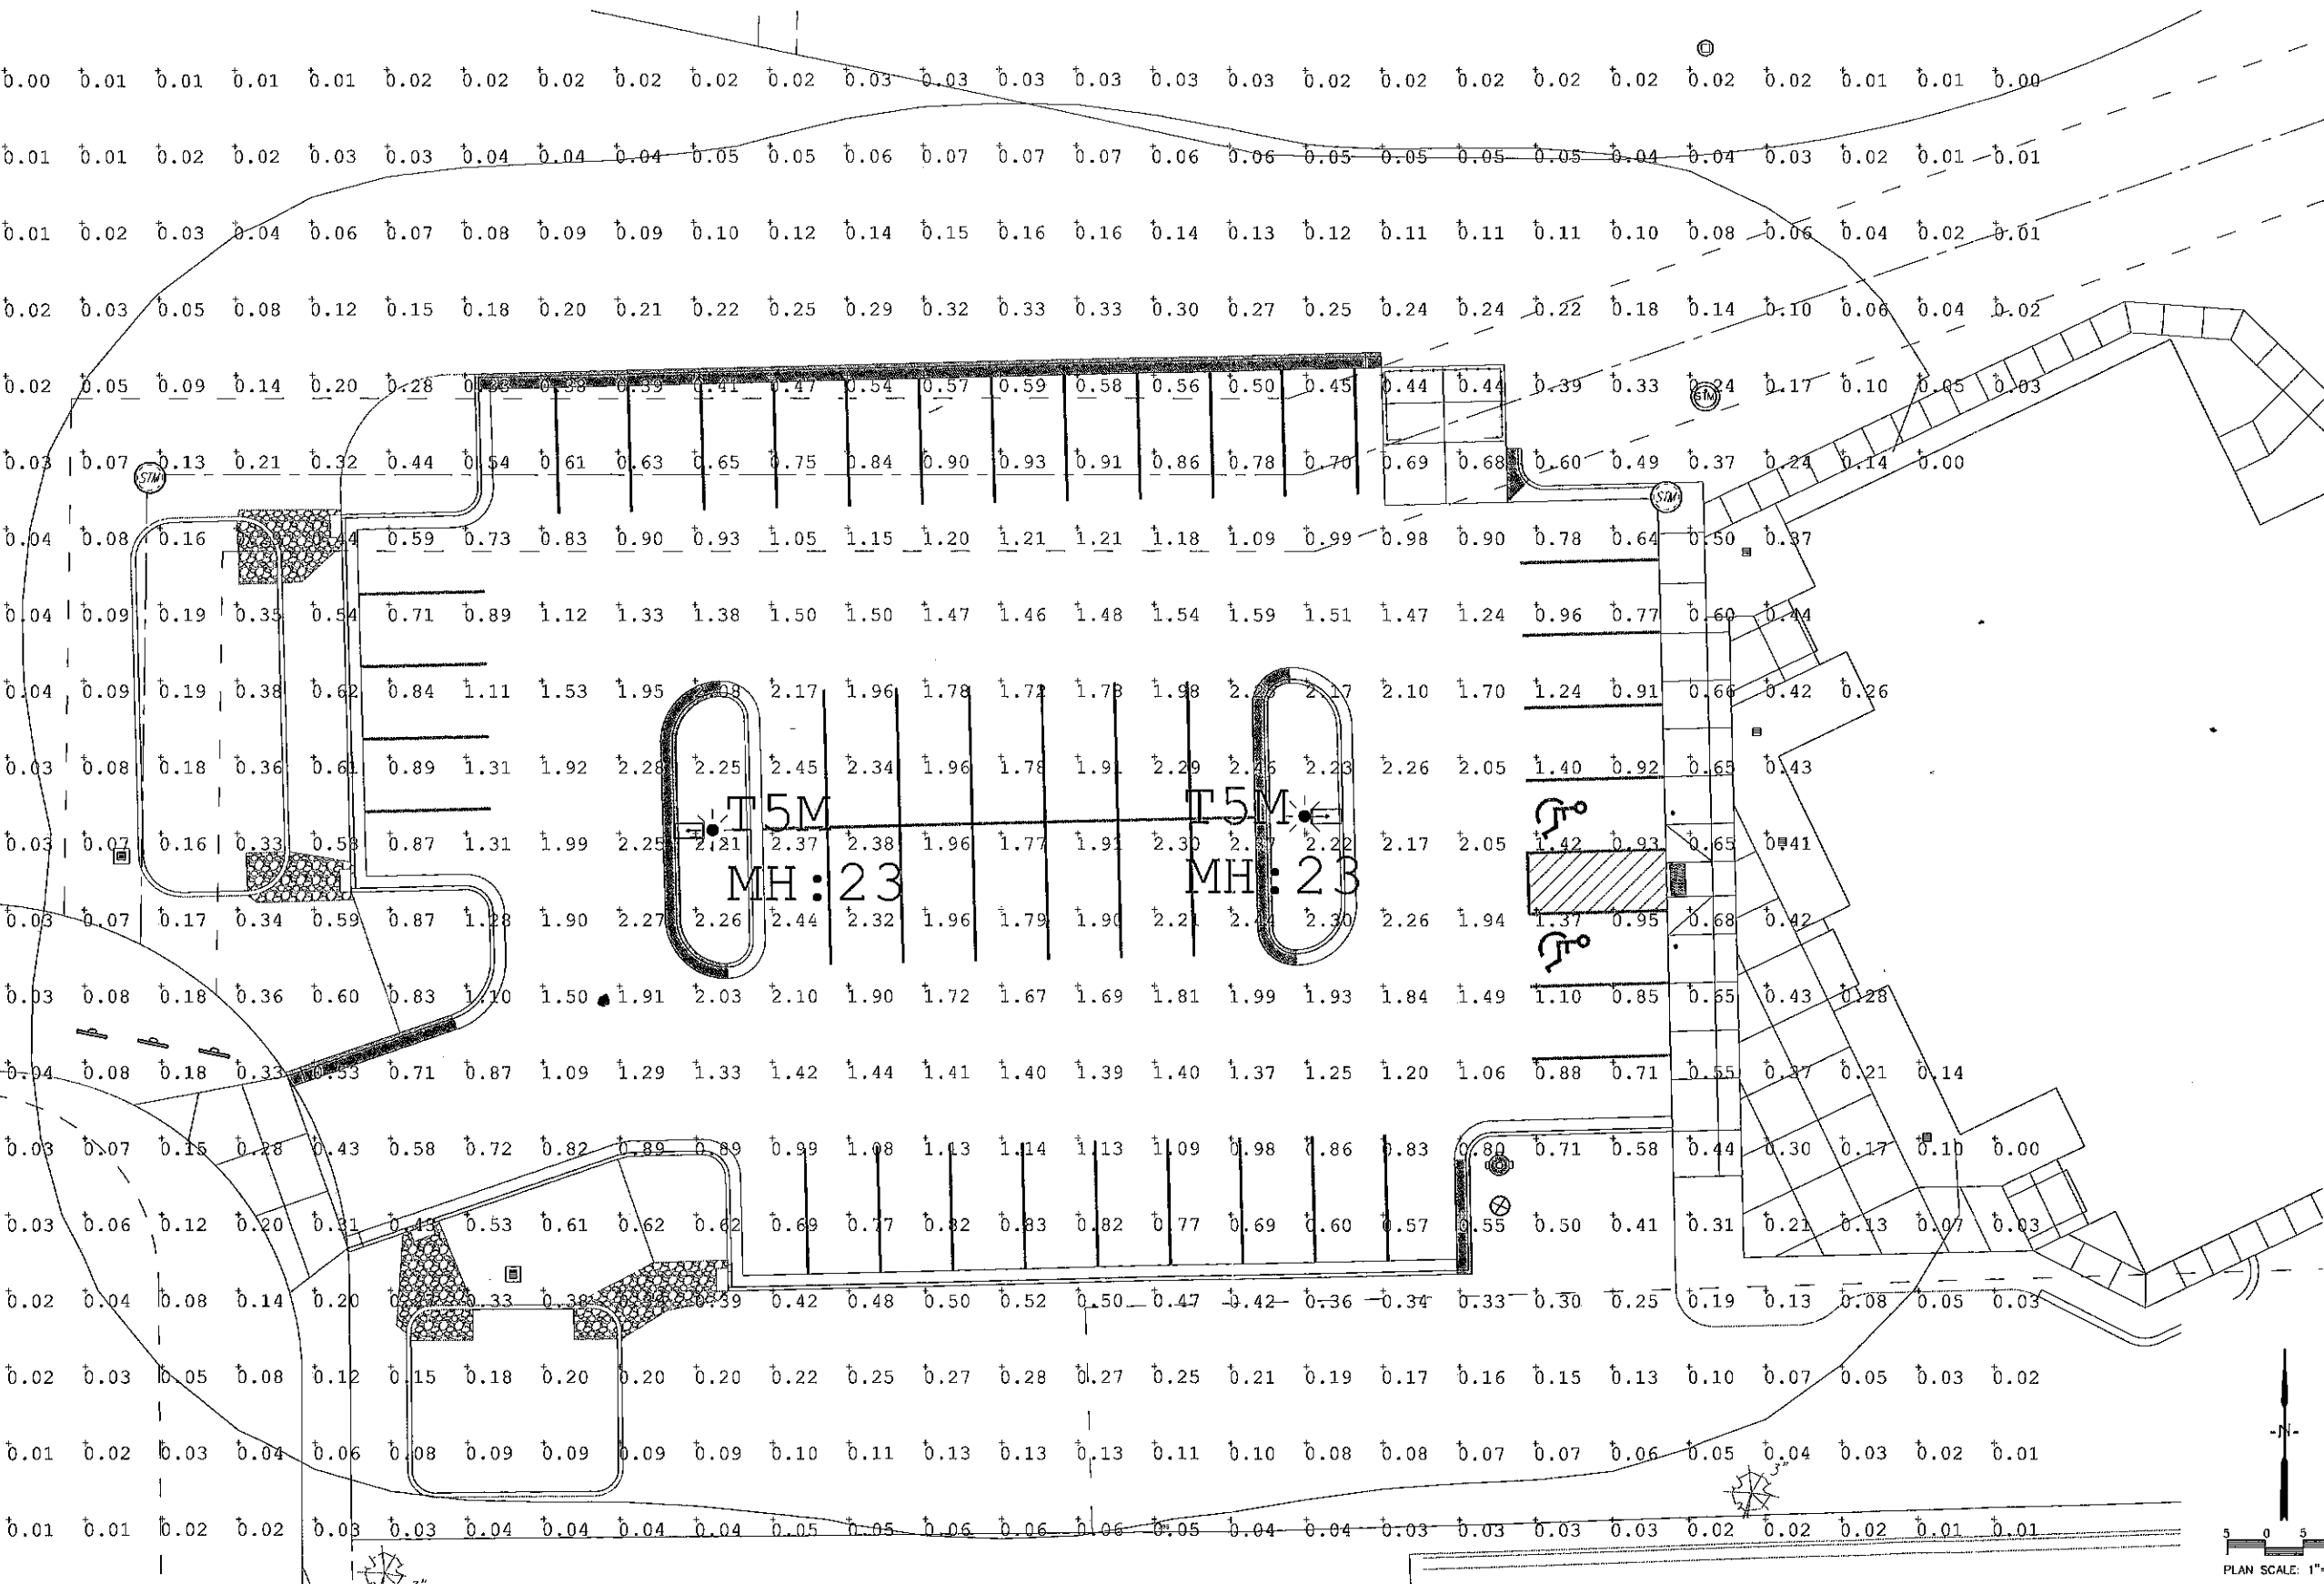

2700 National Drive, Suite 101
Oshkosh, Wisconsin, 54601
608-581-6007
www.DBSG.com
THIS PLAN INCLUDING THE DESIGN AND
CONCEPT, IS THE PROPERTY OF DBS
GROUP AND IS PROTECTED UNDER
COPYRIGHT LAW. UNAUTHORIZED USE OR
DUPLICATION IS STRICTLY PROHIBITED.
COPYRIGHT © 2020

PARAGON ASSOCIATES
Environmental Design & Consulting
244 ENGINEERS, LANDSCAPE ARCHITECTURE, SURVEYING
835 COPPERLAND AVENUE, LA CROSSE, WI 54601
Tel: 608.781.3110 Fax: 608.781.3197 ParagonAssoc.biz

MY LIFE HEALTH CENTER
Darling Court
La Crosse, WI 54601

PHOTOMETRIC PLAN

DRAWN BY: C.G.		PROJECT # 19055	
SHEET #		E-100	
PRELIMINARY		PROJECT ISSUE DATE: 01/30/2020	