


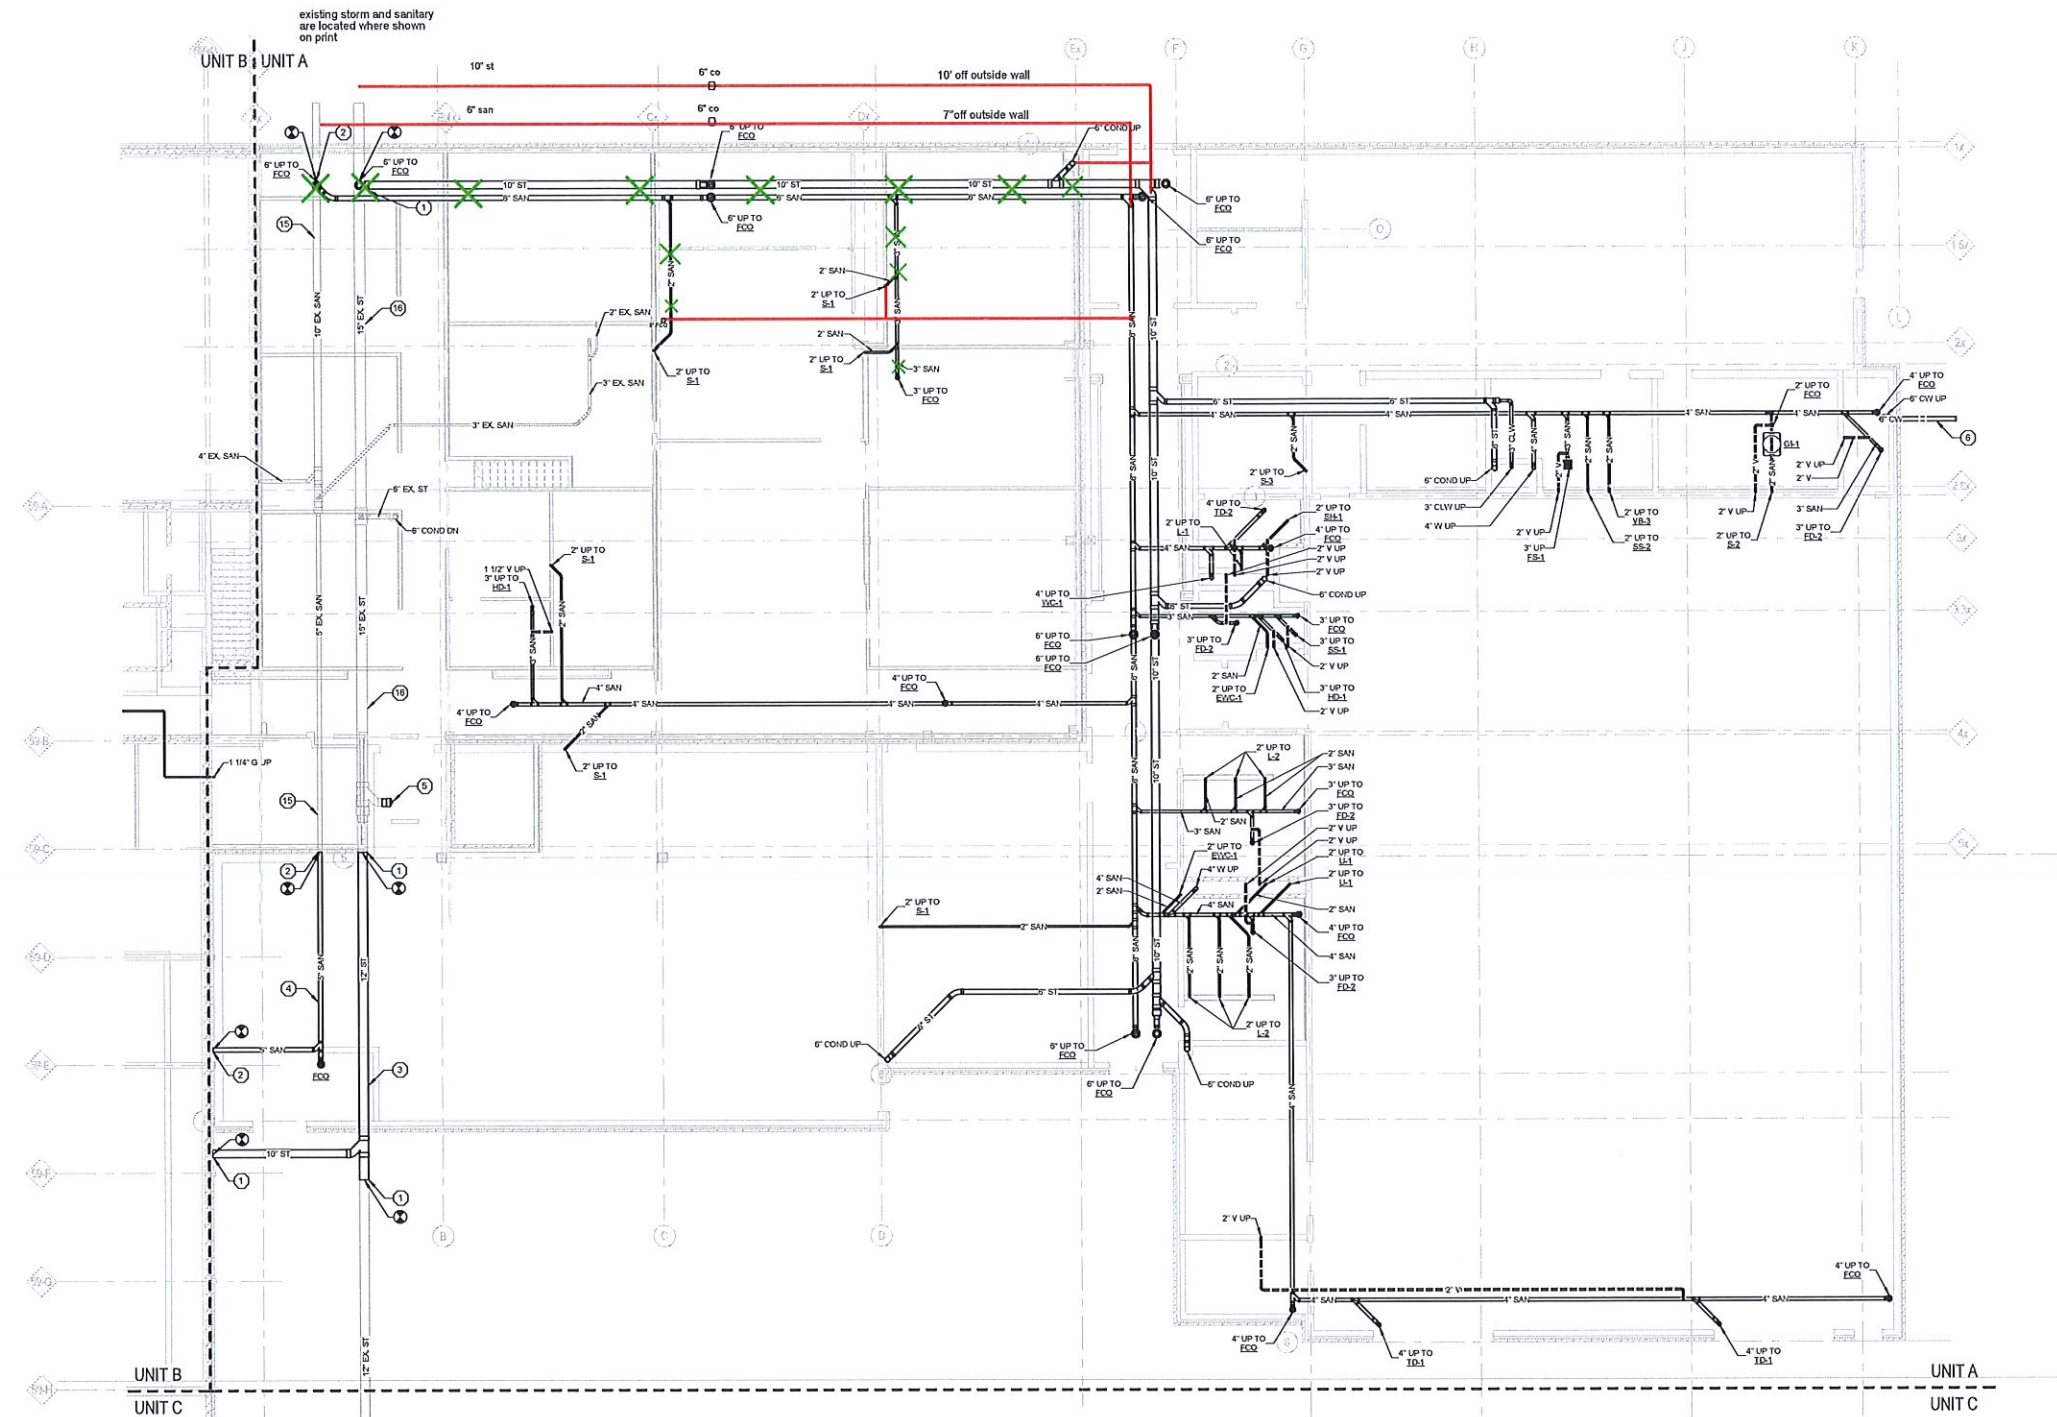

FOUNDATION PLAN - UNIT A
Scale: 1/8" = 1'-0"

- INSTALLATION NOTES**
NOT ALL KEYNOTES APPEAR ON THIS SHEET
1. CONTRACTOR SHALL FIELD VERIFY LOCATION AND SIZE OF EXISTING STORM SEWER. PROVIDE CONNECTION FOR NEW STORM PIPING TO EXISTING AS REQUIRED PER FIELD CONDITIONS.
 2. CONTRACTOR SHALL FIELD VERIFY LOCATION AND SIZE OF EXISTING SANITARY SEWER. PROVIDE CONNECTION FOR NEW SANITARY PIPING TO EXISTING AS REQUIRED PER FIELD CONDITIONS.
 3. REPLACE STORM SEWER BENEATH NEW ADDITION WITH ASTM D2665 PVC PIPE OF THE SAME SIZE. SEE DEMOLITION PLANS FOR ADDITIONAL INFORMATION.
 4. REPLACE SANITARY SEWER BENEATH NEW ADDITION WITH ASTM D2665 PVC PIPE OF THE SAME SIZE. SEE DEMOLITION PLANS FOR ADDITIONAL INFORMATION.
 5. EXISTING PIPE MAN CAPPED OFF BY SITE CONTRACTOR. SEE SITE PLAN FOR MORE INFORMATION.
 6. PROVIDE WATER SERVICE PIPING TO 5 FEET OUTSIDE OF BUILDING FOR EXTENSION TO WATER SERVICE LATERAL BY SITE UTILITY CONTRACTOR. FIELD VERIFY INVERT ELEVATIONS TO ANY INSTALLATION. PROVIDE A MINIMUM OF 6.5 FEET OF GROUND COVER OVER WATER SERVICE PIPING. SEE CIVIL SHEETS FOR MORE INFORMATION.
 7. CONNECT NEW 1-1/4" GAS PIPE TO EXISTING 2" GAS PIPE. NEW GAS PIPE IS SIZED FOR 400 CU FT AT 2.0 PSI TO SERVE NEW WATER HEATERS IN ADDITION.
 8. 1-1/4" GAS UP TO MECHANICAL ROOM ABOVE. COORDINATE LOCATION TO ROUTE PIPE ADJACENT TO EXISTING PIPE ROUTED UP IN THIS LOCATION.
 9. PROVIDE AIR GAP FITTING FOR CONNECTION OF DISHWASHER DRAIN TO S-2 SANITARY GRAB BELOW COUNTER.
 10. TERMINATE WATER PIPING 2 FT ABOVE FINISH FLOOR FOR EXTENSION TO FIRE SPRINKLER RISER EQUIPMENT. COORDINATE FINAL LOCATION, SIZE, AND FITTING TYPE WITH FIRE SPRINKLER CONTRACTOR.
 11. GWH-1 AND GWH-2 MOUNTED ON WALL. PROVIDE COMBUSTION AIR AND VENT PIPING UP TO CONCENTRIC VENT KIT PER MANUFACTURER'S INSTRUCTIONS. TERMINATE THROUGH ROOF. SEE DETAIL FOR ADDITIONAL INFORMATION.
 12. PROVIDE GAS REGULATOR TO REDUCE GAS PRESSURE FROM 2 PSI TO LOW PRESSURE TO SERVE WATER HEATERS.
 13. PROVIDE HEAT TRACE ON STORM PIPING LOCATED IN CANOPY 10 FEET.
 14. ARCHITECT TO REPLACE CEILING STRUCTURE IN THIS AREA. INSTALL NEW PIPE SUPPORTS FOR EXISTING PLUMBING AS REQUIRED. TEMPORARILY SUPPORT EXISTING PIPES FROM FLOORS AS NEEDED. COORDINATE WORK WITH ARCHITECT AND GENERAL CONTRACTOR AS REQUIRED.
 15. EXISTING SANITARY SEWER BELOW EXISTING STRUCTURE TO REMAIN.
 16. EXISTING STORM SEWER BELOW EXISTING STRUCTURE TO REMAIN.



Office Locations	
Davenport	220 Emerson Plaza, Suite 301 Davenport, Iowa 52801 T: 563.326.6050
Madison	829 South 1st Street Westlake, Wisconsin 53094 T: 414.226.0200
Madison	1405 41st Street, Suite 10 Madison, Wisconsin 53705 T: 608.536.6050
Shabogon	1221A North 8th Street Shabogon, Wisconsin 53082 T: 608.459.4200
www.brayarch.com	



Project Title:
Addition & Renovation to:
Hamilton Elementary School
School District of La Crosse
1111 South 7th Street
La Crosse, Wisconsin 54601

REVISIONS:	
DATE	DESCRIPTION

Project Number:	3296
Issued For:	CONSTRUCTION DOCUMENTS
August 27, 2020	
Sheet Title:	FOUNDATION PLAN - UNIT A
Sheet Number:	P1.1A

