

GENERAL NOTES - FLOOR PLANS

- SEE SHEET 0001 FOR ALL ABBREVIATIONS AND ABBREVIATION DESCRIPTIONS.
- ALL DOOR JAMBS ARE TO BE LOCATED 4" FROM ADJACENT PERPENDICULAR WALL UNLESS NOTED OTHERWISE.
- PROVIDE BLOCKING BETWEEN STUDS AT ATTACHMENT POINTS FOR WALL HUNG ACCESSORIES, SHELVES, CABINETS, MIRRORS, ETC.
- ALL RECESSED CABINETS, PANELS, BOXES, ETC. LOCATED IN FIRE RATED PARTITIONS SHALL BE INSTALLED IN A MANNER WHICH MAINTAINS THE FIRE RATING OF THE PARTITION.
- WHERE FLOOR FINISH CHANGES FROM ONE ROOM TO ANOTHER, SET THE JOINT OF THE FLOOR MATERIALS AT THE CENTER OF THE COMMUNICATING DOOR.
- SEE WALL TYPES FOR INTERIOR WALL CONSTRUCTION AND HEIGHT OF WALLS.
- PROVIDE GYPSUM WALL CONTROL JOINTS AT 30'-0" MAXIMUM SPACING. INSTALL AT SIDE OF DOOR JAMBS WHEN FEASIBLE.
- ALL GYPSUM BOARD TO BE HELD 1/2" OFF OF FLOOR.
- CERAMIC/PORCELAIN TILE ARE TO BE INSTALLED SO CUT TILES ARE NOT LESS THAN HALF A TILE.
- SEE ENLARGED TOILET ROOM PLANS AND ELEVATIONS FOR LAYOUT OF TOILET ROOM FIXTURES AND ACCESSORIES.
- ALL TOILETS, URINALS, COUNTERTOPS AND TOILET ROOM ACCESSORIES SHALL BE INSTALLED TO MEET CURRENT STATE RULES AND REGULATIONS FOR BARRIER-FREE DESIGN.
- DO NOT SCALE THE DRAWINGS. CONTACT ARCHITECT FOR ANY NEEDED CLARIFICATIONS.
- COORDINATE WALL OPENING REQUIREMENTS FOR MECHANICAL DUCTS, PIPES, ECT. AND FOR ELECTRICAL CONDUIT WITH THE MECHANICAL AND ELECTRICAL DRAWINGS AND PROVIDE AS NEEDED. OPENINGS SHALL BE SIZED ONLY AS NEEDED FOR THESE PENETRATIONS AND SHALL BE SEALED AROUND THE EDGES FOR SOUND CONTROL AND FIRE-STOPPING PER SPECIFICATIONS AND BUILDING CODE REQUIREMENTS WHERE REQUIRED, TYP.

© Sciart Studio LLC expressly reserves the common law copyright and other property rights in these plans. These plans are not to be changed or copied in any form or manner whatsoever nor are they to be assigned to any third party without first obtaining written permission and consent of SciArt Studio, LLC.

LEGEND - FIRE RATINGS


- 1 HOUR FIRE RATING
 - 2 HOUR FIRE RATING
 - 3 HOUR FIRE RATING
 - 4 HOUR FIRE RATING
 - SMOKE PARTITION
- ALL FIRE RATED WALLS SHALL EXTEND TO UNDERSIDE OF ROOF DECK AND BE SEALED TO MEET THE APPROPRIATE UL DESIGN.

KEYNOTES - FLOOR PLAN

Tag	Text
5.1	PRE-ENGINEERED METAL BUILDING COLUMN
22.1	HOSE BIB
22.2	EYE WASH STATION WITH SINK
22.3	SINK
22.4	FIRE DEPARTMENT CONNECTION AND SPRINKLER RISER
26.1	ELECTRICAL PANELS

SCHEMATIC DESIGN

A PROPOSED NEW BUILDING FOR
ADVANCED FIBER PRODUCTS
2970 LUOYANG AVENUE
LA CROSSE, WISCONSIN, 54601

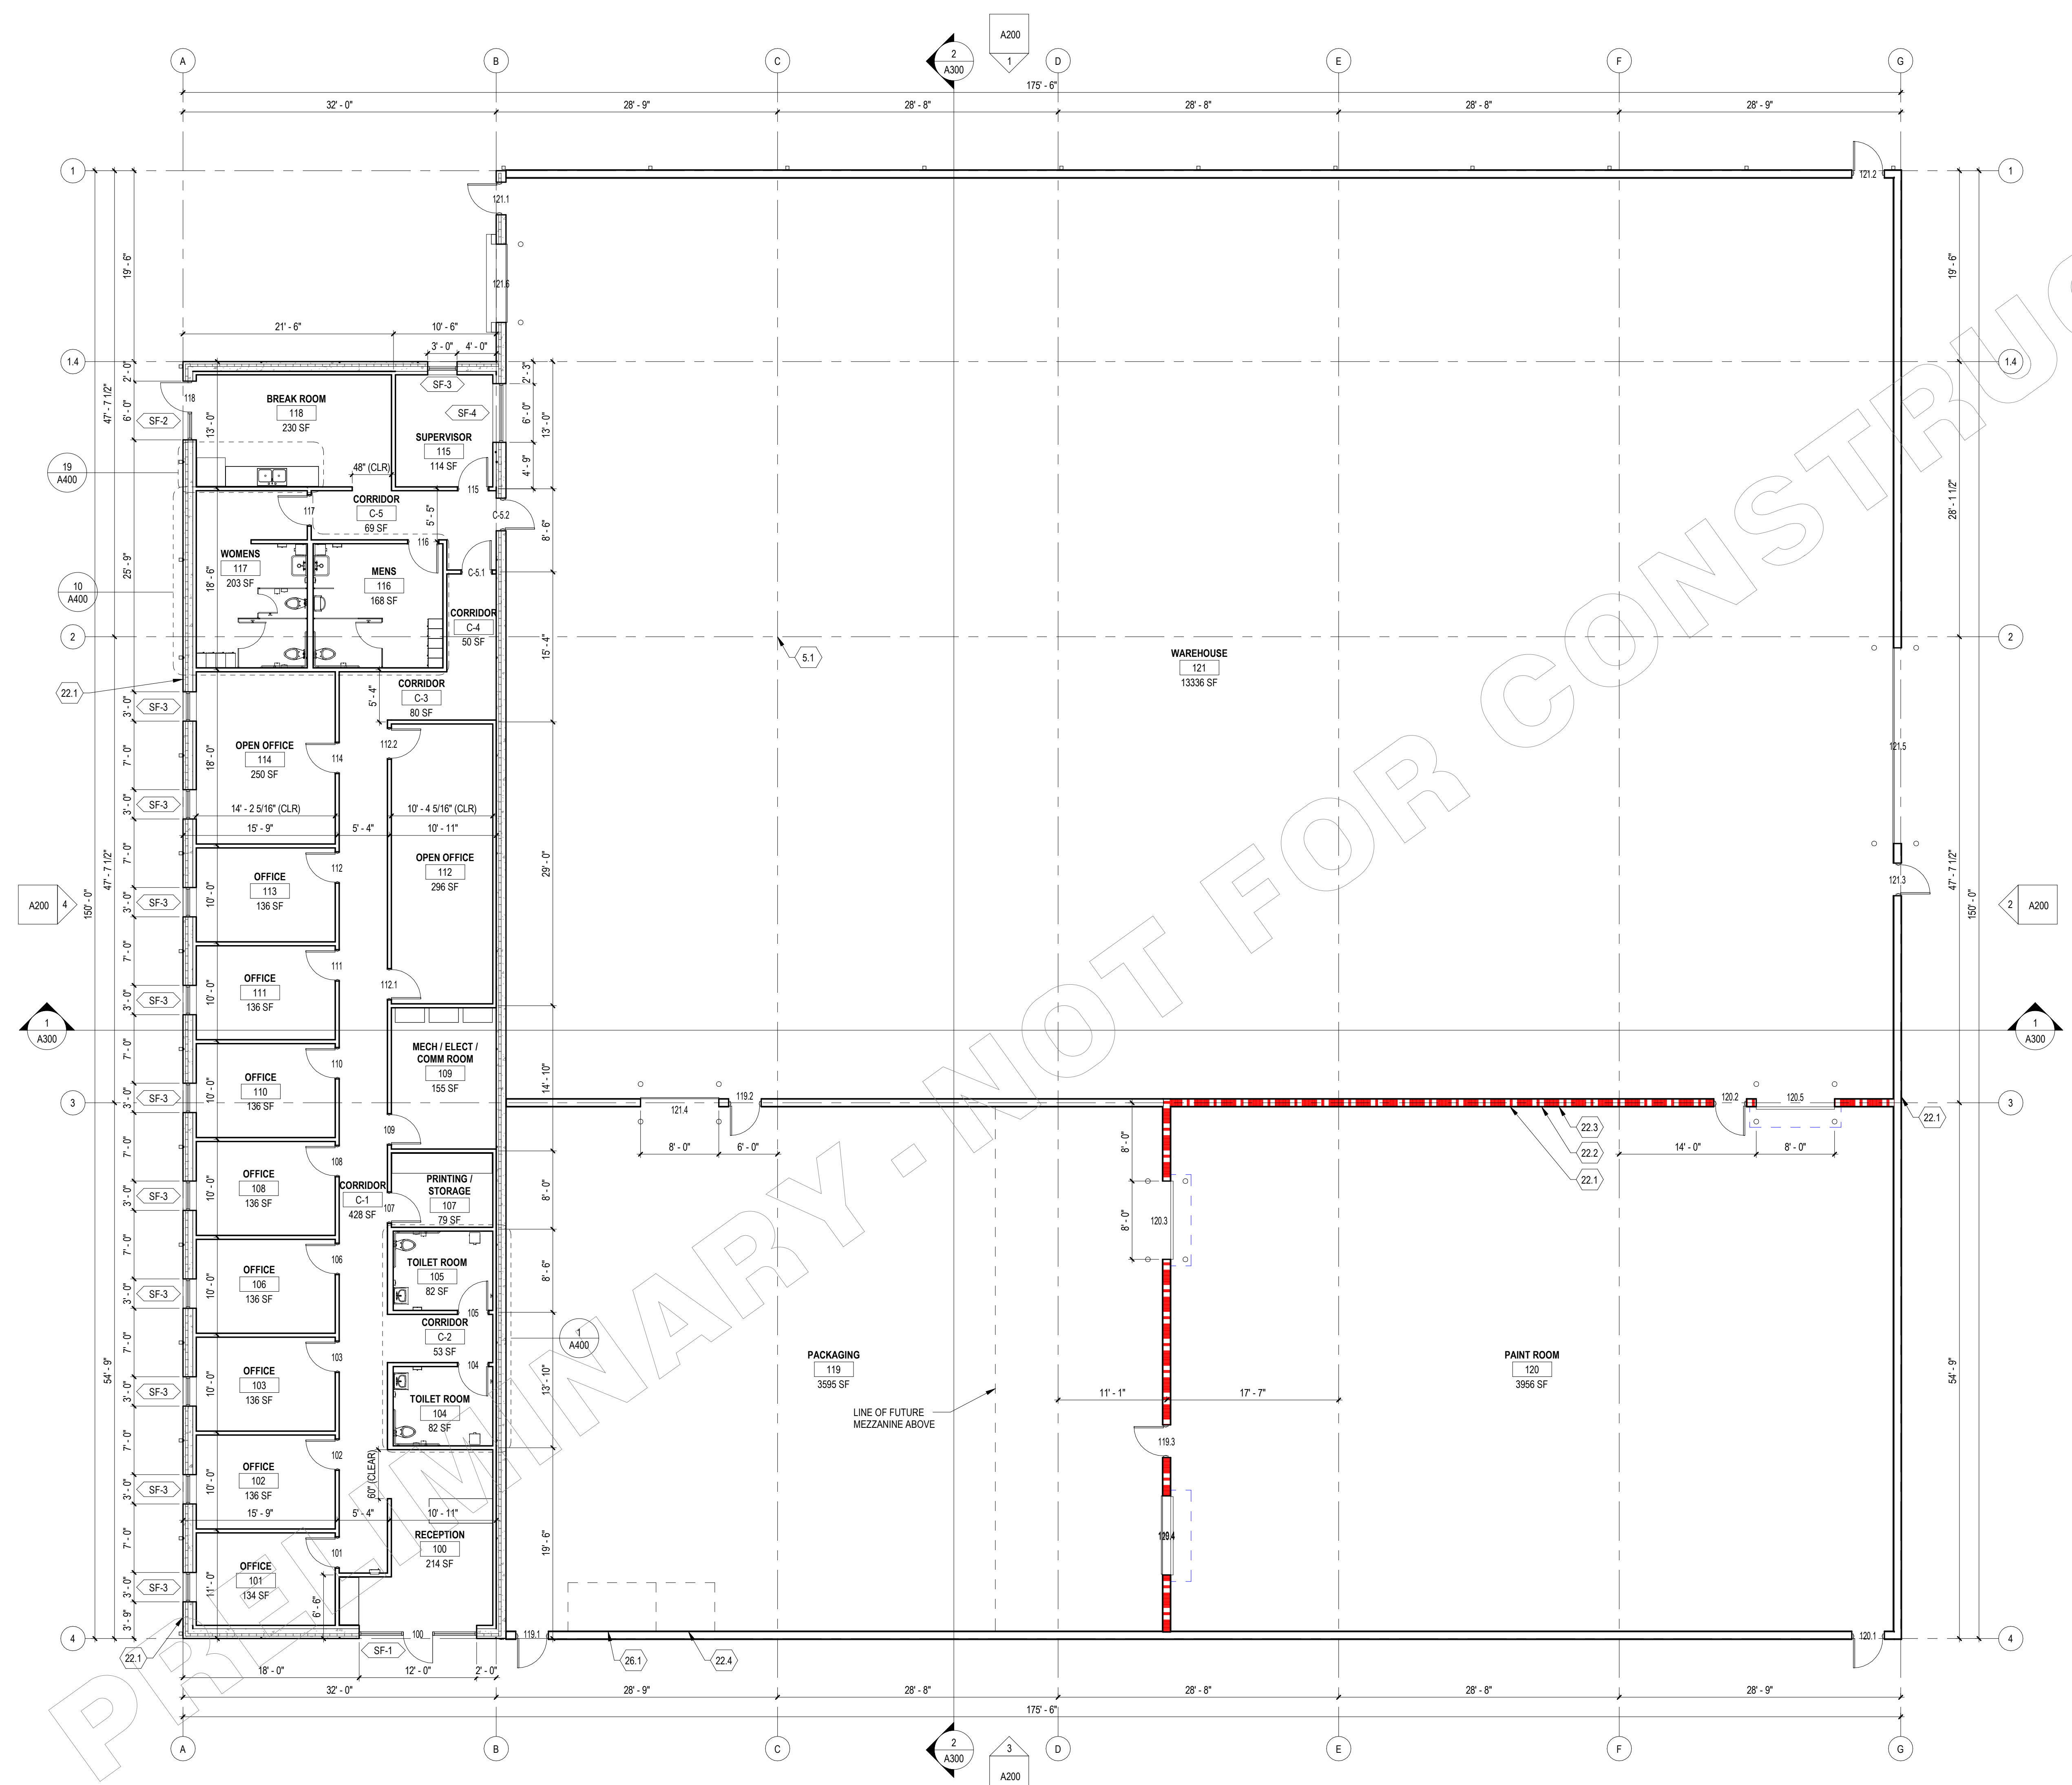

1 FIRST FLOOR PLAN
1/8" = 1'-0"

DRAWN: CAD
CHECKED: MAS
DATE: 08/14/2023
ISSUED:

PROJECT NUMBER 22037

FLOOR PLAN

A100