



PRELIMINARY

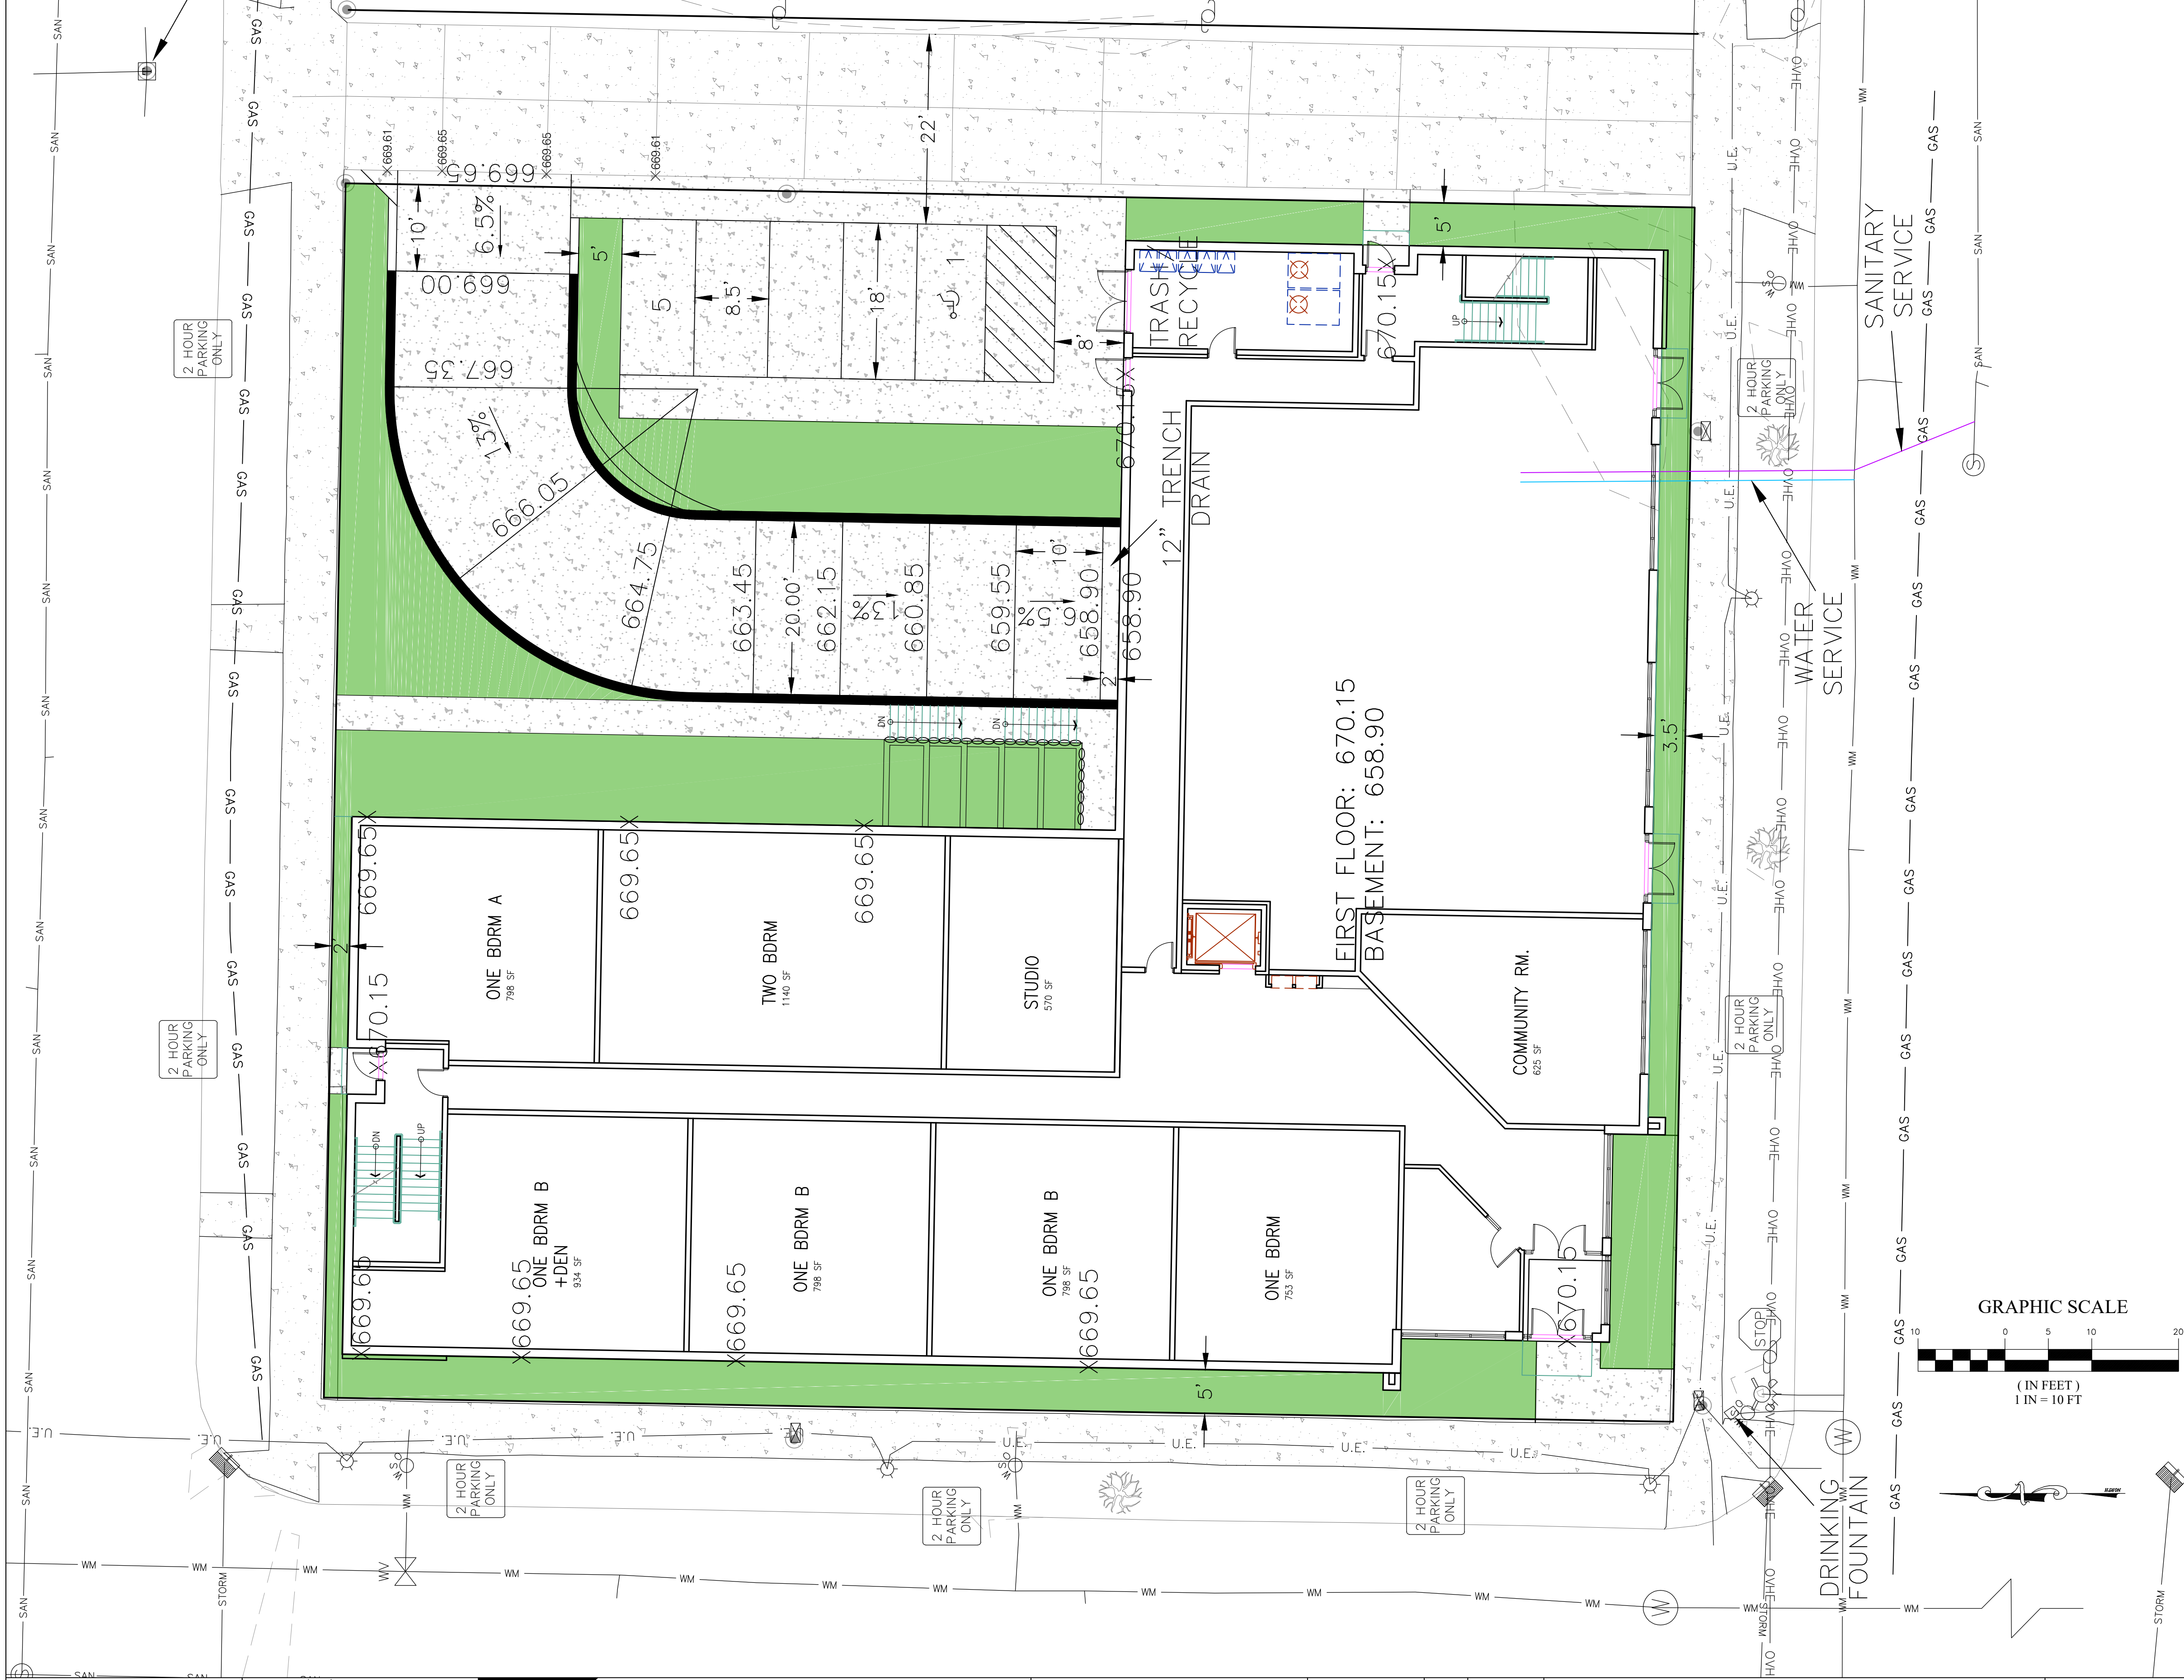

LEGEND

	WATER HYDRANT & GATE VALVE
	SANITARY MANHOLE
	STORM MANHOLE & CATCHBASIN
	SIGNS
	GAS VALVE
	COMMUNICATIONS BOX
	ELECTRIC POLE
	LIGHT POLE
	TREE
	MAJOR CONTOUR
	MINOR CONTOUR
	WATERMAIN
	SANITARY SEWER
	STORM SEWER
	OVERHEAD ELECTRIC LINES
	UNDERGROUND ELECTRIC LINES
	UNDERGROUND COMMUNICATIONS LINE
	RAILINGS, CHAINLINK FENCE
	GAS LINE
	WATER SERVICE
	DRAIN TILE / SUBDRAIN
	PROPOSED MAJOR CONTOUR
	PROPOSED MINOR CONTOUR
	EASEMENT LINE
	RETAINING WALL
	BUFFERYARD LINE
	BITUMINOUS SURFACING
	CONCRETE SURFACING
	AGGREGATE SURFACING
	BUILDING
	BOULDER OR BIG BLOCK TRANSITION
	GARDEN
	PROPOSED BITUMINOUS SURFACING
	PROPOSED CONCRETE SURFACING
	PROPOSED BOULEVARD TREE
	SILT FENCE (PER ROCH. STD. PLATE 7-01)
	GRADING LIMITS
	EXISTING SPOT ELEVATION
	PROPOSED SPOT ELEVATION
	PROPOSED SLOPE
	INLET BARRIER (PER ROCH. STD. PLATE 7-05)
	PROPOSED EROSION CONTROL BLANKET (PER MNDOT 3885.1 CAT. 3)
	ROCK CONSTRUCTION ENTRANCE (PER ROCH. STD. PLATE 7-06)
	RIP RAP (PER MNDOT 3133D)

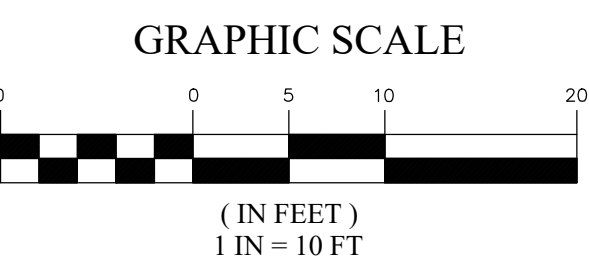

I HEREBY CERTIFY THAT THIS PLAN, SPECIFICATION, OR REPORT WAS PREPARED BY ME OR UNDER MY DIRECT SUPERVISION AND THAT I AM A DULY LICENSED PROFESSIONAL ENGINEER UNDER THE LAWS OF THE STATE OF MINNESOTA.

DATE: X/X/XX

REG. NO. 21940

DATE: 3/19/2019

Prepared For:

SCHOEPPNER, INC

1770 75TH STREET NE

ROCHESTER, MN 55906

FILE NO.: 19-019 BASE

G³

G-Cubed

14070 Hwy 52 S.E.

Chatfield, MN 55923

ENGINEERING SURVEYING PLANNING

Ph: 507-867-1666

Fax: 507-867-1665

www.ggg10

DESIGNED: MRW

DRAWN: ADB

CHECKED: MRW

REVISED	BY	DATE
XXX	XXX	X/X/X

CITY OF LACROSSE

LACROSSE COUNTY

BENCHMARK:

FARNAM FLATS

GRADING PLAN

SHEET 1

OF 1 SHEETS