



SHEET NOTES

- ALL INTERIOR PARTITION WALLS SHALL BE WALL TYPE A3, UNLESS OTHERWISE NOTED.
- PITCH ALL CONCRETE STOOPS 1/4" PER FOOT AWAY FROM BUILDING.
- DIMENSIONS ARE FROM FACE OF MASONRY/ CONCRETE AND FACE OF GYPSUM BD. TO FACE OF GYPSUM BD. FOR STUD WALL, UNLESS NOTED OTHERWISE.
- REFER TO G1-21 FOR RATED WALL LOCATIONS.
- HOUSEKEEPING AND EQUIPMENT PADS BY GENERAL CONTRACTOR. SEE FIRE PROTECTION, PLUMBING, HVAC & ELECTRICAL PLANS FOR LOCATIONS.
- FIRE STOP ALL PENETRATIONS INCLUDING BUT NOT LIMITED TO STEEL JOISTS & BEAMS, PIPING AND DUCTWORK THRU RATED WALLS.
- SEE STRUCTURAL PLANS FOR MASONRY WALL BRACING DETAILS.
- IDENTIFY WITH PAINTED LETTERING 'FIRE WALL' AND 'FIRE BARRIER WALL' ABOVE CEILING 20'-0" O.C. MAX. BOTH SIDES OF WALL. SEE G1-21 FOR LOCATIONS OF RATED WALLS.
- PROVIDE LINTELS AS SHOWN IN STRUCTURAL DRAWINGS ON NON-LOAD BEARING WALL LINTEL SCHEDULE AT ALL NON-BEARING WALL OPENINGS, INCLUDING DUCT OPENINGS.
- ALL PIPING, CONDUITS AND RELATED MECHANICAL AND ELECTRICAL ITEMS SHALL BE CONCEALED WITHIN GYPSUM BOARD FURRING AS REQUIRED IN FINISHED AREAS WHETHER SHOWN ON DRAWINGS OR NOT, UNLESS NOTED OTHERWISE.
- PROVIDE BULLNOSE CORNERS AT VERTICAL CORNERS UNLESS OTHERWISE INDICATED. PROVIDE SQUARE EDGE CMU AT VERTICAL CORNERS WHERE CMU IS SCHEDULE TO RECEIVE CERAMIC TILE.

KEYNOTE LEGEND

THIS DOCUMENT IS THE PROPERTY OF I & S GROUP, INC. AND MAY NOT BE USED, COPIED OR DUPLICATED WITHOUT PRIOR WRITTEN CONSENT.

PROJECT

LA CROSSE REGIONAL AIRPORT CAR WASH FACILITY

LACROSSE WISCONSIN

REVISION SCHEDULE		
DATE	DESCRIPTION	BY



PROJECT NO.	18-21496
FILE NAME	21496 Arch R-18.rvt
DRAWN BY	SJR
DESIGNED BY	KMB
REVIEWED BY	KMB
ORIGINAL ISSUE DATE	
CLIENT PROJECT NO.	

TITLE


FLOOR PLAN

SHEET

A1-21

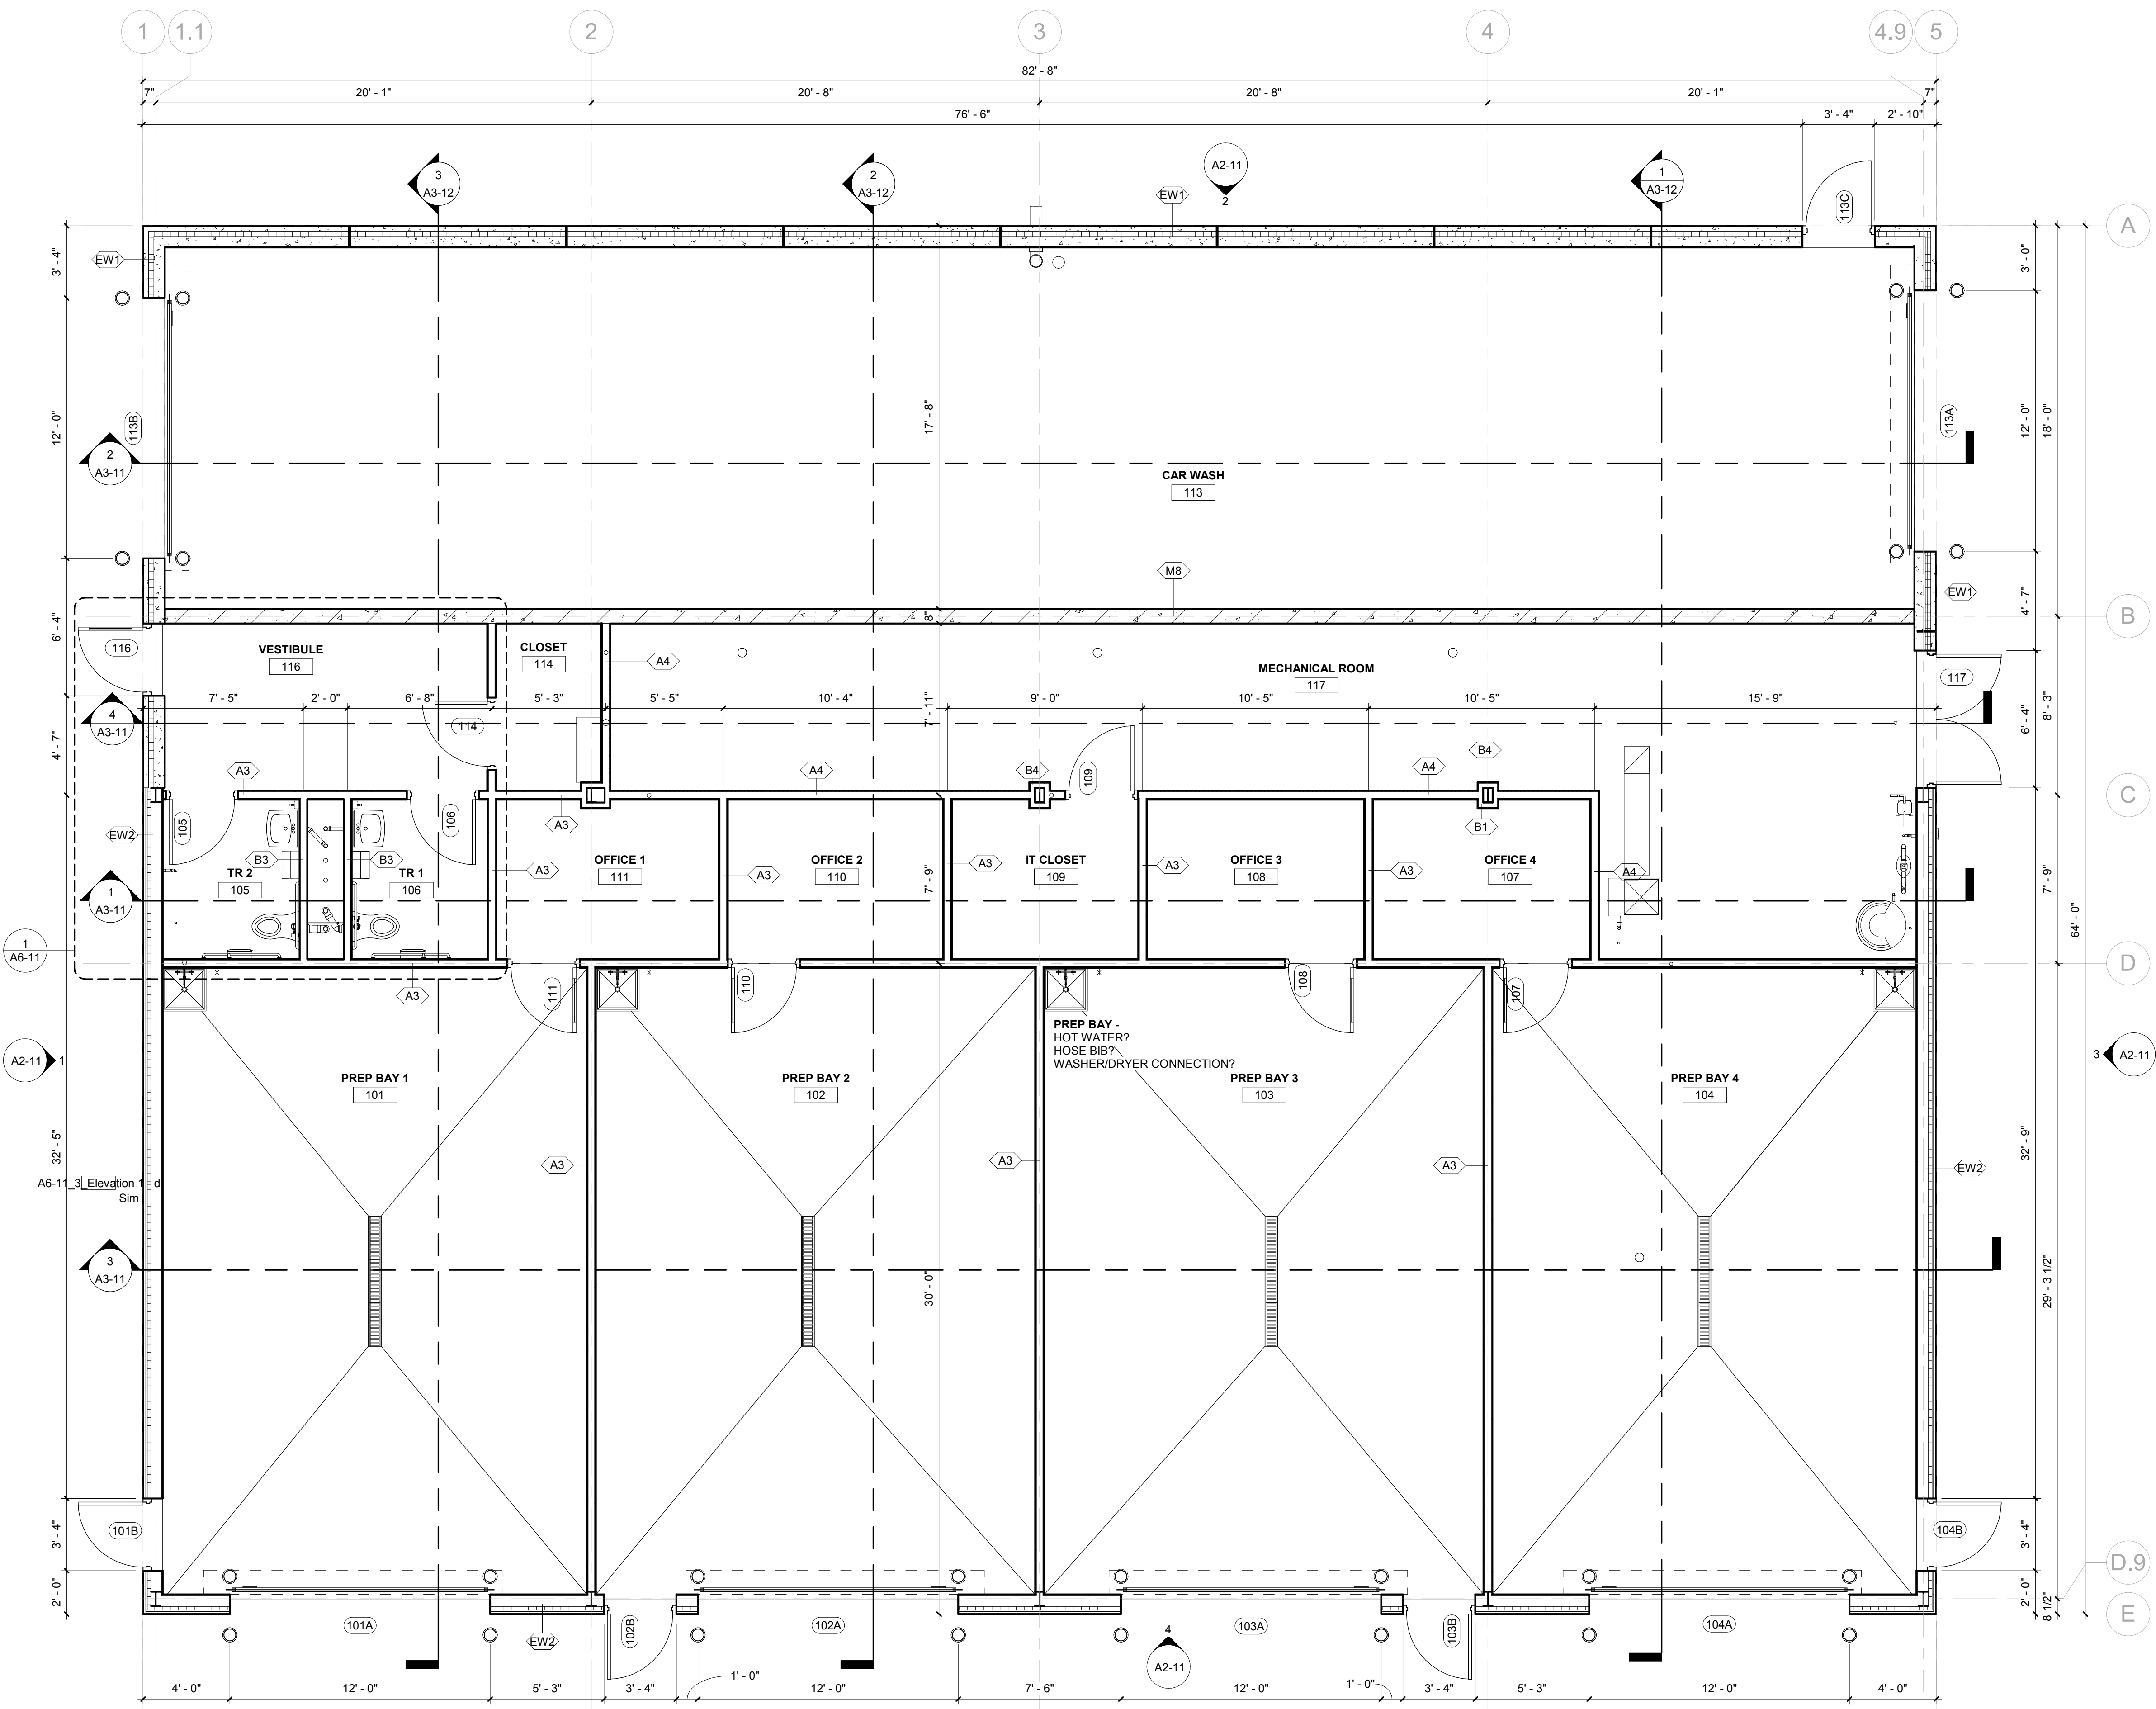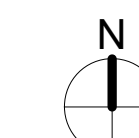

1 FLOOR PLAN
1/4" = 1'-0"

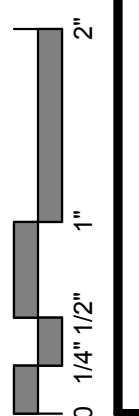

PRELIMINARY NOT FOR CONSTRUCTION