



EXTERIOR ELEVATION KEYNOTES	
Note Number	Note Text
1	PRE-ENGINEERED ALUMINUM CANOPY BY OTHERS; SEE STRUCTURAL
2	SURFACE-MOUNTED LED NEON FLEX LIGHTING AS INDICATED (SHOWN DASHED) - TYP. - RE: ELECTRICAL DRAWINGS
3	MOUNTED SPEAKER SYSTEM; SEE SYSTEMS PLAN
4	ADDRESS NUMBERS TO BE 8" TALL x 2" BRUSH STROKE
5	ELECTRICAL EQUIPMENT, PAINTED TO MATCH BUILDING; SEE ELECTRICAL
6	FROST-PROOF FLUSH HOSE BIB
7	EXTERIOR WEATHER-PROOF OUTLET; SEE MEP
8	THROUGH WALL ROOF SCUPPER DRAIN - TYP.
9	SURFACE MOUNTED LIGHTED SIGN BOX
10	SAMSUNG DIGITAL DISPLAYS -INSTALLED IN FIELD BY IT PROVIDER - CHASE FOR DATA CABLE INSTALLED AT BUILDING MANUFACTURING FACILITY
11	EXPOSED DOWNSPOUT, GALVANIZED, PAINTED; CONNECT TO SUB-GRADE STORM WATER COLLECTION SYSTEM; RE: CIVIL
12	GUARDRAIL; 3' - 6; ABOVE ATTIC FLOOR
13	HVAC EQUIPMENT
14	RUBBERIZED RAMP TO COOLER DOOR; LESS THAN 36" RUN LENGTH
15	NATIONAL MODULAR MANUFACTURING COOLER W/ STORAGE; REF: STRUCTURAL
16	OVERHEAD GAS FIRED HEATER - RE: MECHANICAL DRAWINGS
17	TEMPORARY WARMING HUT LOCATION


EXTERIOR ELEVATION MATERIALS LEGEND	
Note Number	Note Text
A	VERTICAL METAL SIDING (MP-1)
B	ARCHITECTURAL CEMENT BOARD SIDING (BRK-1)
C	BRAKE METAL FASCIA (MP-2)
D	SOFFIT PANELS (MP-2)
E	STANDING SEAM ROOF PANELS (MP-2)
F	PAINTED STRUCTURAL CANOPY COLUMN; RAINWATER DOWNSPOUT WITHIN; CONNECT BASE OF CANOPY COLUMN DOWNSPOUT TO STORMWATER MANAGEMENT SYSTEM; RE: CIVIL
G	ROUND STOREFRONT SIGN; SUPPLIED AND INSTALLED BY SIGN CONTRACTOR
H	1/4" THICK ACRYLIC SIGNAGE APPLIED TO SIDING WITH VH DOUBLE SIDE TAPE
J	METAL BRAKE CAP (MP-3)
K	PAINTED STRUCTURAL CANOPY COLUMN; RE: CIVIL
L	ILLUMINATED STOREFRONT SIGNAGE BY SIGN CONTRACTOR
M	OUTLINE OF MECHANICAL UNIT BEYOND

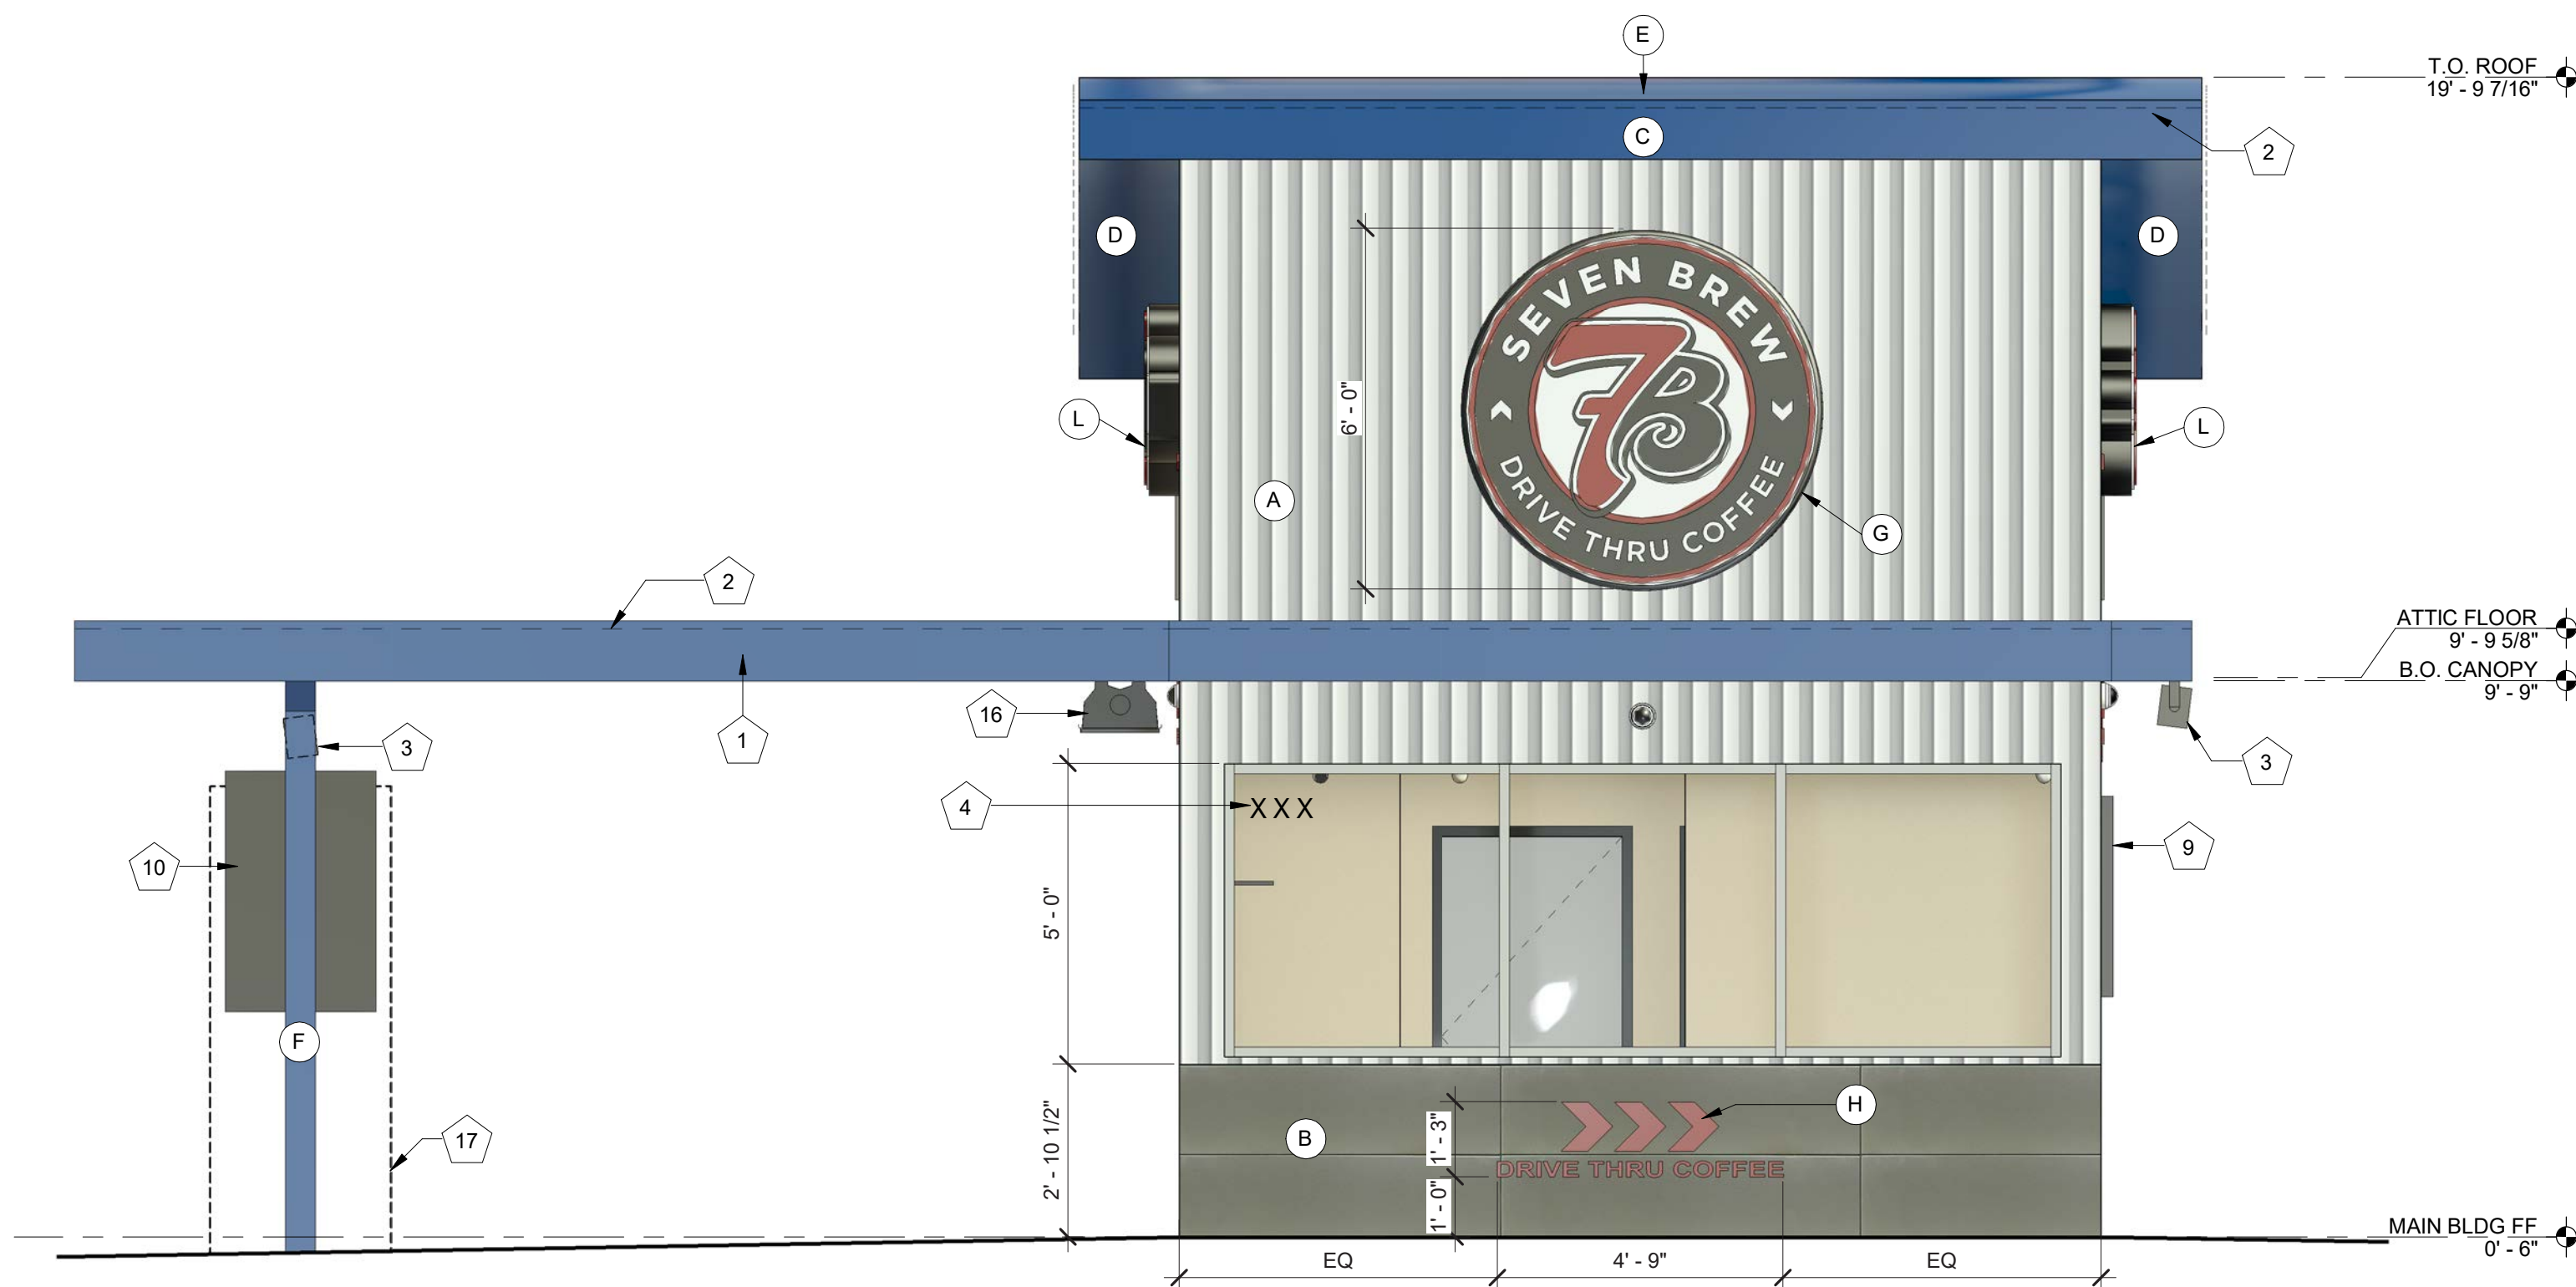

1 EXTERIOR ELEVATION - NORTH
3/8" = 1'-0"

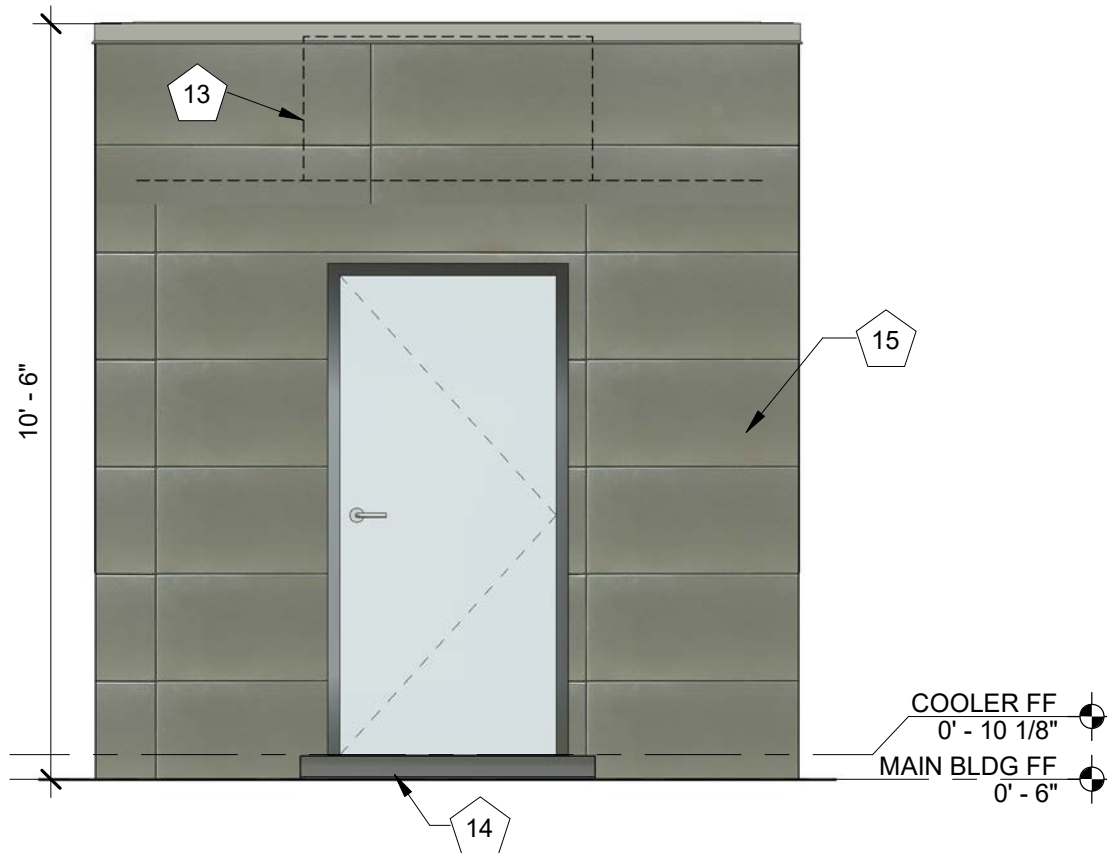

2 COOLER ELEVATION - NORTH
3/8" = 1'-0"

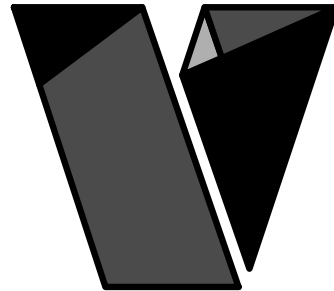

veritas
architecture + design

707 n. 6th street
kansas city, ks 66101
www.veritas-ad.com
913.624.1610

consulting engineer:

7 BREW DRIVE THRU
PLAZA STREET PARTNERS, LLC

REVISIONS		
No.	Description	Date

sheet issue date:
08/08/2023

project no.:

sheet contents:
EXTERIOR ELEVATIONS

sheet no.:


A2.0

EXTERIOR ELEVATION KEYNOTES	
Note Number	Note Text
1	PRE-ENGINEERED ALUMINUM CANOPY BY OTHERS; SEE STRUCTURAL
2	SURFACE-MOUNTED LED NEON FLEX LIGHTING AS INDICATED (SHOWN DASHED) - TYP. - RE: ELECTRICAL DRAWINGS
3	MOUNTED SPEAKER SYSTEM; SEE SYSTEMS PLAN
4	ADDRESS NUMBERS TO BE 8" TALL x 2" BRUSH STROKE
5	ELECTRICAL EQUIPMENT, PAINTED TO MATCH BUILDING; SEE ELECTRICAL
6	FROST-PROOF FLUSH HOSE BIB
7	EXTERIOR WEATHER-PROOF OUTLET; SEE MEP
8	THROUGH WALL ROOF SCUPPER DRAIN - TYP.
9	SURFACE MOUNTED LIGHTED SIGN BOX
10	SAMSUNG DIGITAL DISPLAYS -INSTALLED IN FIELD BY IT PROVIDER - CHASE FOR DATA CABLE INSTALLED AT BUILDING MANUFACTURING FACILITY
11	EXPOSED DOWNSPOUT, GALVANIZED, PAINTED; CONNECT TO SUB-GRADE STORM WATER COLLECTION SYSTEM; RE: CIVIL
12	GUARDRAIL; 3' - 6" ABOVE ATTIC FLOOR
13	HVAC EQUIPMENT
14	RUBBERIZED RAMP TO COOLER DOOR; LESS THAN 36" RUN LENGTH
15	NATIONAL MODULAR MANUFACTURING COOLER W/ STORAGE; REF: STRUCTURAL
16	OVERHEAD GAS FIRED HEATER - RE: MECHANICAL DRAWINGS
17	TEMPORARY WARMING HUT LOCATION

EXTERIOR ELEVATION MATERIALS LEGEND	
Note Number	Note Text
A	VERTICAL METAL SIDING (MP-1)
B	ARCHITECTURAL CEMENT BOARD SIDING (BRK-1)
C	BRAKE METAL FASCIA (MP-2)
D	SOFFIT PANELS (MP-2)
E	STANDING SEAM ROOF PANELS (MP-2)
F	PAINTED STRUCTURAL CANOPY COLUMN; RAINWATER DOWNSPOUT WITHIN; CONNECT BASE OF CANOPY COLUMN DOWNSPOUT TO STORMWATER MANAGEMENT SYSTEM; RE: CIVIL
G	ROUND STOREFRONT SIGN; SUPPLIED AND INSTALLED BY SIGN CONTRACTOR
H	1/4" THICK ACRYLIC SIGNAGE APPLIED TO SIDING WITH VH DOUBLE SIDE TAPE
J	METAL BRAKE CAP (MP-3)
K	PAINTED STRUCTURAL CANOPY COLUMN; RE: CIVIL
L	ILLUMINATED STOREFRONT SIGNAGE BY SIGN CONTRACTOR
M	OUTLINE OF MECHANICAL UNIT BEYOND


2 EXTERIOR ELEVATION - SOUTH

3/8" = 1'-0"

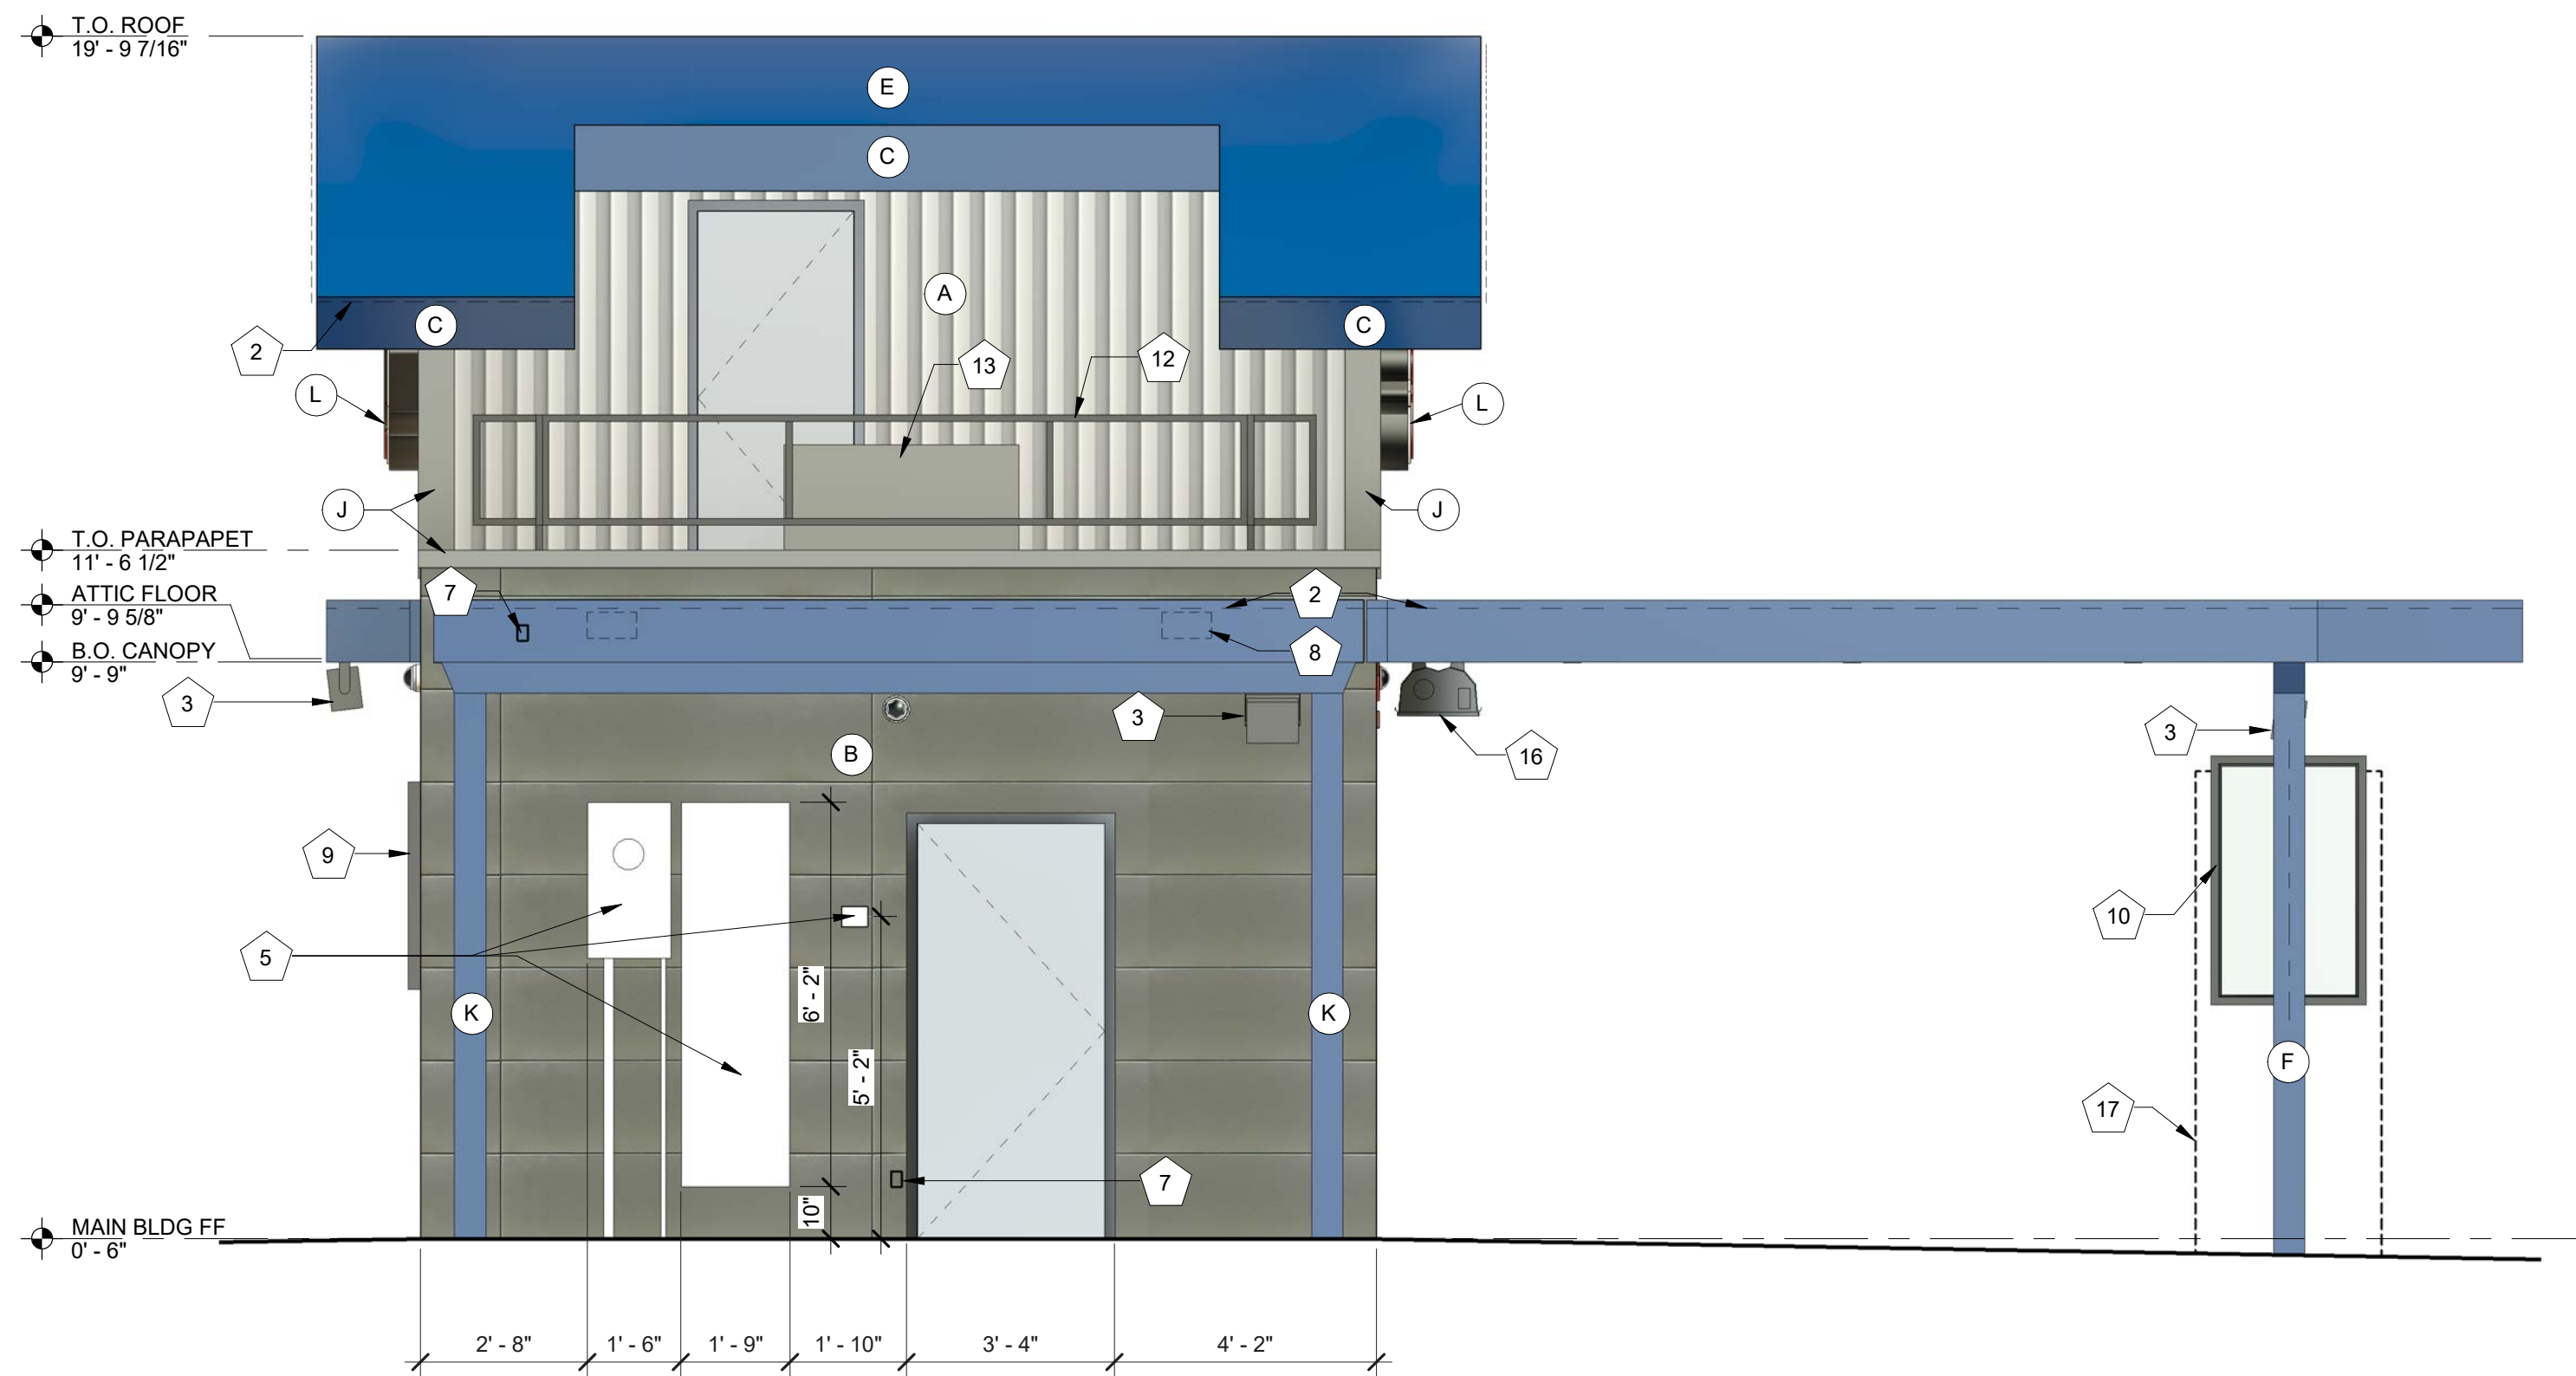


1 EXTERIOR ELEVATION - SOUTH W/ COOLER & WARMING HUT

3/8" = 1'-0"

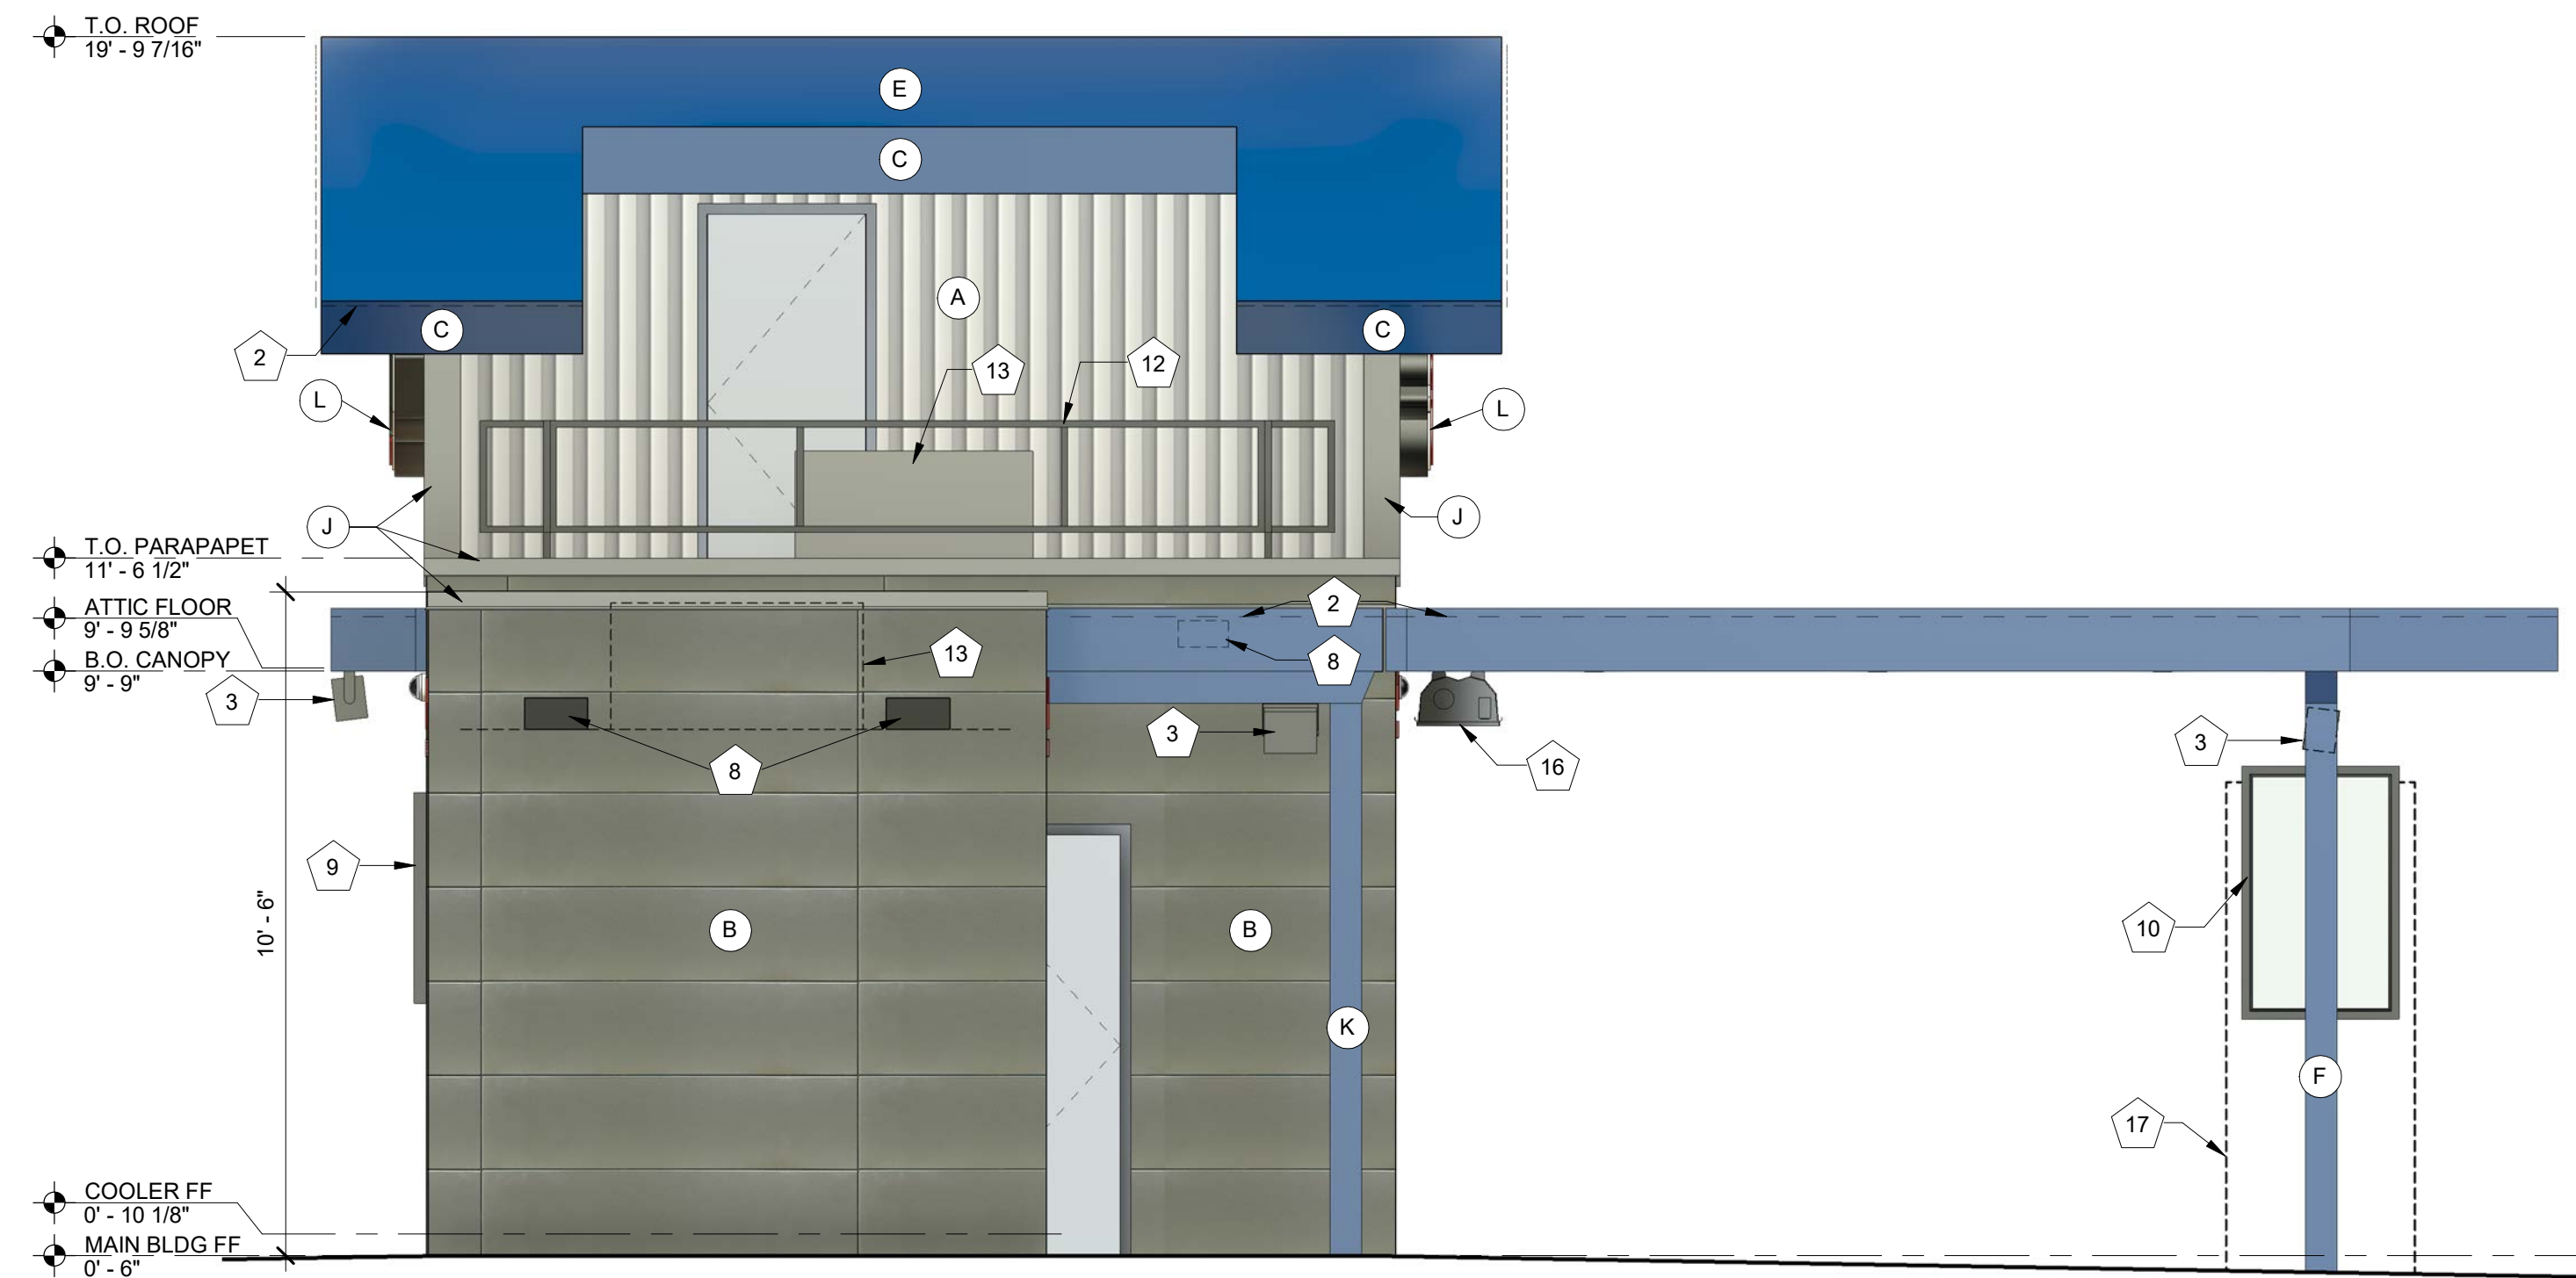


EXTERIOR ELEVATION KEYNOTES	
Note Number	Note Text
1	PRE-ENGINEERED ALUMINUM CANOPY BY OTHERS; SEE STRUCTURAL
2	SURFACE-MOUNTED LED NEON FLEX LIGHTING AS INDICATED (SHOWN DASHED) - TYP. - RE: ELECTRICAL DRAWINGS
3	MOUNTED SPEAKER SYSTEM; SEE SYSTEMS PLAN
4	ADDRESS NUMBERS TO BE 8" TALL x 2" BRUSH STROKE
5	ELECTRICAL EQUIPMENT, PAINTED TO MATCH BUILDING; SEE ELECTRICAL
6	FROST-PROOF FLUSH HOSE BIB
7	EXTERIOR WEATHER-PROOF OUTLET; SEE MEP
8	THROUGH WALL ROOF SCUPPER DRAIN - TYP.
9	SURFACE MOUNTED LIGHTED SIGN BOX
10	SAMSUNG DIGITAL DISPLAYS -INSTALLED IN FIELD BY IT PROVIDER - CHASE FOR DATA CABLE INSTALLED AT BUILDING MANUFACTURING FACILITY
11	EXPOSED DOWNSPOUT, GALVANIZED, PAINTED; CONNECT TO SUB-GRADE STORM WATER COLLECTION SYSTEM; RE: CIVIL
12	GUARDRAIL; 3' - 6" ABOVE ATTIC FLOOR
13	HVAC EQUIPMENT
14	RUBBERIZED RAMP TO COOLER DOOR; LESS THAN 36" RUN LENGTH
15	NATIONAL MODULAR MANUFACTURING COOLER W/ STORAGE; REF: STRUCTURAL
16	OVERHEAD GAS FIRED HEATER - RE: MECHANICAL DRAWINGS
17	TEMPORARY WARMING HUT LOCATION

EXTERIOR ELEVATION MATERIALS LEGEND	
Note Number	Note Text
A	VERTICAL METAL SIDING (MP-1)
B	ARCHITECTURAL CEMENT BOARD SIDING (BRK-1)
C	BRAKE METAL FASCIA (MP-2)
D	SOFFIT PANELS (MP-2)
E	STANDING SEAM ROOF PANELS (MP-2)
F	PAINTED STRUCTURAL CANOPY COLUMN; RAINWATER DOWNSPOUT WITHIN; CONNECT BASE OF CANOPY COLUMN DOWNSPOUT TO STORMWATER MANAGEMENT SYSTEM; RE: CIVIL
G	ROUND STOREFRONT SIGN; SUPPLIED AND INSTALLED BY SIGN CONTRACTOR
H	1/4" THICK ACRYLIC SIGNAGE APPLIED TO SIDING WITH VH DOUBLE SIDE TAPE
J	METAL BRAKE CAP (MP-3)
K	PAINTED STRUCTURAL CANOPY COLUMN; RE: CIVIL
L	ILLUMINATED STOREFRONT SIGNAGE BY SIGN CONTRACTOR
M	OUTLINE OF MECHANICAL UNIT BEYOND

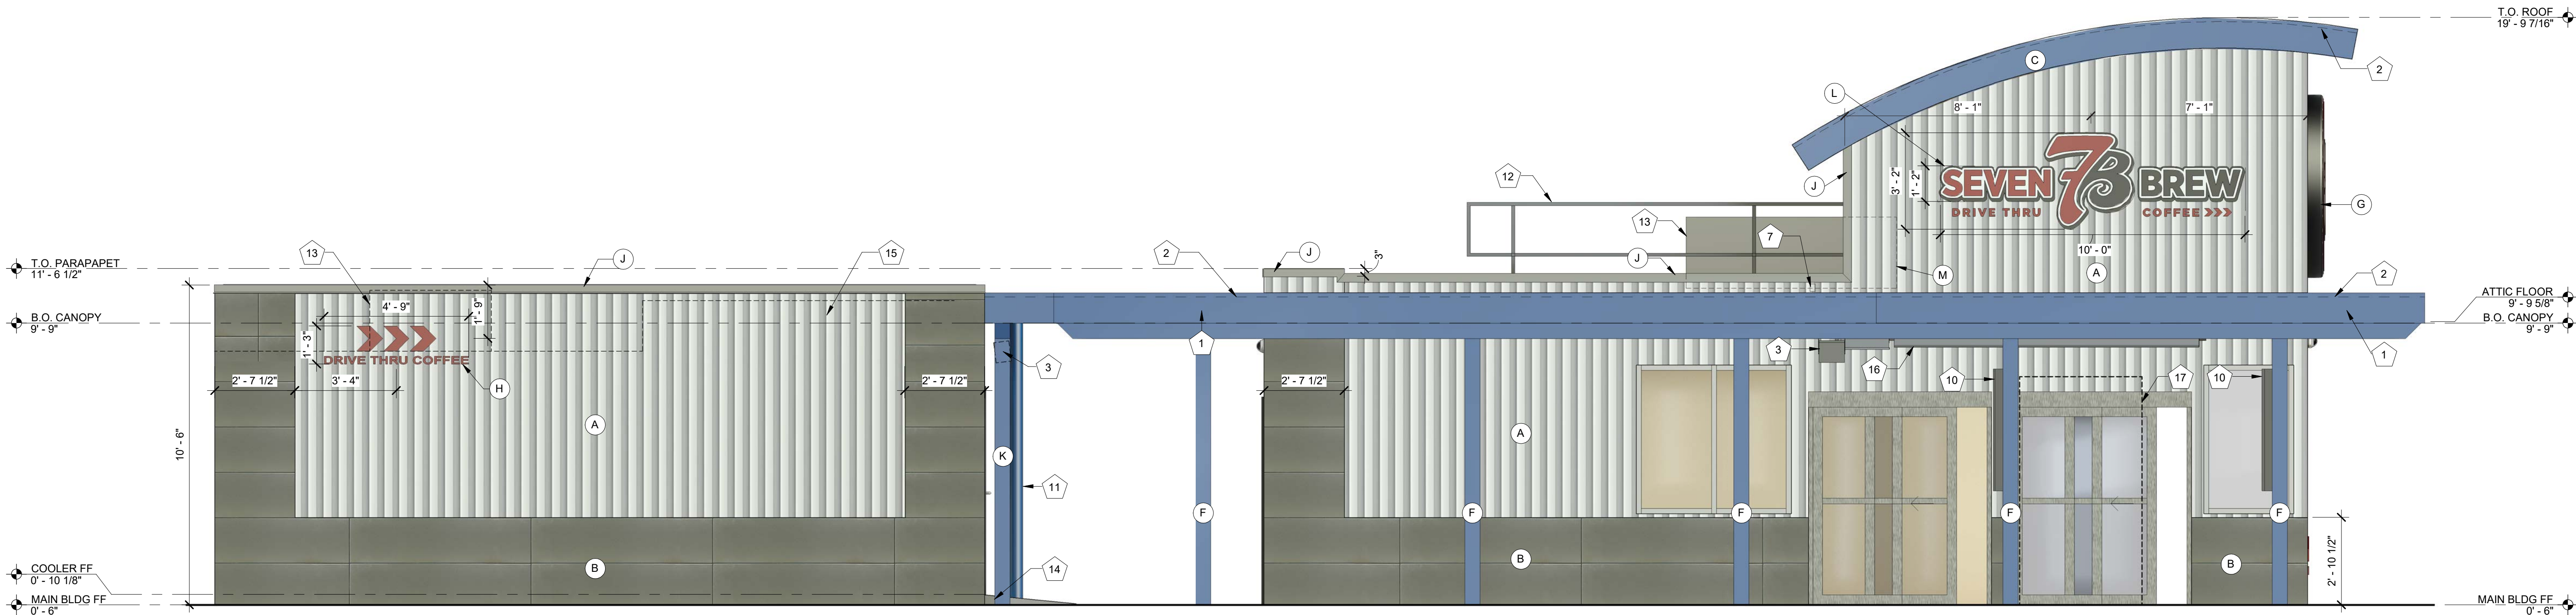

1 EXTERIOR ELEVATION - EAST
3/8" = 1'-0"

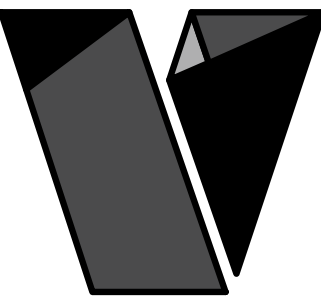

veritas
architecture + design

707 n. 6th street
kansas city, ks 66101
www.veritas-ad.com
913.624.1610

consulting engineer:

7 BREW DRIVE THRU

PLAZA STREET PARTNERS, LLC

REVISIONS

No.	Description	Date
-----	-------------	------

sheet issue date:
08/08/2023

project no.:

sheet contents:
EXTERIOR ELEVATIONS

sheet no.:


A2.2

EXTERIOR ELEVATION KEYNOTES


Note Number	Note Text
1	PRE-ENGINEERED ALUMINUM CANOPY BY OTHERS; SEE STRUCTURAL
2	SURFACE-MOUNTED LED NEON FLEX LIGHTING AS INDICATED (SHOWN DASHED) - TYP. - RE: ELECTRICAL DRAWINGS
3	MOUNTED SPEAKER SYSTEM; SEE SYSTEMS PLAN
4	ADDRESS NUMBERS TO BE 8" TALL x 2" BRUSH STROKE
5	ELECTRICAL EQUIPMENT, PAINTED TO MATCH BUILDING; SEE ELECTRICAL
6	FROST-PROOF FLUSH HOSE BIB
7	EXTERIOR WEATHER-PROOF OUTLET; SEE MEP
8	THROUGH WALL ROOF SCUPPER DRAIN - TYP.
9	SURFACE MOUNTED LIGHTED SIGN BOX
10	SAMSUNG DIGITAL DISPLAYS -INSTALLED IN FIELD BY IT PROVIDER - CHASE FOR DATA CABLE INSTALLED AT BUILDING MANUFACTURING FACILITY
11	EXPOSED DOWNSPOUT, GALVANIZED, PAINTED; CONNECT TO SUB-GRADE STORM WATER COLLECTION SYSTEM; RE: CIVIL
12	GUARDRAIL; 3' - 6" ABOVE ATTIC FLOOR
13	HVAC EQUIPMENT
14	RUBBERIZED RAMP TO COOLER DOOR; LESS THAN 36" RUN LENGTH
15	NATIONAL MODULAR MANUFACTURING COOLER W/ STORAGE; REF: STRUCTURAL
16	OVERHEAD GAS FIRED HEATER - RE: MECHANICAL DRAWINGS
17	TEMPORARY WARMING HUT LOCATION

EXTERIOR ELEVATION MATERIALS LEGEND

Note Number	Note Text
A	VERTICAL METAL SIDING (MP-1)
B	ARCHITECTURAL CEMENT BOARD SIDING (BRK-1)
C	BRAKE METAL FASCIA (MP-2)
D	SOFFIT PANELS (MP-2)
E	STANDING SEAM ROOF PANELS (MP-2)
F	PAINTED STRUCTURAL CANOPY COLUMN; RAINWATER DOWNSPOUT WITHIN; CONNECT BASE OF CANOPY COLUMN DOWNSPOUT TO STORMWATER MANAGEMENT SYSTEM; RE: CIVIL
G	ROUND STOREFRONT SIGN; SUPPLIED AND INSTALLED BY SIGN CONTRACTOR
H	1/4" THICK ACRYLIC SIGNAGE APPLIED TO SIDING WITH VH DOUBLE SIDE TAPE
J	METAL BRAKE CAP (MP-3)
K	PAINTED STRUCTURAL CANOPY COLUMN; RE: CIVIL
L	ILLUMINATED STOREFRONT SIGNAGE BY SIGN CONTRACTOR
M	OUTLINE OF MECHANICAL UNIT BEYOND

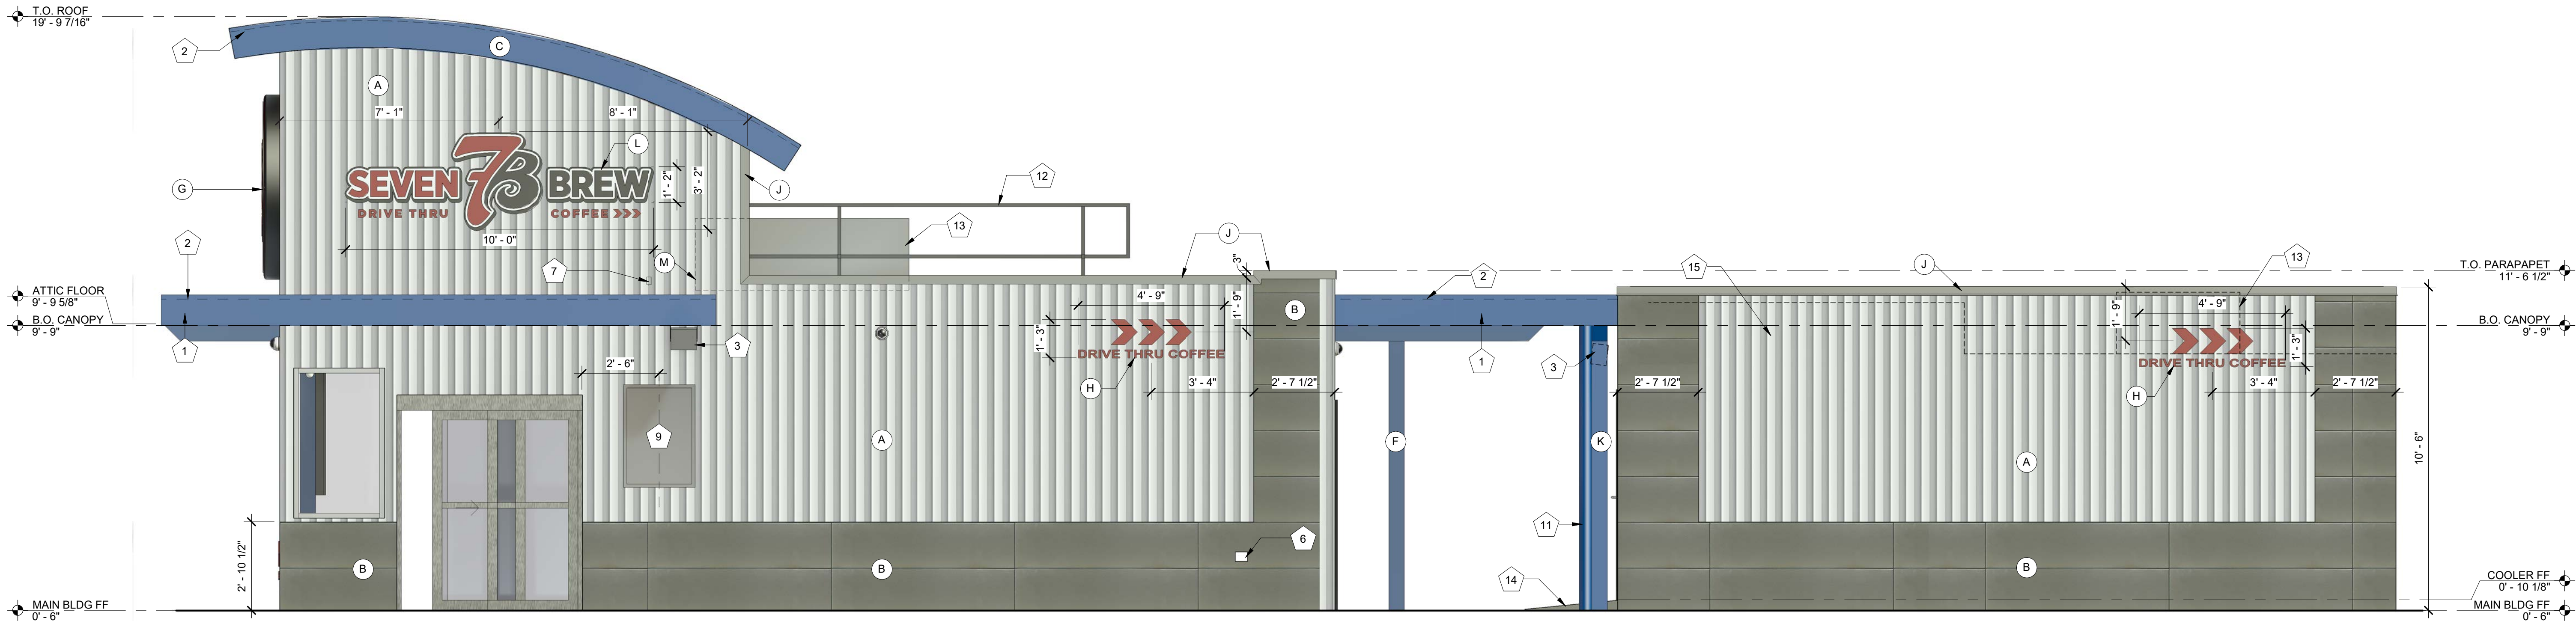

1 EXTERIOR ELEVATION - WEST
3/8" = 1'-0"

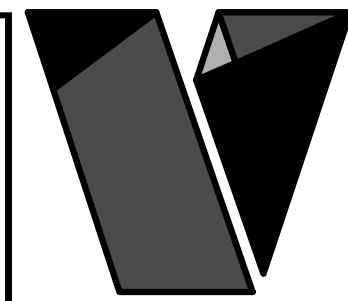

veritas
architecture + design

707 n. 6th street
kansas city, ks 66101
www.veritas-ad.com
913.624.1610

consulting engineer:

7 BREW DRIVE THRU
PLAZA STREET PARTNERS, LLC

REVISIONS		
No.	Description	Date


sheet issue date:
08/08/2023

project no.:


sheet contents:
EXTERIOR ELEVATIONS

sheet no.:


A2.3

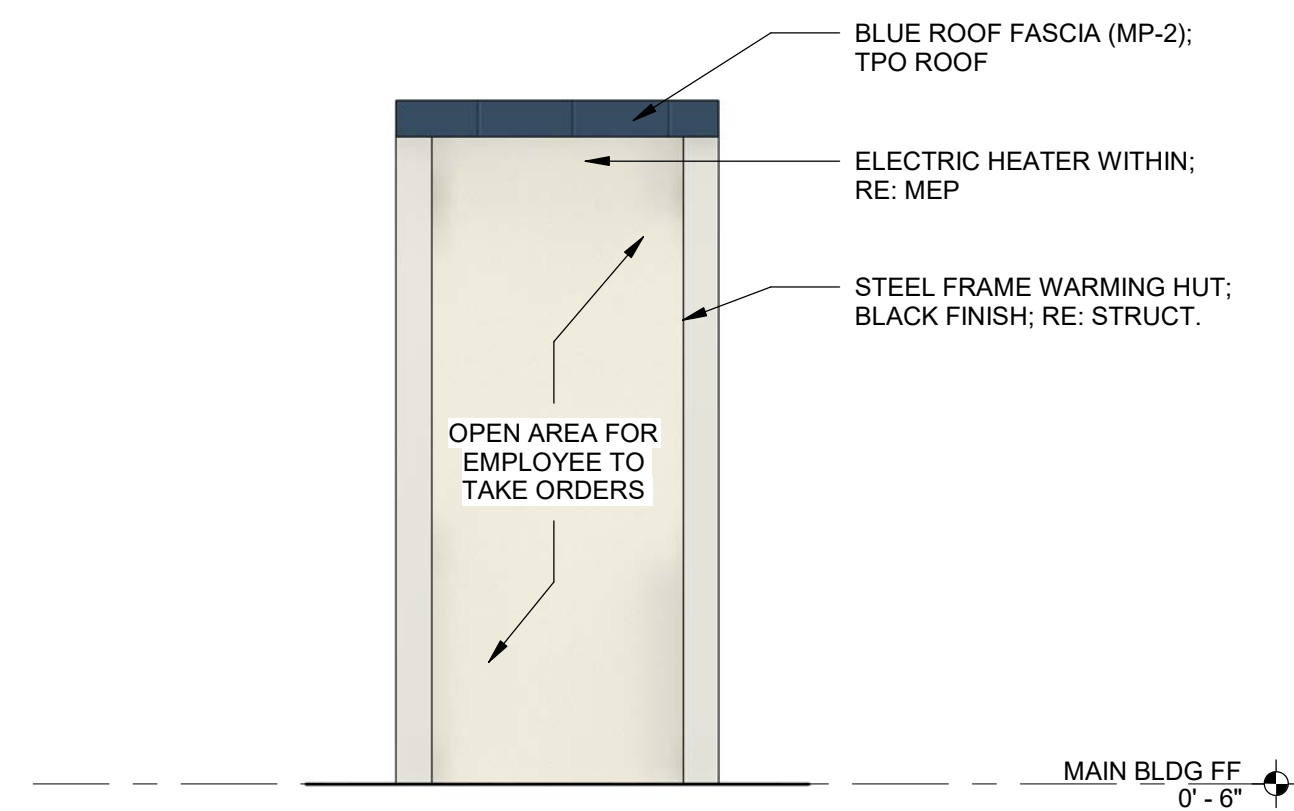


4 WARMING HUT ELEVATION - FRONT
3/8" = 1'-0"

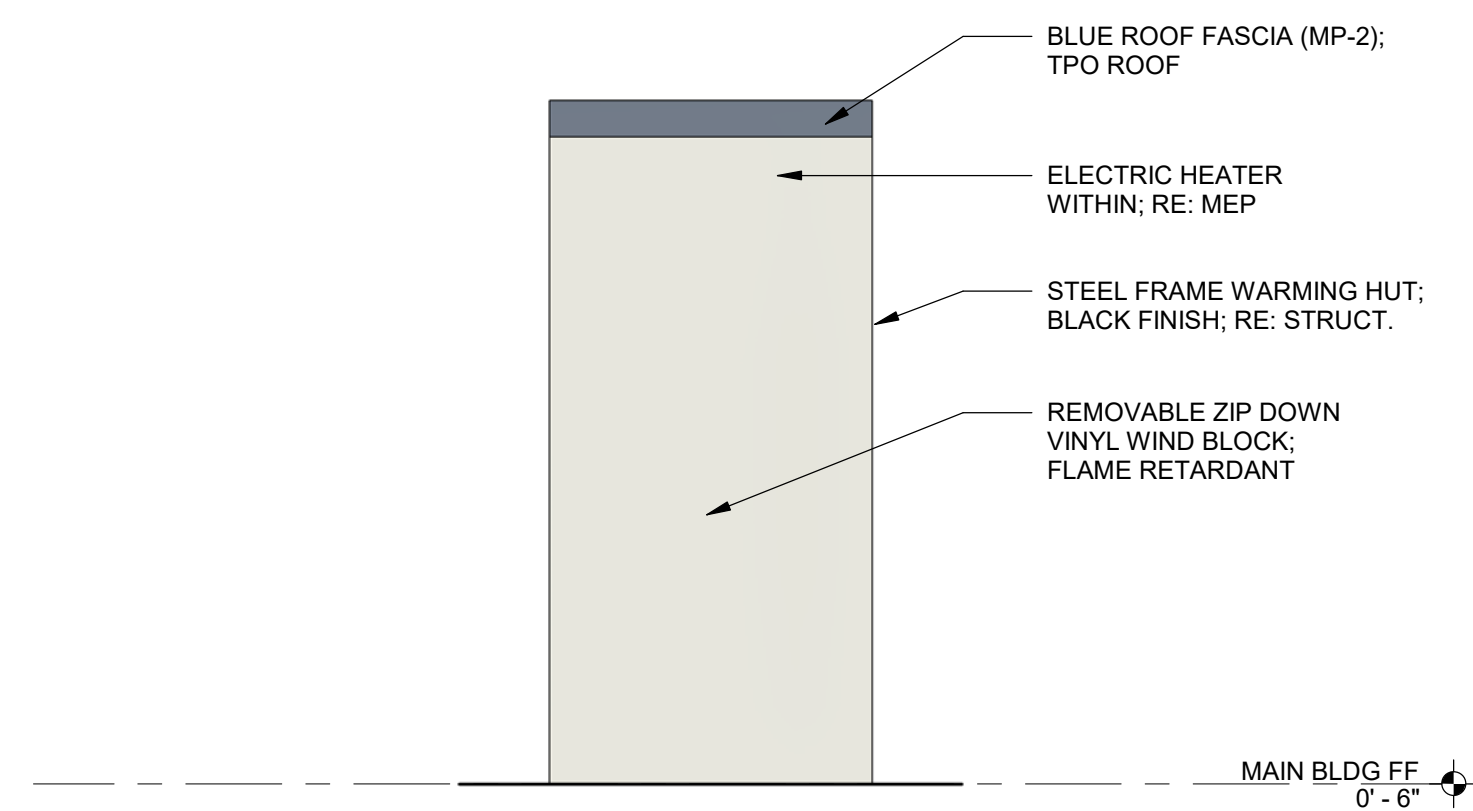


3 WARMING HUT ELEVATION - BACK
3/8" = 1'-0"

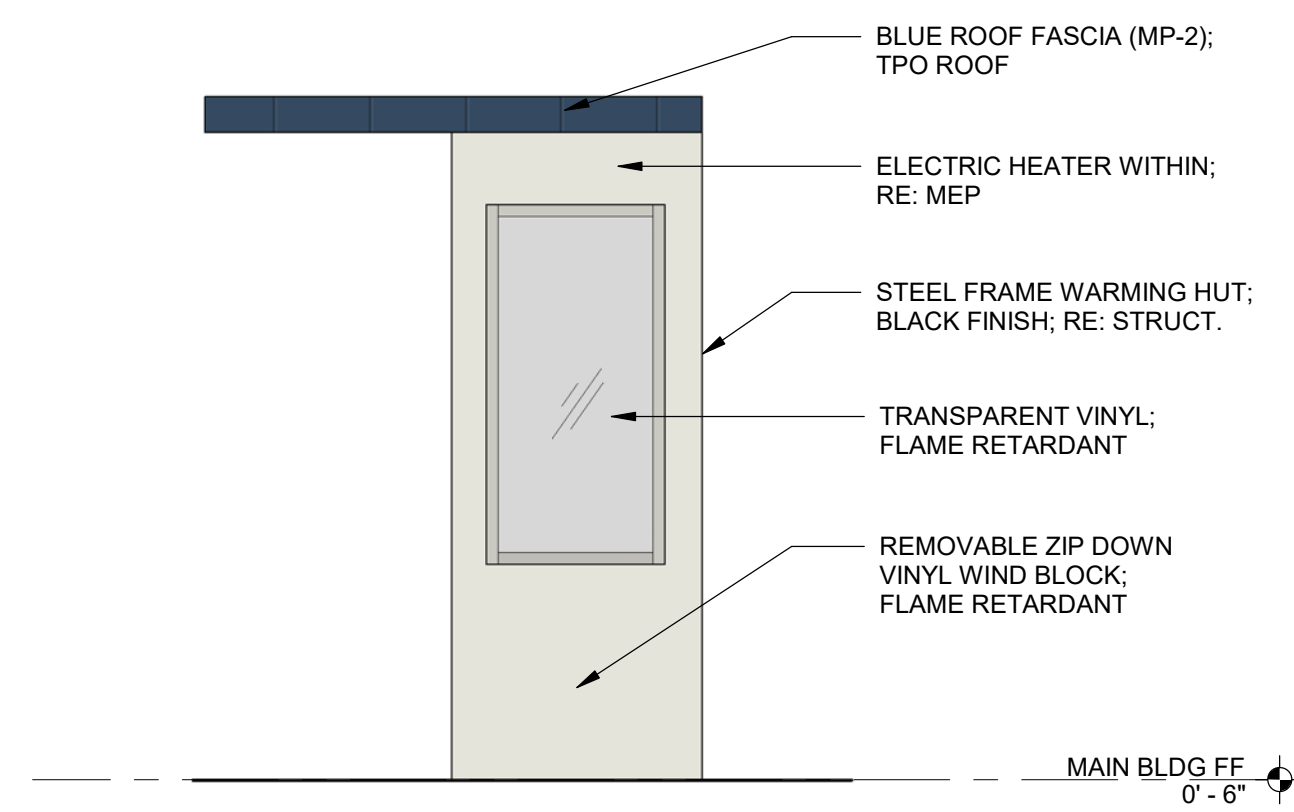


2 WARMING HUT ELEVATION - LEFT
3/8" = 1'-0"

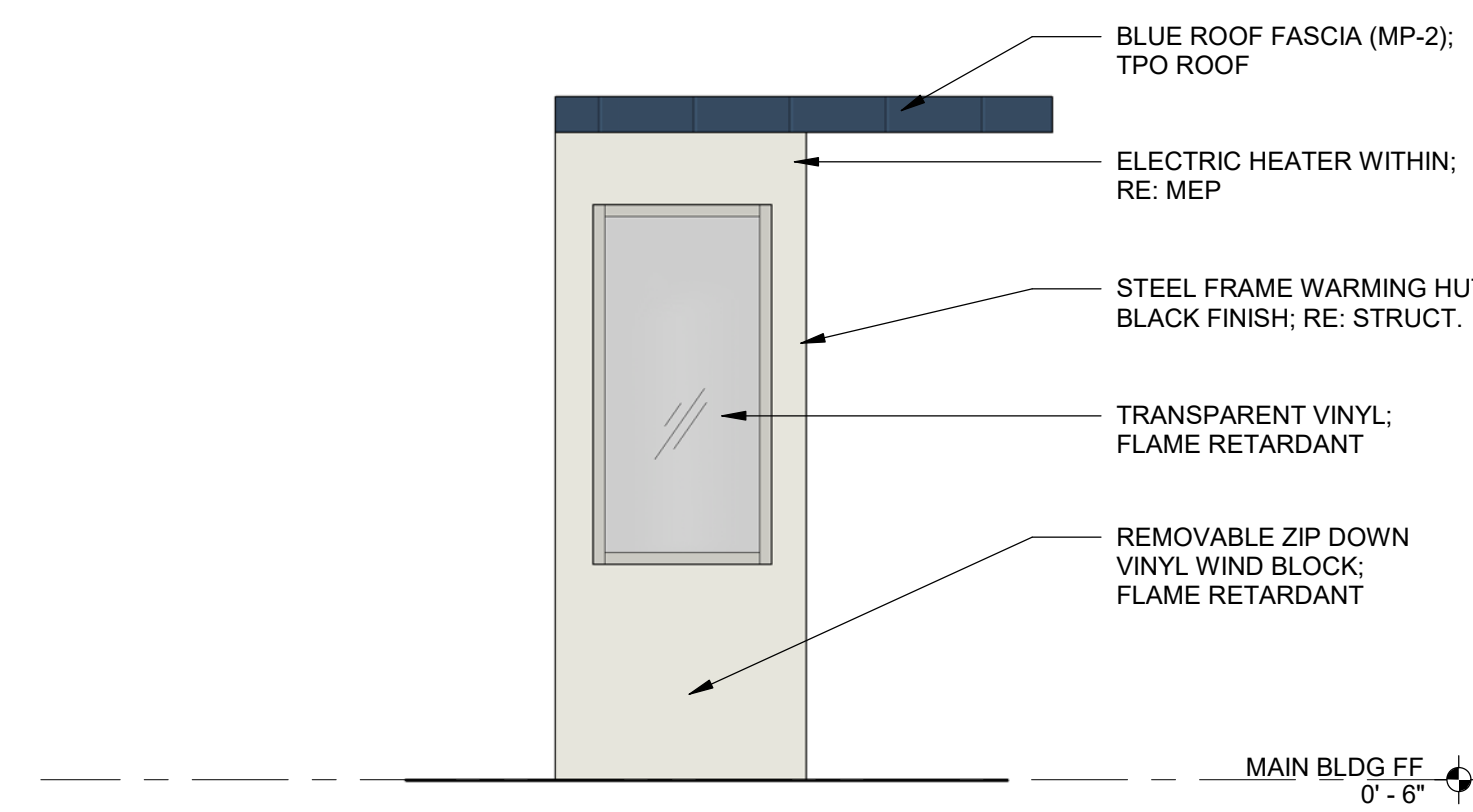

 1 WARMING HUT ELEVATION - RIGHT
3/8" = 1'-0"



 BLUE METAL PANEL MP-2
BRAND: BERRIDGE
COLOR: ROYAL BLUE
FINISH: LOW SHEEN SMOOTH - REFLECTIVITY .26



COPING TRIM METAL MP-3; SCREENING METAL MP-4
BRAND: BERRIDGE
COLOR: ZINC GREY
FINISH: LOW SHEEN SMOOTH - REFLECTIVITY .39



VERTICAL METAL PANEL MP-1
BRAND: BERRIDGE
COLOR: ZINC GREY
FINISH: BR-12



FIBER CEMENT PANEL SIDING - BRK-1
BRAND: NICHHA
COLOR: STEELE
FINISH: TUFFBLOCK





RENDERINGS