


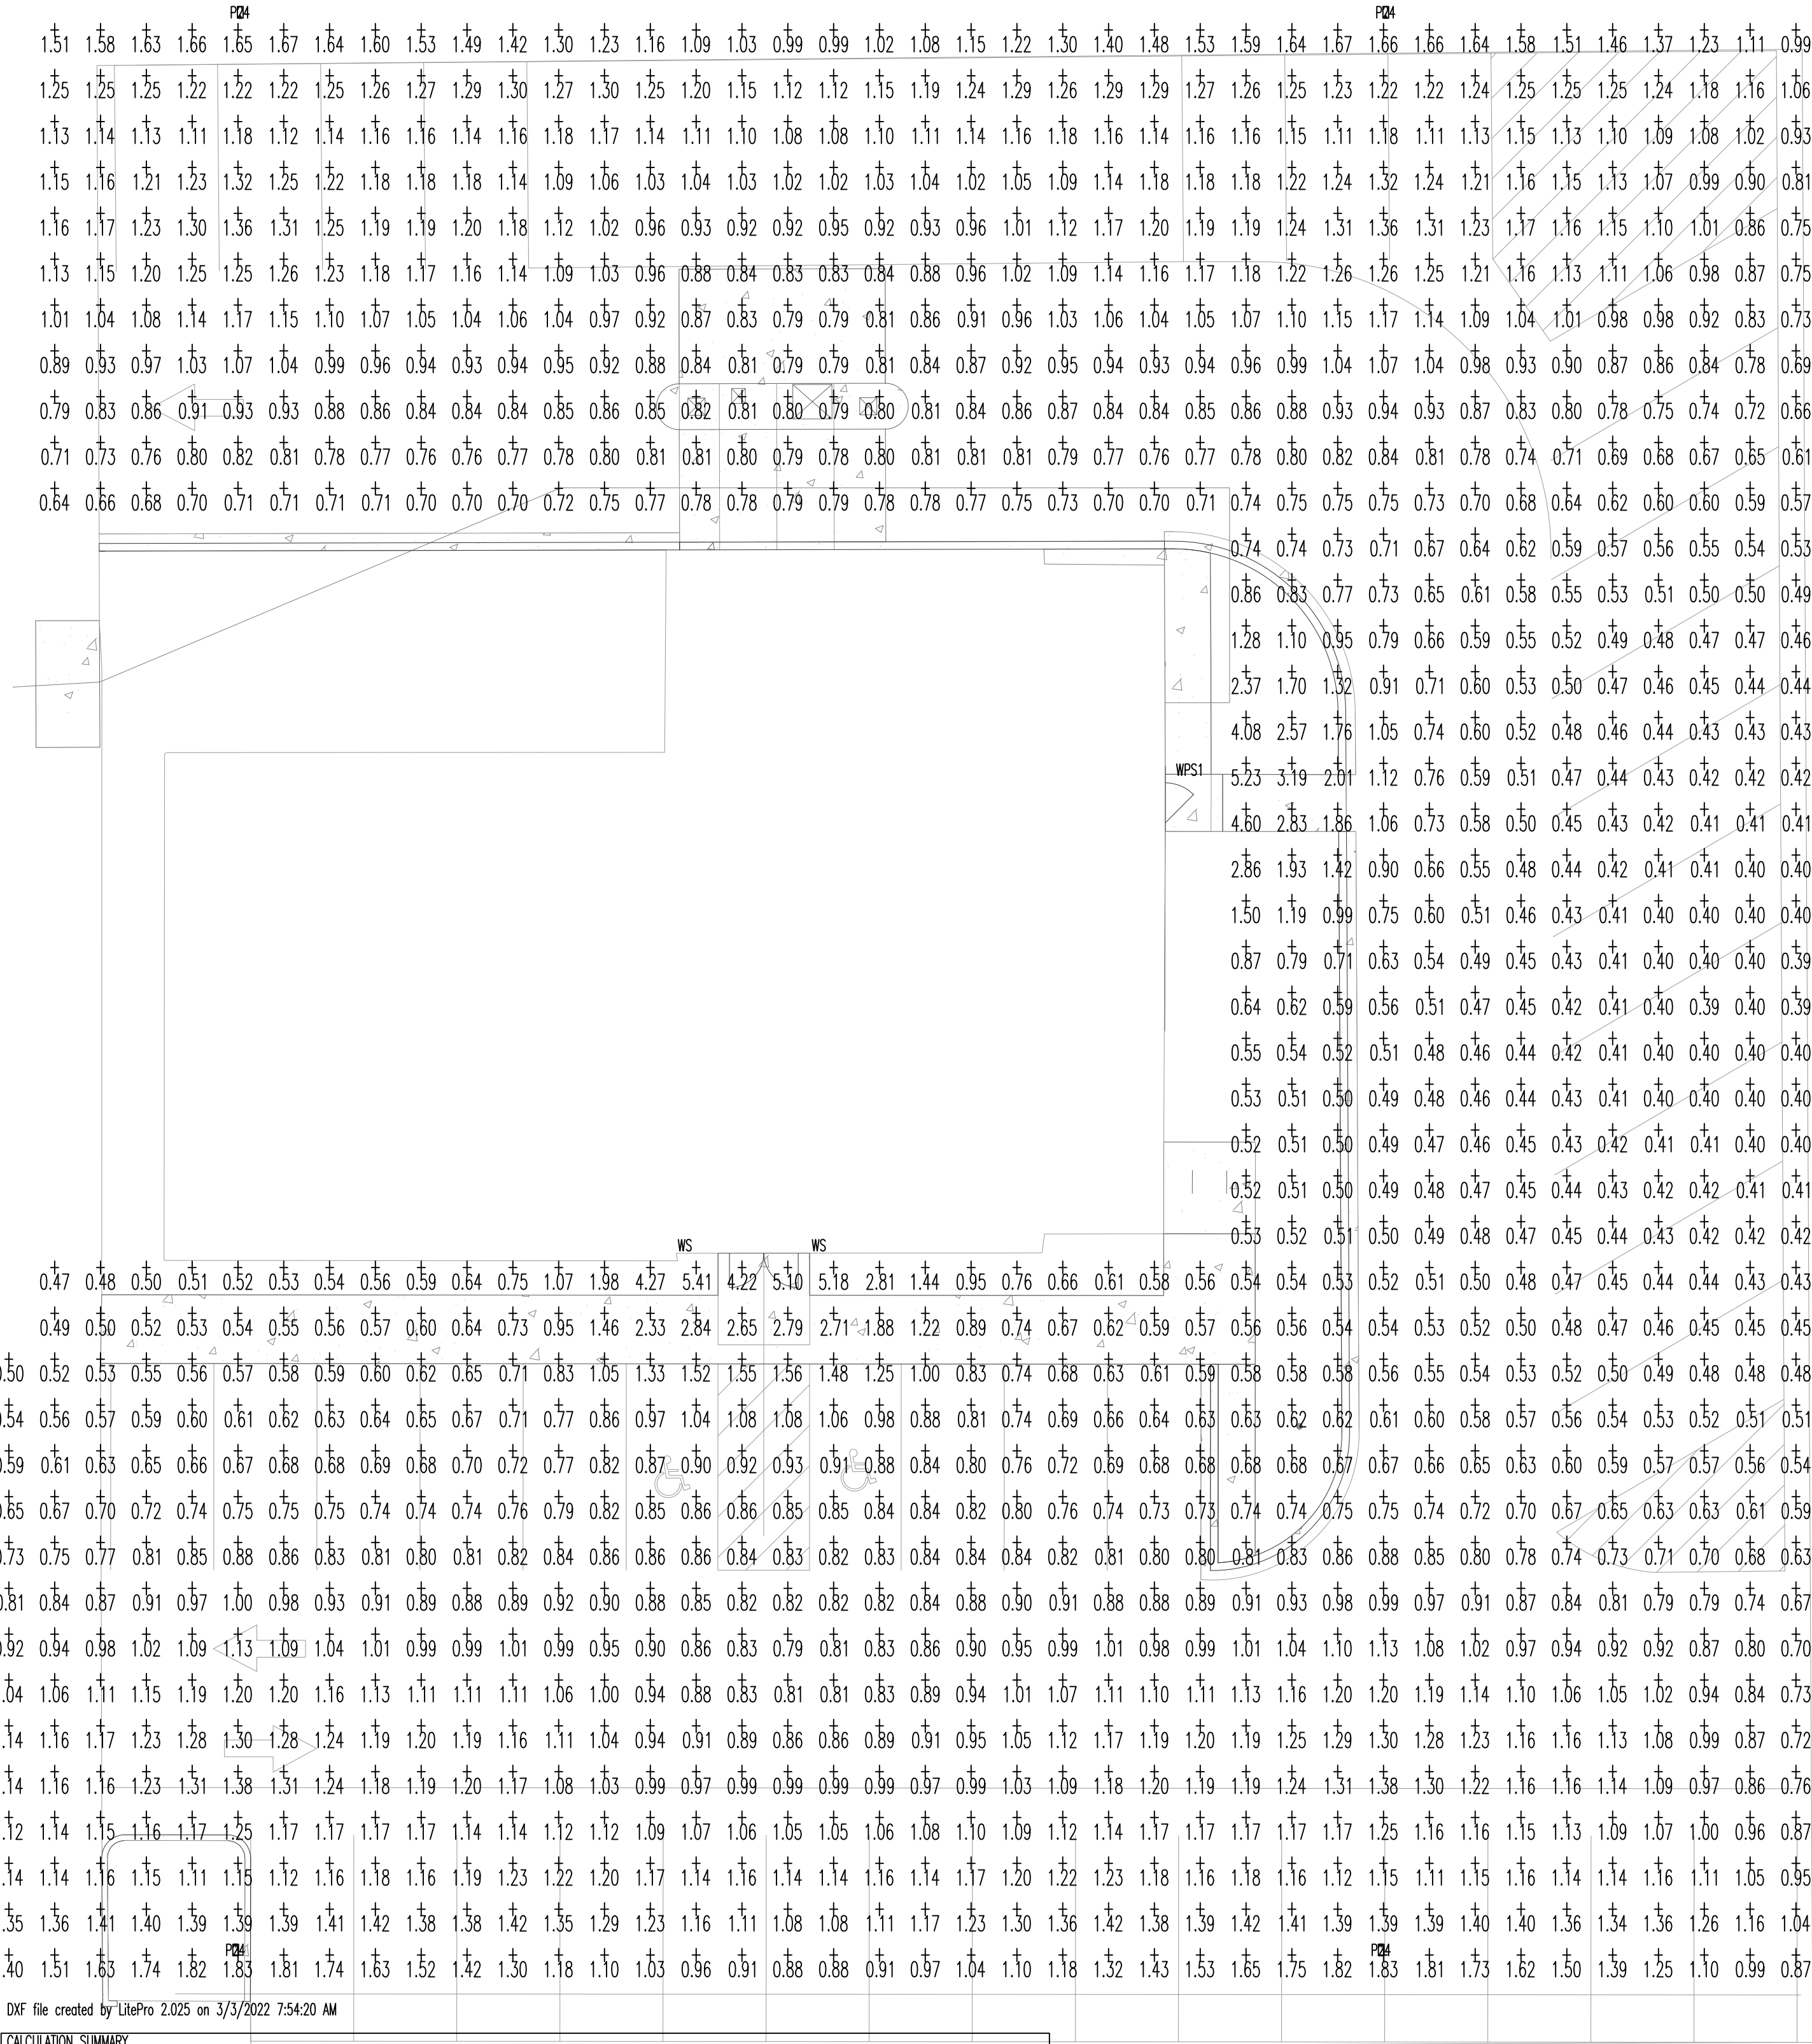

DXF file created by 'LitePro 2.025 on 3/3/2022 7:54:20 AM

CALCULATION SUMMARY									
AREA NAME	DIMENSIONS	GRID / TYPE	# PTS	SPAC	GROUP	AVE	MAX	MIN	MAX/MIN AVE/MIN
ccf parking lot	157.00x172.30ft	New Grid / H-H	1275	4.00	<+>	0.96	5.41	0.39	13.75 / 2.43

LUMINAIRE SCHEDULE					
TYPE	SYMBOL	DESCRIPTION	LAMP	LUMENS	MOUNTING/BALLAST
P24	□	COOPER LIGHTING GALN-SAZA-740-U-14ft GALLEON AREA AND ROADWAY LUMIN	(32)	-32	
WPS1	•	COOPER LIGHTING XTORT16 CROSSOUR 12W WALL MOUNT LED	(1)	-1	
WS	•	PROGRESS P5675-3030K 5" diameter up/down wall mount	(1) 93047261-4030	-1	

AREA SUMMARY SCHEDULE				
AREA NAME	I/O	DIMENSIONS	LUMS / <LUMS>	WATTS / SQ FT
ccf parking lot	OUT	157.00x172.30ft	P24 (4) WPS1 (1) WS (2)	0.02



Project Owner

CCF BANK
NEW LA CROSSE BRANCH BUILDING REMODEL

141 S 7TH ST. LA CROSSE, WI 54601

This drawing is an instrument of service and shall remain the property of Short Elliott Hendrickson, Inc. (SEH). This drawing, concepts and ideas contained herein shall not be used, reproduced, copied, or retained without the express written approval of SEH.

Submission or distribution of this drawing to meet official or regulatory requirements or for purposes in connection with the project is not to be construed as publication in derogation of any of the rights of SEH.

SEH Project	161151
Checked By	PDK
Drawn By	PDK

Project Status	Issue Date
BID SET	02-01-22

REVISION SCHEDULE

REV. #	DESCRIPTION	DATE
--------	-------------	------

ELECTRICAL
SITE PLAN



Eau Claire, Wisconsin
Telephone: 715-835-7738
Web: apexengineering.biz
Project No.: 21100