



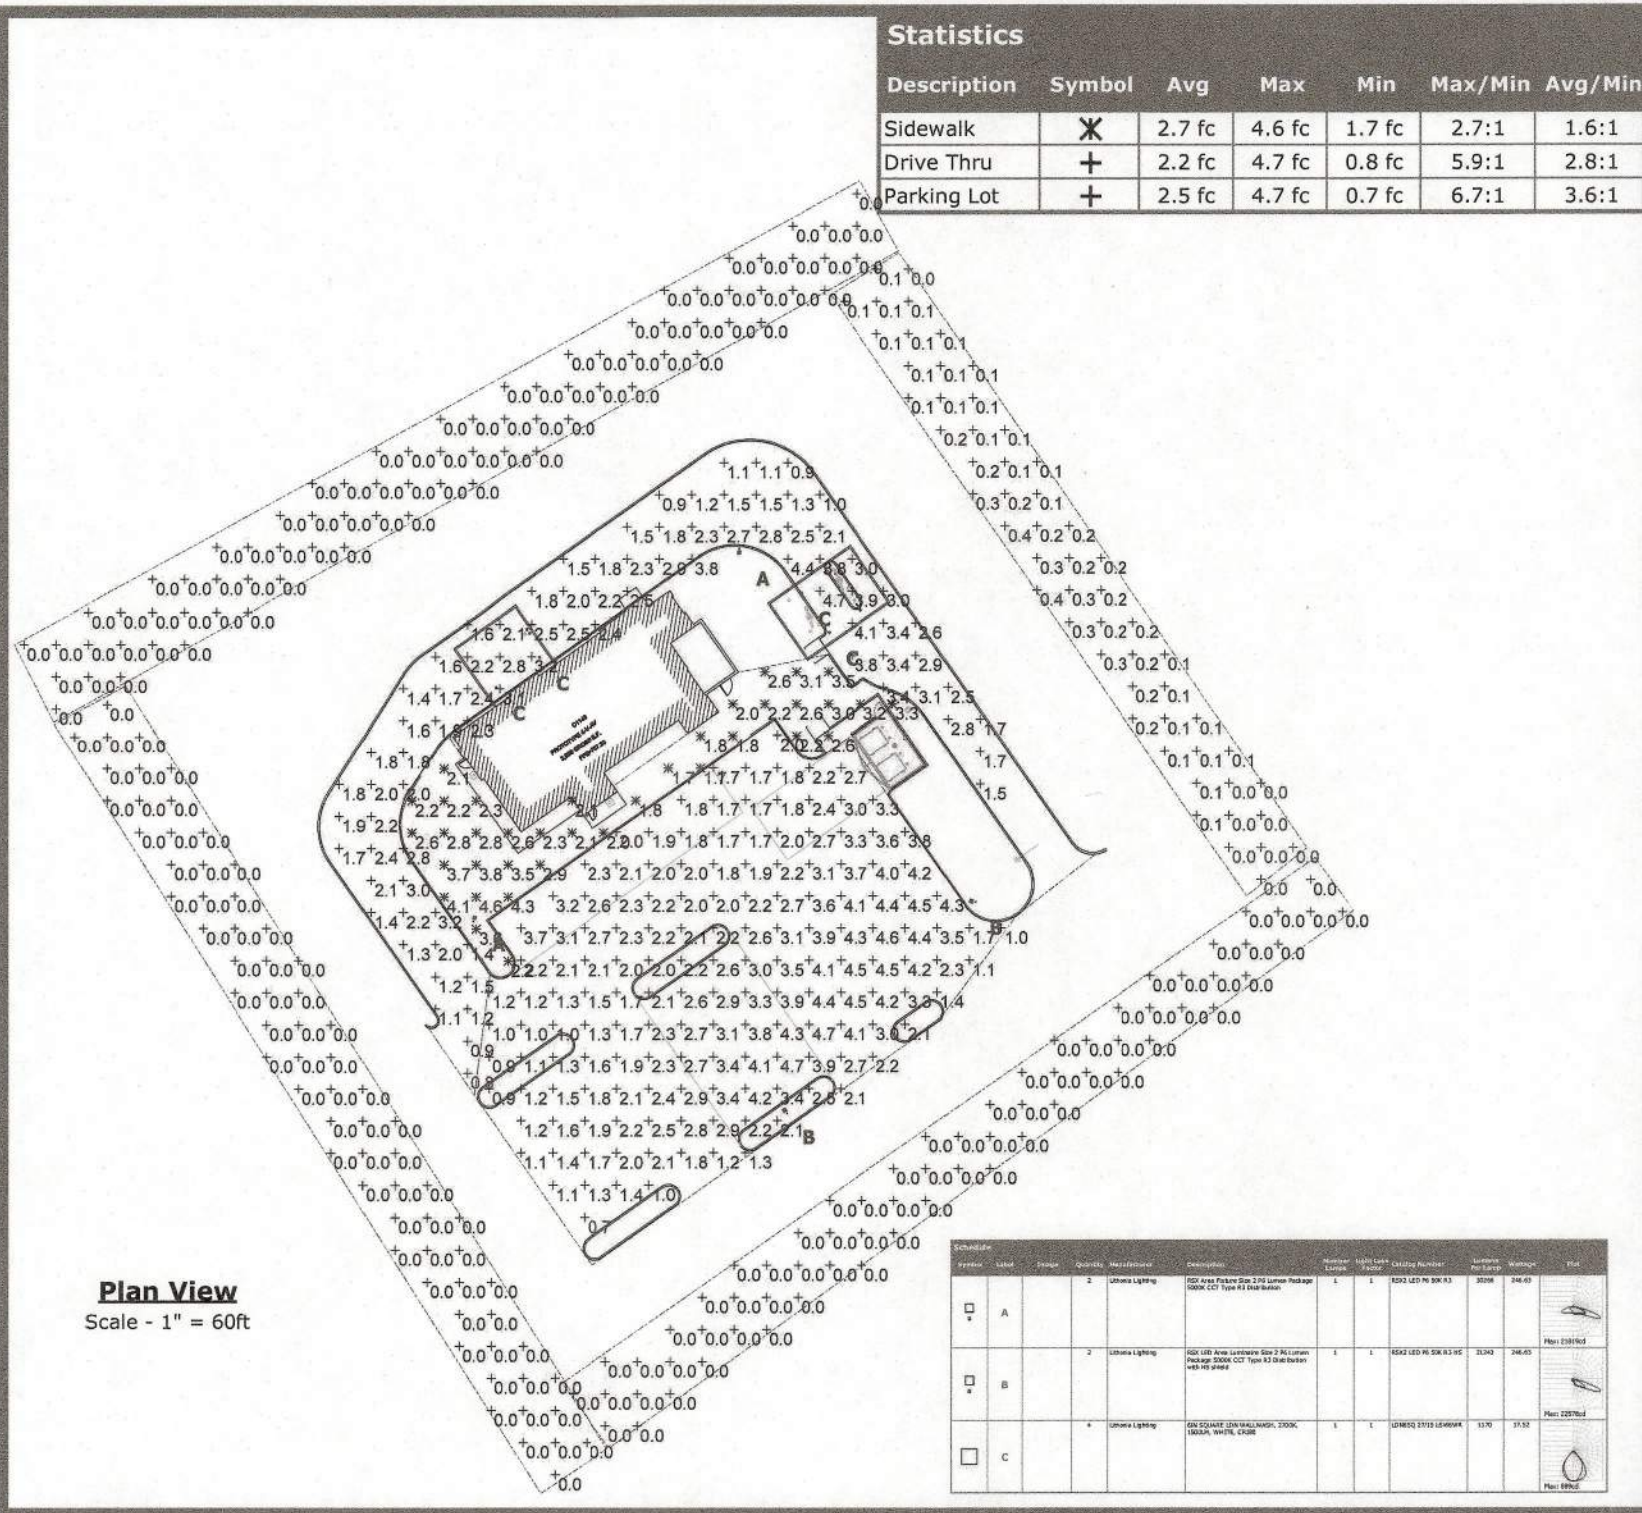

Raising Cane's
Restaurant #C1148
Hwy 16 & Braund St.
La Crosse, WI 54560
P4-V-AV

Designer
Samuel Heininger
Date
02/12/2024
Scale
1" = 60'
Drawing No.
230372.EX1
Summary
Photometric Site Plan

1 of 1

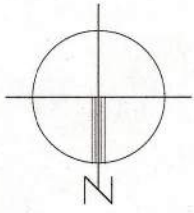


1 PHOTOMETRIC SITE PLANS

1" = 20'-0"

2 SITE LIGHTING PHOTOMETRIC DATA

ALL PHOTOMETRIC DATA IS TAKEN SHOWING HORIZONTAL FOOT CANDLES AT 3FT.

- MAX POLE HEIGHT FOR SITE: ?? FT
- AVERAGE FOOT CANDLES FOR SITE: ??FC
- MAXIMUM FOOT CANDLES FOR SITE: ??FC
- MAXIMUM FOOT CANDLES AT PERIMETER: ??FC

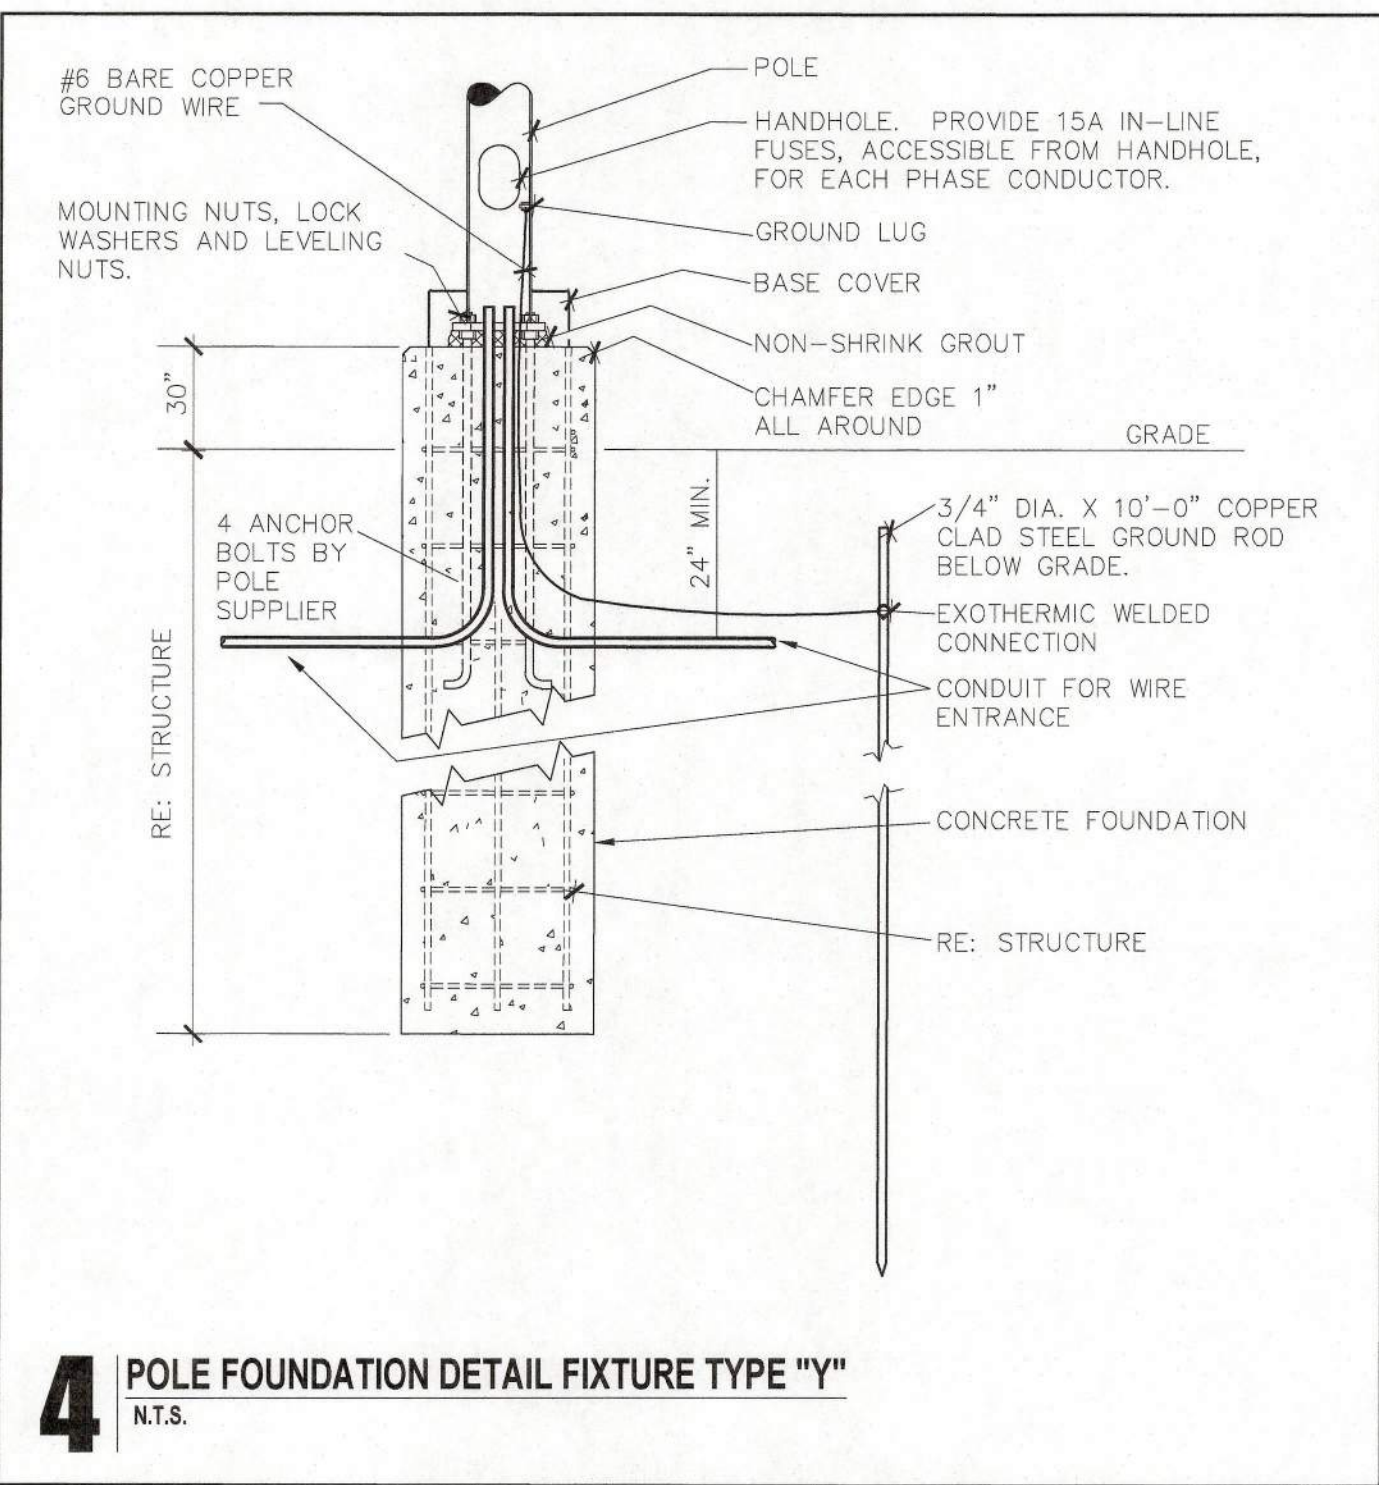

3 LIGHTING FIXTURE SCHEDULE (EXTERIOR)

Q	MANUF/NUMBER: LITHONIA/DMW2-L24-3000LM-ACL-MD-MVOLT-GZ1-35K-80 VOLTAGE: 120 FINISH: WHITE LAMP: QUANTITY- 18 WATTS- 18 TYPE- LED REMARKS: 2'-0" ENCLOSED, GASKETED LED STRIP FIXTURE WITH REINFORCED FIBERGLASS HOUSING. FIXTURE SHALL BE LISTED FOR WET LOCATIONS.	DD	REMARKS: LED STRING LIGHTS FOR INSTALLATION AFTER LANDSCAPING HAS GROWN. DO NOT PROVIDE, THEY SHALL BE PROVIDED AT A LATER DATE BY LANDSCAPING TO BE PLACED IN THE PLANTERS AND TREES AROUND THE PREMESIS. POWER VIA EXTERIOR RECEPTACLE CALLED OUT ON E2.1.
QE	MANUF/NUMBER: LITHONIA/DMW2-L24-3000LM-ACL-MD-MVOLT-GZ1-35K-80-PS1050 VOLTAGE: 120 FINISH: WHITE LAMP: QUANTITY- 18 WATTS- 18 TYPE- LED REMARKS: 2'-0" ENCLOSED, GASKETED LED STRIP FIXTURE WITH REINFORCED FIBERGLASS HOUSING. PROVIDE BATTERY BACKUP TO ACTIVATE IN THE EVENT OF A POWER OUTAGE. FIXTURE SHALL BE LISTED FOR WET LOCATIONS. SENSOR.	GG	MANUF/NUMBER: BOCK/VW15-G041/G-G0LVX01-19W-30K-120 VOLTAGE: 120 FINISH: BLACK LAMP: QUANTITY- 1 WATTS- 8 TYPE- LED REMARKS: LED JELLY JAR LIGHTING FIXTURE. COORDINATE ELEVATION AND LOCATION WITH ARCHITECTURAL ELEVATIONS.
R	MANUF/NUMBER: ATLAS/WL/MFC43LED VOLTAGE: 120 FINISH: BLACK LAMP: QUANTITY- 1 WATTS- 34 TYPE- LED REMARKS: LED WALL PACK WITH DIE CAST ALUMINUM HOUSING, SPECULAR REFLECTOR AND BOROSILICATE GLASS REFRACTOR. FIXTURE SHALL BE LISTED FOR WET LOCATIONS.	HH	MANUF/NUMBER: CUSTOM LED COVE LIGHT PROVIDED BY AGI AND INSTALLED BY CONTRACTOR VOLTAGE: 120 FINISH: BLACK LAMP: QUANTITY- 1 WATTS- 8 TYPE- LED REMARKS: LED WALL MOUNTED WRAP LIGHTS TO BE MOUNTED IN ARCHITECTURAL ELEMENT AT THE ROOF PARAPITS. PROVIDE ALL NECESSARY PERIPHERALS TO HAVE A COMPLETE AND WORKING SYSTEM. PROVIDE DRIVERS IN THE CLOSEST ACCESSIBLE CEILING SPACE OR DIRECTLY NEXT TO AN ACCESS HATCH. DO NOT MOUNT DRIVERS EXPOSED.
S1	MANUF/NUMBER: ACUTY BRANDS/LDN6S027/15MVOLTZ1HSGU REMARKS: SUPPLIED WITH AWNING. CONTRACTOR SHALL CONNECT TO CIRCUIT INDICATED ON PLAN.	II (BLUE DOG)	MANUF/NUMBER: SPI LIGHTING/SEW-12146-3FT-L43W-AN08-120-27TV-30K-3FT-RUN-OAP 18'-DF-MCS VOLTAGE: 120 FINISH: BLACK LAMP: QUANTITY- 1 WATTS- 18 TYPE- LED REMARKS: LED WALL MOUNTED SIGN LIGHTER. COORDINATE ELEVATION AND LOCATION WITH ARCHITECTURAL ELEVATIONS. PROVIDE THIS FOR THE BLUE DOG MURAL.
S1E	MANUF/NUMBER: ACUTY BRANDS/LDN6S027/15MVOLTZ1ELHSG REMARKS: SUPPLIED WITH AWNING. CONTRACTOR SHALL CONNECT TO CIRCUIT INDICATED ON PLAN, AND PROVIDE A BATTERY BACKUP MOUNTED ABOVE THE TRUSSES ON THE INTERIOR TO POWER THE LIGHT IN THE CASE OF A POWER OUTAGE.	II (FLAMING ARROW AND MURAL).	MANUF/NUMBER: SPI LIGHTING/SEW-12146-3FT-L43W-AN08-120-27TV-30K-3FT-RUN-OAL 14'-DF-MCS VOLTAGE: 120 FINISH: BLACK LAMP: QUANTITY- 1 WATTS- 18 TYPE- LED REMARKS: LED WALL MOUNTED SIGN LIGHTER. COORDINATE ELEVATION AND LOCATION WITH ARCHITECTURAL ELEVATIONS. PROVIDE THIS FOR THE FLAMING ARROW.
S2	MANUF/NUMBER: LSI/CURS-SC-LED-SS-50-UE-WHT REMARKS: SUPPLIED WITH MENU CANOPY. CONTRACTOR SHALL CONNECT TO CIRCUIT INDICATED ON PLAN.	JJ	MANUF/NUMBER: MODERN FORMS/CI-WS-W70612 VOLTAGE: 120 FINISH: BLACK LAMP: QUANTITY- 1 REMARKS: MODERN FORMS/CI-WS-W70612
X	MANUF/NUMBER: WAC LIGHTING/FM-2605-BK VOLTAGE: 120 FINISH: BLACK LAMP: QUANTITY- 1 WATTS- 18 TYPE- LED REMARKS: 3" LED PENDANT MOUNTED CYLINDER WITH CLEAR SATIN REFLECTOR AND BLACK HOUSING. SHALL BE ENERGY STAR RATED, AND HAVE 0-10V DIMMING. COLOR TEMPERATURE SHALL BE 3000K.		
Y1	MANUF/NUMBER: LITHONIA/RXS2-LED-P6-50K-R3-HS VOLTAGE: 208 FINISH: DARK BRONZE LAMP: QUANTITY- 1 WATTS- 250 TYPE- LED REMARKS: LED POLE MOUNTED FIXTURE WITH SEGMENTED ALUMINUM OPTICS AND HOUSE SIDE SHIELD. 30' TALL SQUARE STRAIGHT STEEL POLE, LITHONIA SSS-30-5G-DM19-DOB		
Y2	MANUF/NUMBER: LITHONIA/RXS2-LED-P6-R5 VOLTAGE: 208 FINISH: DARK BRONZE LAMP: QUANTITY- 1 WATTS- 250 TYPE- LED REMARKS: LED POLE MOUNTED FIXTURE WITH SEGMENTED ALUMINUM OPTICS AND HOUSE SIDE SHIELD. 30' TALL SQUARE STRAIGHT STEEL POLE, LITHONIA SSS-30-5G-DM19-DOB		
AA	MANUF/NUMBER: PERFORMANCE LIGHTING/75460-NS/310374 VOLTAGE: 120 FINISH: BLACK LAMP: QUANTITY- 1 WATTS- 24 TYPE- LED REMARKS: GROUND MOUNTED LIGHTING FIXTURE. PROVIDE WITH NON-SLIP LENS. REFER TO DETAIL 2 ON E3.2 FOR CONCRETE MOUNTING.		
CC	MANUF/NUMBER: TIVOLI/LSL-B-18-S-30-CILS-CABLE-110/LS-LOCK-4UT-60-1-5-12-D VOLTAGE: 120 FINISH: BLACK LAMP: QUANTITY- 1		



Restaurant Support Office
6800 Bishop Road, Plano, TX 75024
Tele: 972-769-3100 Fax: 972-769-3101

Restaurant:

Raising Cane's
Restaurant #C1148
Hwy 16 & Braund St
La Crosse, WI 54560
P4-V-AV (A)

Designer's Information:


SHREMSHOCK
Shremshock Engineering, Inc.
7775 Walton Parkway Suite 250 New Albany, OH 43054
t: 614 545 4550 | f: 614 545 4555 | shremshock.com

Prototype Phase: 2023

Project Issue Date: 00-00-0000

SAI Project Manager: PDS

100% SUBMISSION
03-11-2024

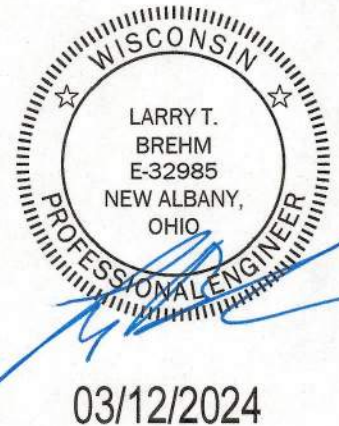

Sheet Versions:		
#	Date	Description
-	-	-
-	-	-
-	-	-
-	-	-
-	-	-
-	-	-
-	-	-

Sheet Title:

Photometric Site
Plan

Sheet Number:

E1.1

SAI Job Number: 230372