


Luminaire Schedule						
Qty	Label	MFG	Description	LLF	Lum. Watts	Total Watts
3	P1	LITHONIA	RAD1 LED P3 30K SYM MVOLT RPA DBLBXD + 10' POLE	0.950	54	162
17	B1	LITHONIA	RADB LED P4 30K SYM MVOLT BTSDBLBVD-BCCDBLBXD-DBBXD	0.950	19	323

Calculation Summary						
Label	Units	Avg	Max	Min	Max/Min	Avg/Min
SITE	Fc	0.71	33.61	0.00	N.A.	N.A.

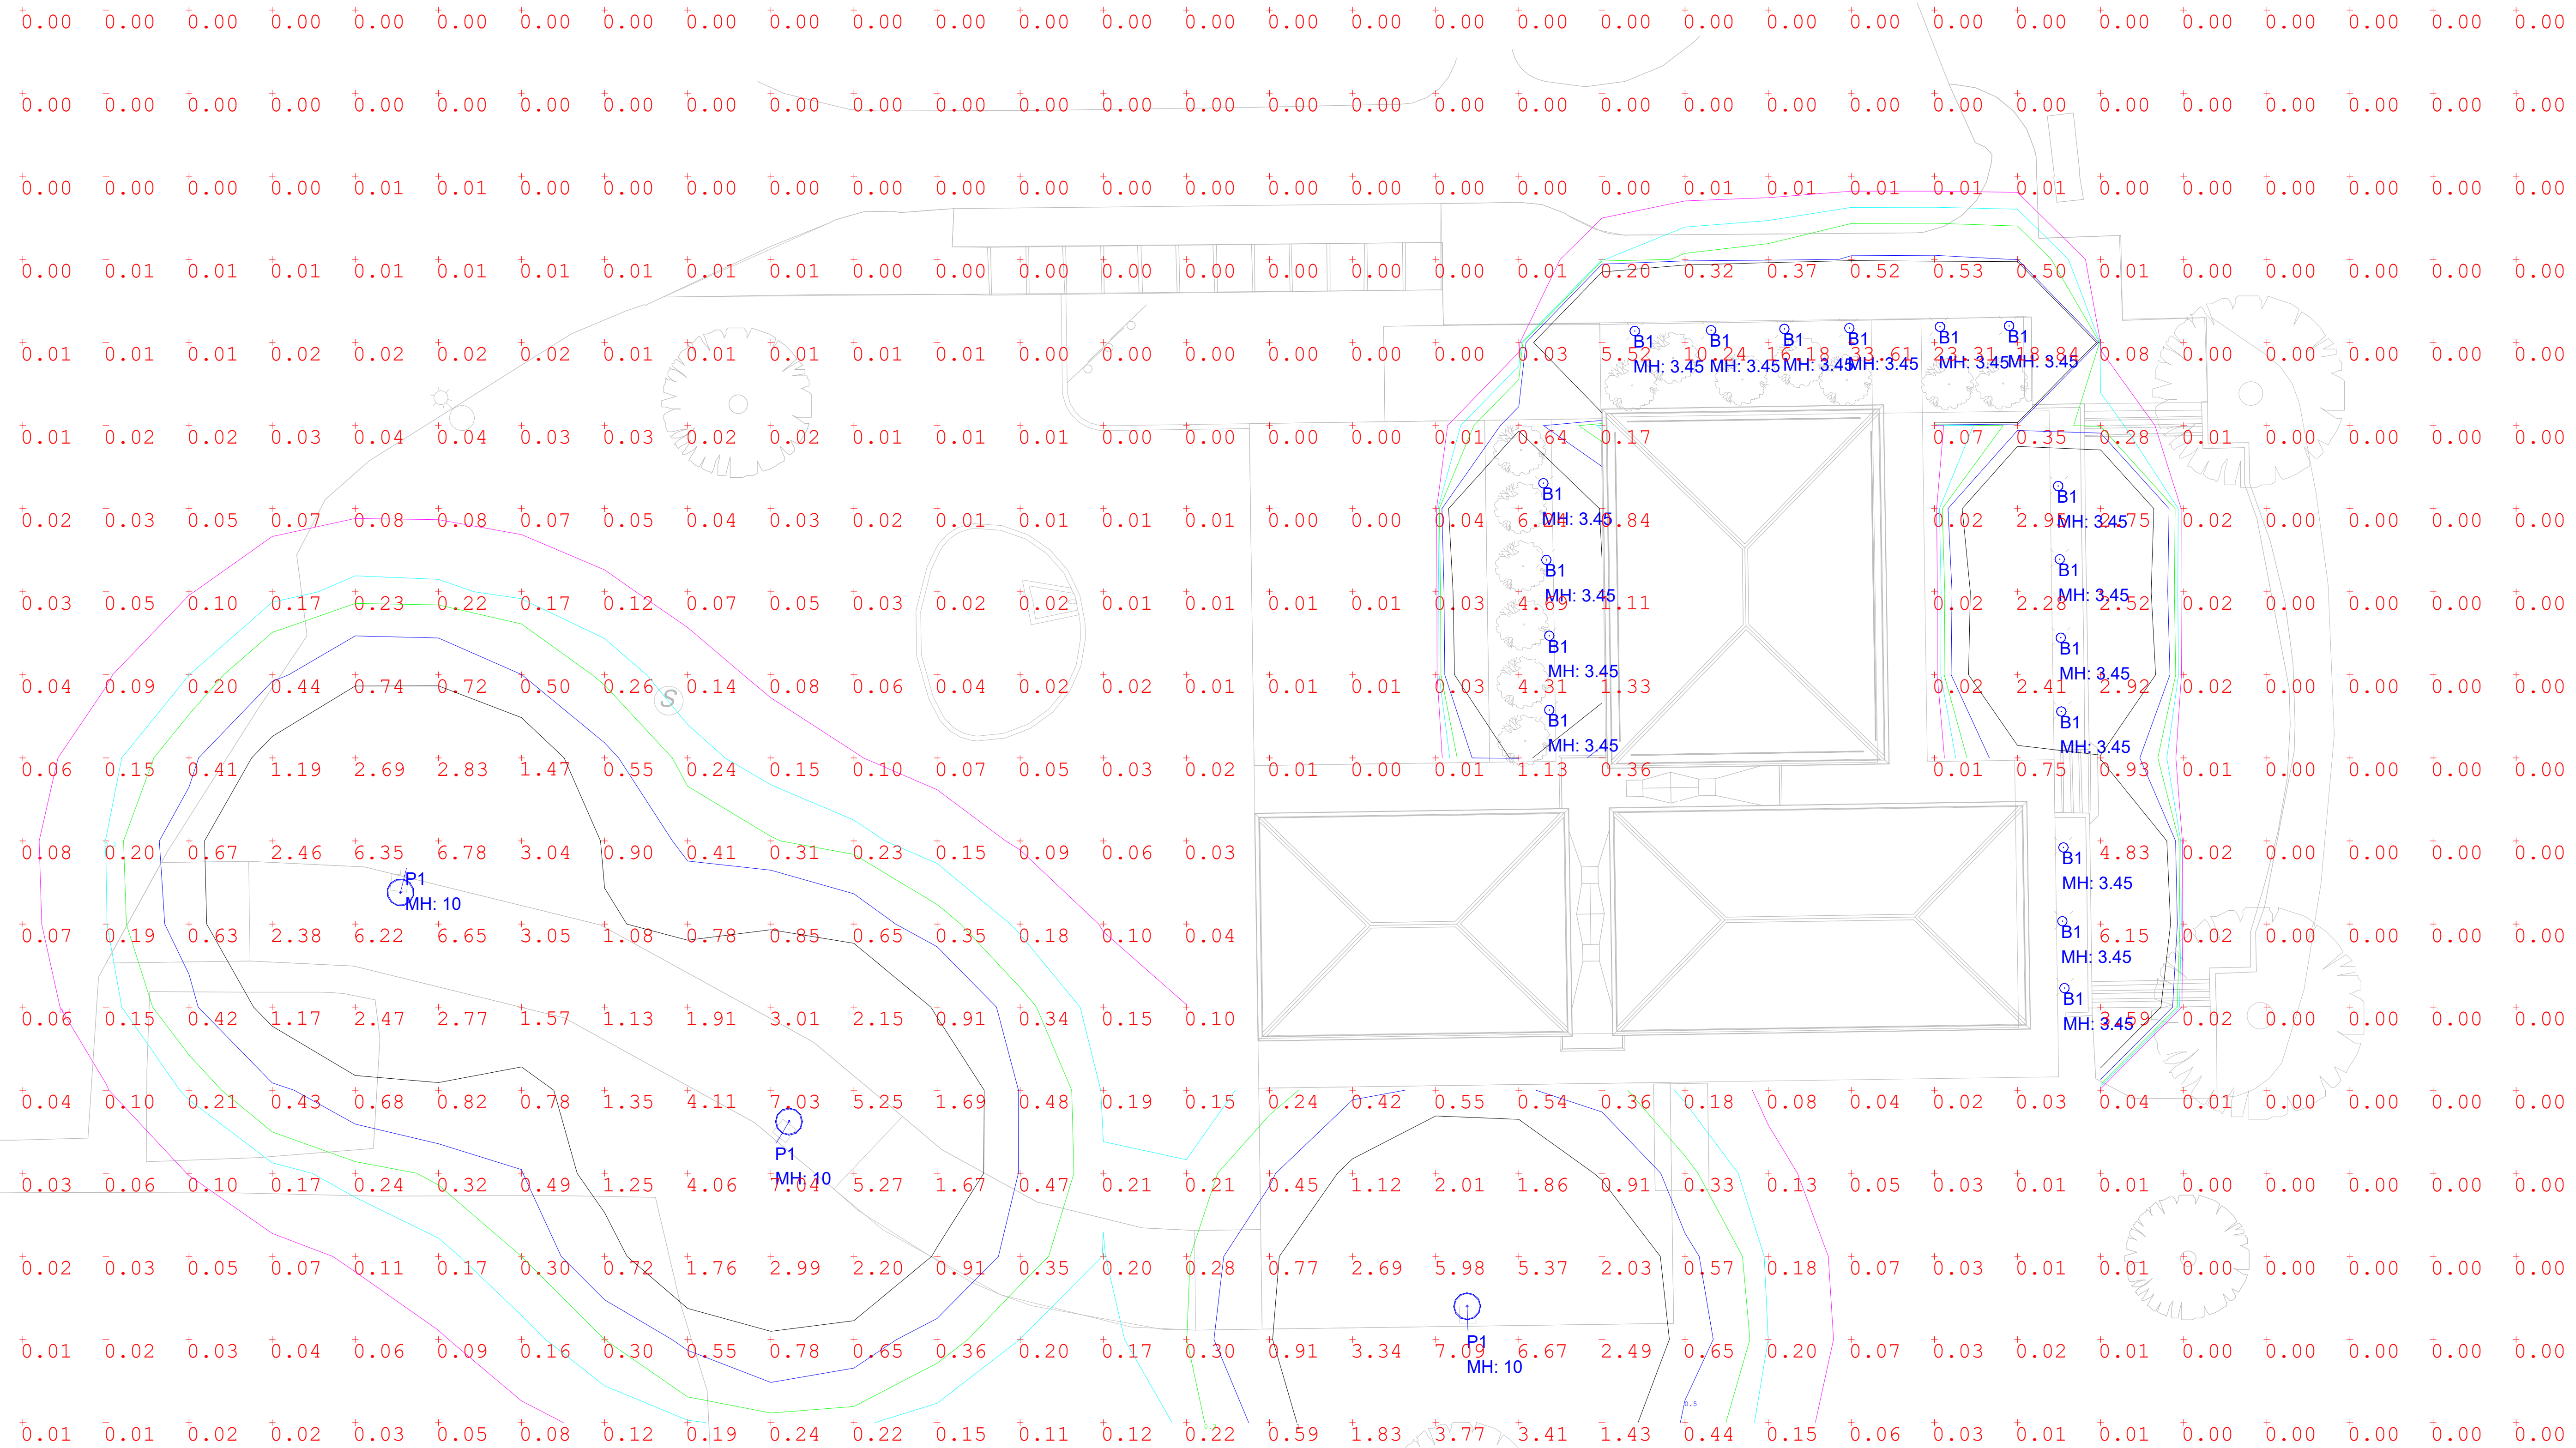

COMMENTS	
DATE	
#	
REVISIONS	

DRAWN BY : JT	DATE : FEB 13 2024	SCALE : 3/32" = 1'
---------------	--------------------	--------------------

FOREST HILLS PAVILION	LA CROSSE, WI	SITE LIGHTING LAYOUT
-----------------------	---------------	----------------------